


GENERAL NOTES

- ALL OUTLET ELEVATIONS ARE MINIMUM TO CENTER OF BOXES AND ARE BASED ABOVE CONCRETE SLAB. TYPICAL ELEVATION IS 18" AFF U.O.N.

(X) SHEET KEYNOTES

- STUB UP ELECTRICAL FOR RTU INSIDE UNIT CURB AND DISCONNECT UNIT AT DISCONNECT. CONNECT DUCT SMOKE DETECTOR AND WP/GF RECEPTACLE.
- E.G. SHALL PROVIDE DISCONNECT SHOWN. PROVIDE CONDUIT FOR CONTROL WIRING TO INSIDE UNITS. ELECTRICAL CONTRACTOR SHALL MAKE ALL FINAL CONNECTIONS.
- 120V POWER CONNECTION TO PROVIDE CONDENSER FAN MOTOR AND DOOR ICE MAKER. PROVIDE ALL NECESSARY CONTROL WIRING PER MANUFACTURER INSTRUCTIONS.
- PROVIDE CONTROL WIRING FROM HOOD FAN TO CONTROL PANEL AS REQUIRED. SEE SHEET BE-8 FOR DETAILS.

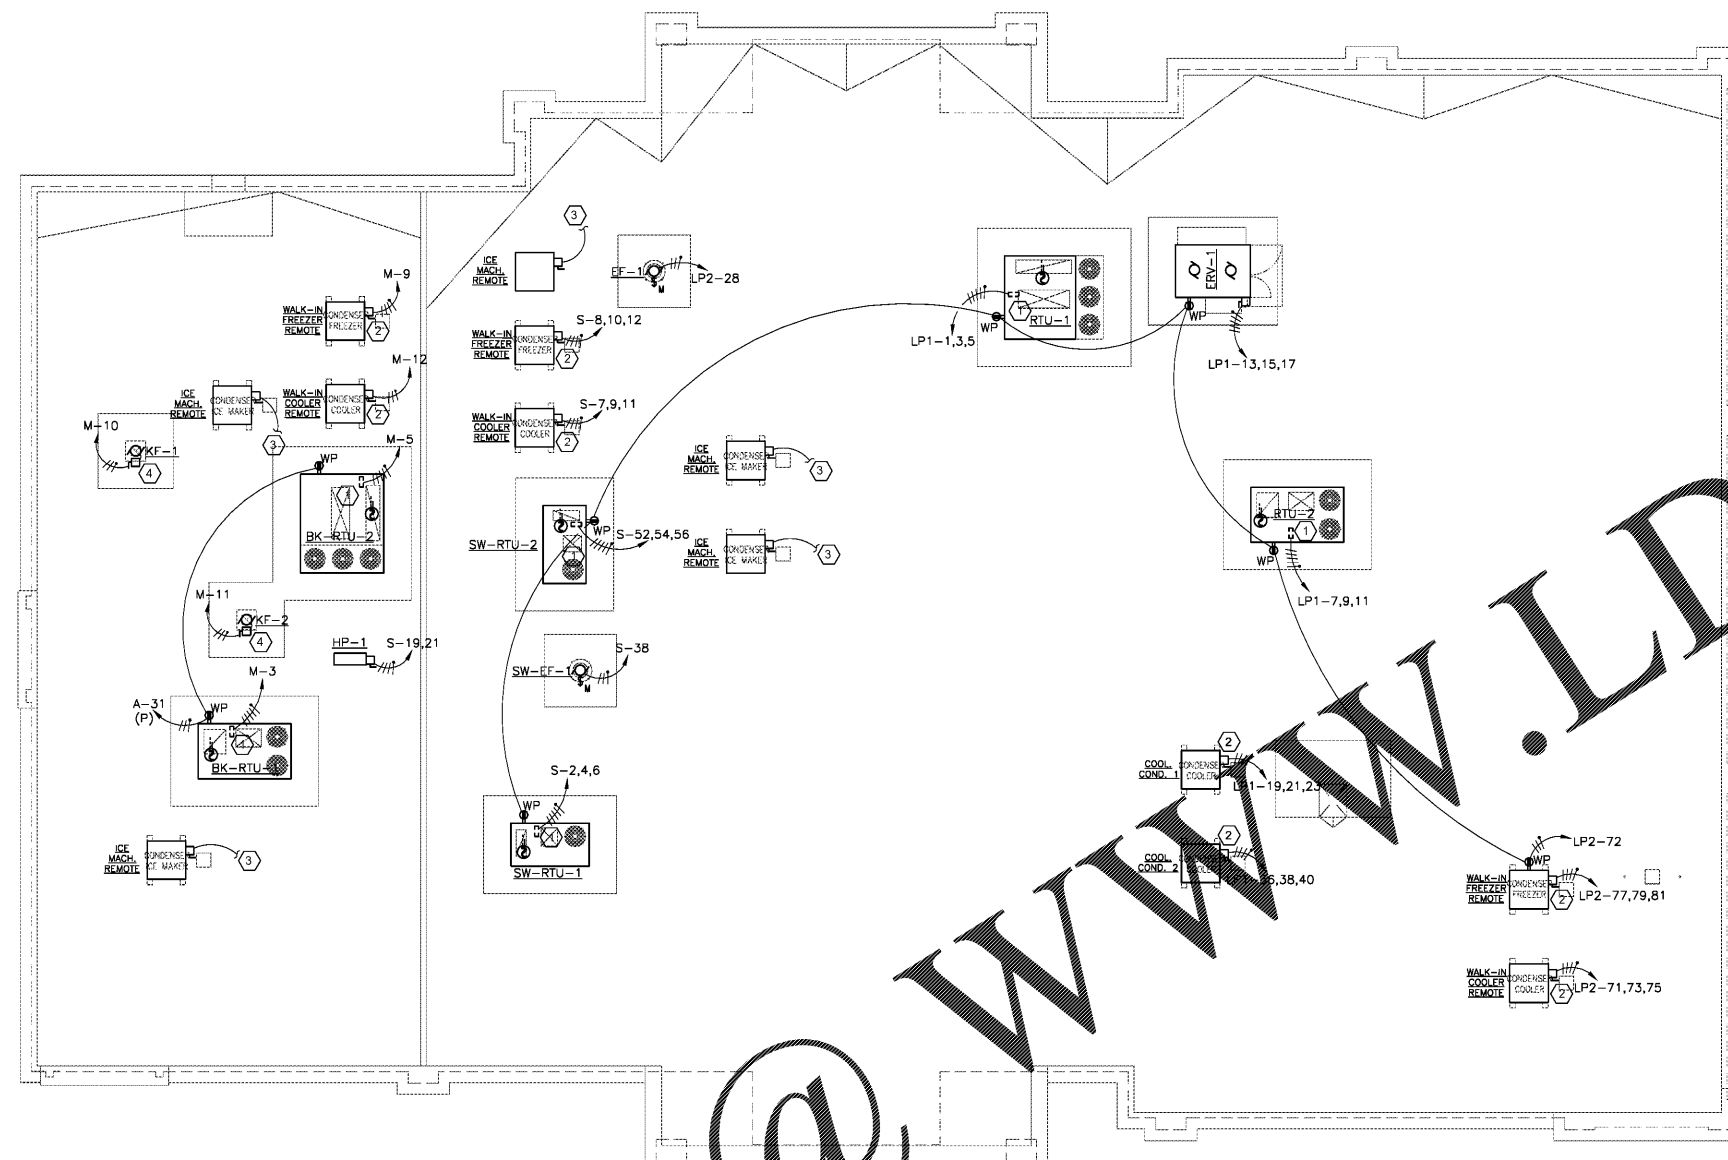

ROOF PLAN - POWER
1/8" = 1'-0"




MECHANICAL EQUIPMENT SCHEDULE

ID	VOLT	Φ	FLA	HP	KVA	FEEDER	MOCP	MCA	REMARKS / DISC. TYPE
LOVE'S									
AC-1	208	3			6	3 #10, #10 G. IN 3/4" C.			30/3 NEMA 1
COOL COND. 1,2	208	3	19			3 #10, #10 G. IN 3/4" C.	30	21	30/3 NEMA 3R
DWH-1,2	208	3			54	3 #3/0, #8 G. IN 2" C.			200/3 NEMA 1
ERV-1	208	3		(2) 3		4 #10, #10 G. IN 1" C.	25	23.2	30/3 NEMA 3R
RTU-1	208	3	116			4 #1, #6 G. IN 2" C.	150	127	DISC. FURN. W/ EQUIP.
RTU-2	208	3	80			4 #2, #8 G. IN 1 1/2" C.	90	66	DISC. FURN. W/ EQUIP.
WALK-IN COOLER COND.	208	3	8.2			3 #12, #12 G. IN 1/2" C.	15	15	30/3 NEMA 3R DISC.
WALK-IN FREEZER COND.	208	3	23			3 #10, #10 G. IN 3/4" C.	30	29	30/3 NEMA 3R DISC.
SUBWAY									
HP-1	208	1				3 #8, #10 G. IN 3/4" C.	40	32	60/2 NEMA 3R DISC.
SW-RTU-1	208	3	61.6			4 #4, #8 G. IN 1 1/2" C.	70	68	DISC. FURN. W/ EQUIP.
SW-RTU-2	208	3	42			4 #8, #10 G. IN 1" C.	50	47	DISC. FURN. W/ EQUIP.
SW-DH-1	208	3			4	3 #12, #12 G. IN 1/2" C.			30/3 NEMA 1 DISC.
SW-EF-1	120	1		<1/4		3 #12, #12 G. IN 1/2" C.			MOTOR STARTER SW.
BURGER KING									
BK-DWH-1	208	3			24	3 #2, #8 G. IN 1 1/2" C.			100/3 NEMA 1 DISC.
BK-RTU-1	208	3			45	4 #8, #10 G. IN 1" C.	150	127	DISC. FURN. W/ EQUIP.
BK-RTU-2	208	3			60	4 #4, #8 G. IN 1 1/2" C.	150	135	DISC. FURN. W/ EQUIP.
KF-1,2	208	1		1		2 #12, #12 G. IN 1/2" C.			30/2 NEMA 3R DISC.
WALK-IN COOLER COND.	208	1	6.3			2 #12, #12 G. IN 1/2" C.	15	15	30/2 NEMA 3R DISC.
WALK-IN FREEZER COND.	208	3	11			3 #12, #12 G. IN 1/2" C.	25	15	30/3 NEMA 3R DISC.

Order Plans @

WWW.LDILine.com

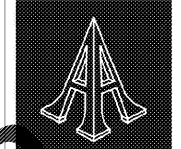

Pascal Aughtry & Associates, PC

405.463.3434
Fax: 405.463.3493
937 East Britton Road
Oklahoma City, OK 73114
pasc@arch.com



A NEW TRAVEL STOP
STORE NO. 735
CALHOUN, GA



Revisions:

No.	Date

Project No.: LVS - 18735
Date: 05-22-18
Sheet No.:

E-3.2
OF: