



1 FLOOR PLAN
TEMPERATURE CONTROL ZONES
SCALE: NONE

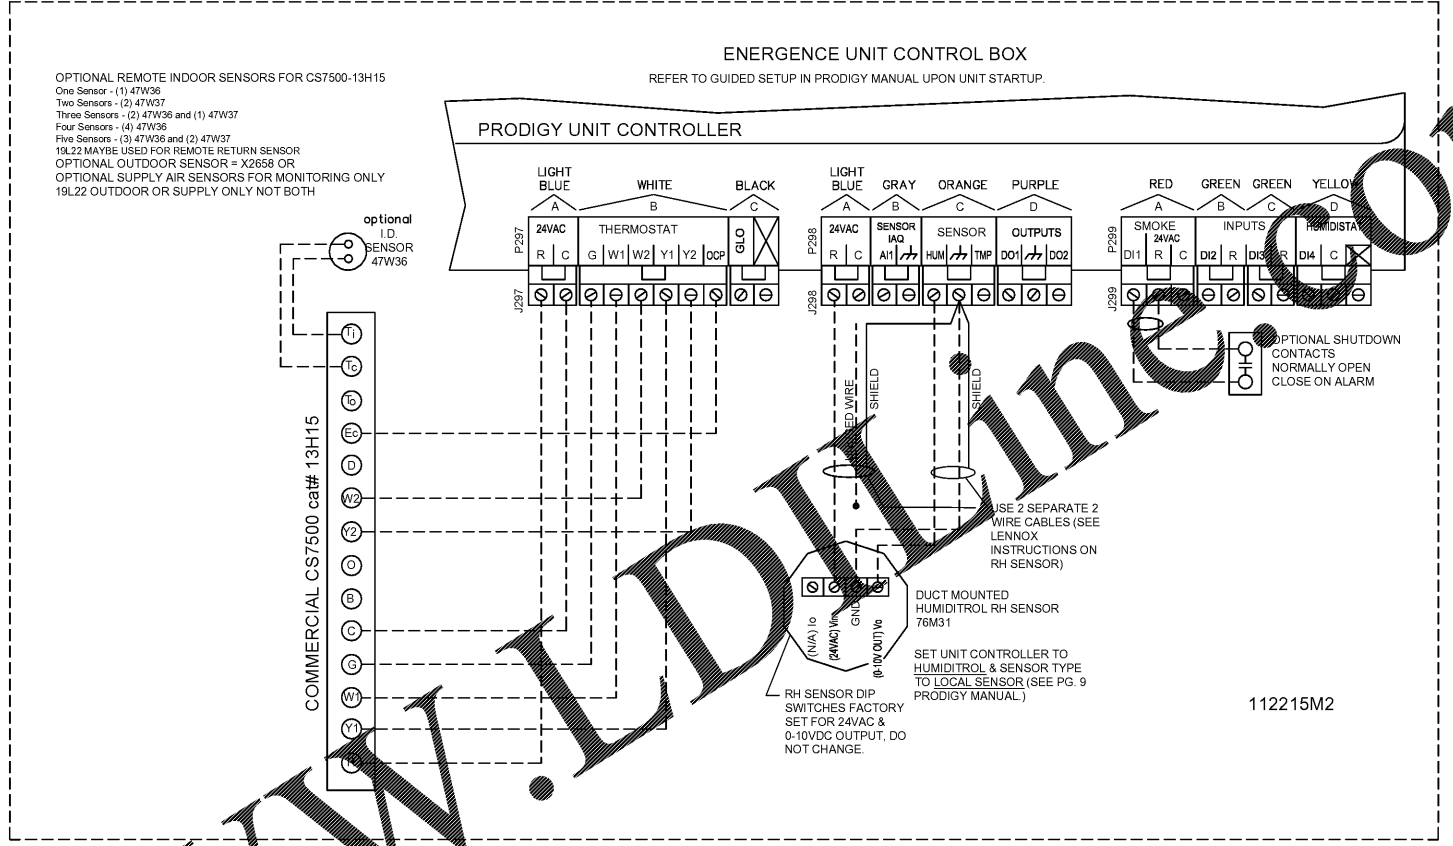

2 LENNOX
TEMPERATURE CONTROL WIRING DIAGRAM
SCALE: NONE

Order Plans @

WWW.LDDLINE.COM

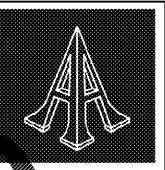

Pascal Aughtry & Associates, PC
405.463.3494
Fax: 405.463.3493
937 East Britton Road
Oklahoma City, OK 73114
pascalarch.com



A NEW TRAVEL STOP
STORE NO. 735
CALHOUN, GA



Revisions:	
No.	Date

Project No.: LVS - 18735
Date: 05-22-18
Sheet No.:

SWM3.2
OF: