



(A) REFLECTED CEILING PLAN
SCALE: 3/16" = 1'-0"

- LEGEND:**
- DECORATIVE PENDANT LIGHTING CENTER OVER TABLE BY TENANT
 - 2x4 RECESSED LIGHTING BY G.C.
 - RECESSED CAN LIGHT BY G.C.
 - RECESSED WALL WASH LIGHT BY G.C.
 - DECORATIVE PENDANT LIGHTING BY TENANT
 - CAN LIGHTS
 - 1/2" GYP. BD. PRIMED BY G.C. PAINTED BY TENANT
 - CAN WALL WASH LIGHT
 - DECORATIVE PENDANT LIGHTING BY TENANT
 - PREFABRICATED METAL CANOPY (2'-5"x2'-0")
 - INDICATES WALLS TO ROOF DECK
 - INDICATES FURR DOWNS
 - 1/2" GYP. BD. PRIMED BY G.C. PAINTED BY TENANT


NOTE: BRACE CEILING PER BKA-4/E PAINT HYAC DIFFUSERS TO MATCH FINISH OF ADJACENT GYP. BOARD CEILING

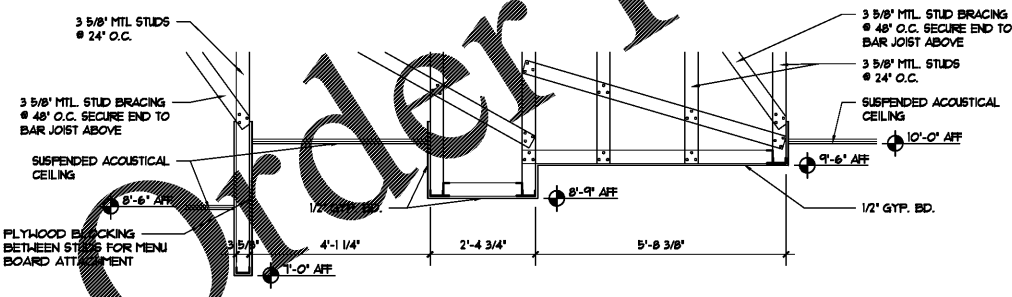


(B) CEILING SECTION
SCALE: 1/2" = 1'-0"

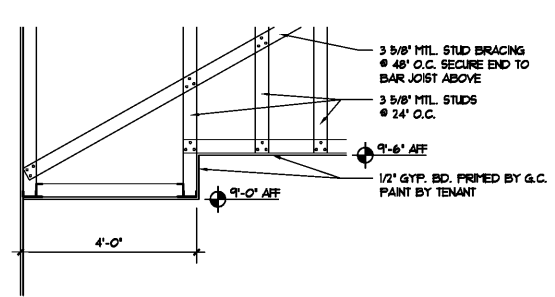

(C) CEILING SECTION
SCALE: 1/2" = 1'-0"

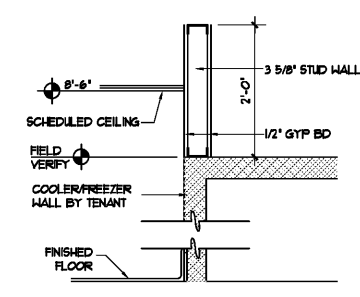

(D) PONY WALL DETAIL
SCALE: 3/4" = 1'-0"

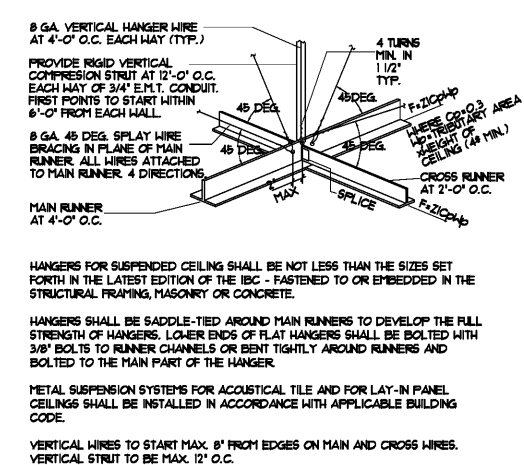

(E) CEILING BRACING DETAIL
SCALE: NOT TO SCALE

Order Plans

www.DownLine.com



Pascal Aughtry & Associates, PC

405.463.3494
Fax 405.463.3493
837 East Bilton Road
Oklahoma City, OK 73114
pascal@ah.com



Love's
Travel Stops

A NEW TRAVEL STOP
STORE NO. 735
CALHOUN, GA

Revisions:	
No.	Date

Project No.: LVS18735
Date: 05-22-18
Sheet No.:

BK-4

OF 12