



1 FLOOR PLAN  
TEMPERATURE CONTROL ZONES  
SCALE: NONE

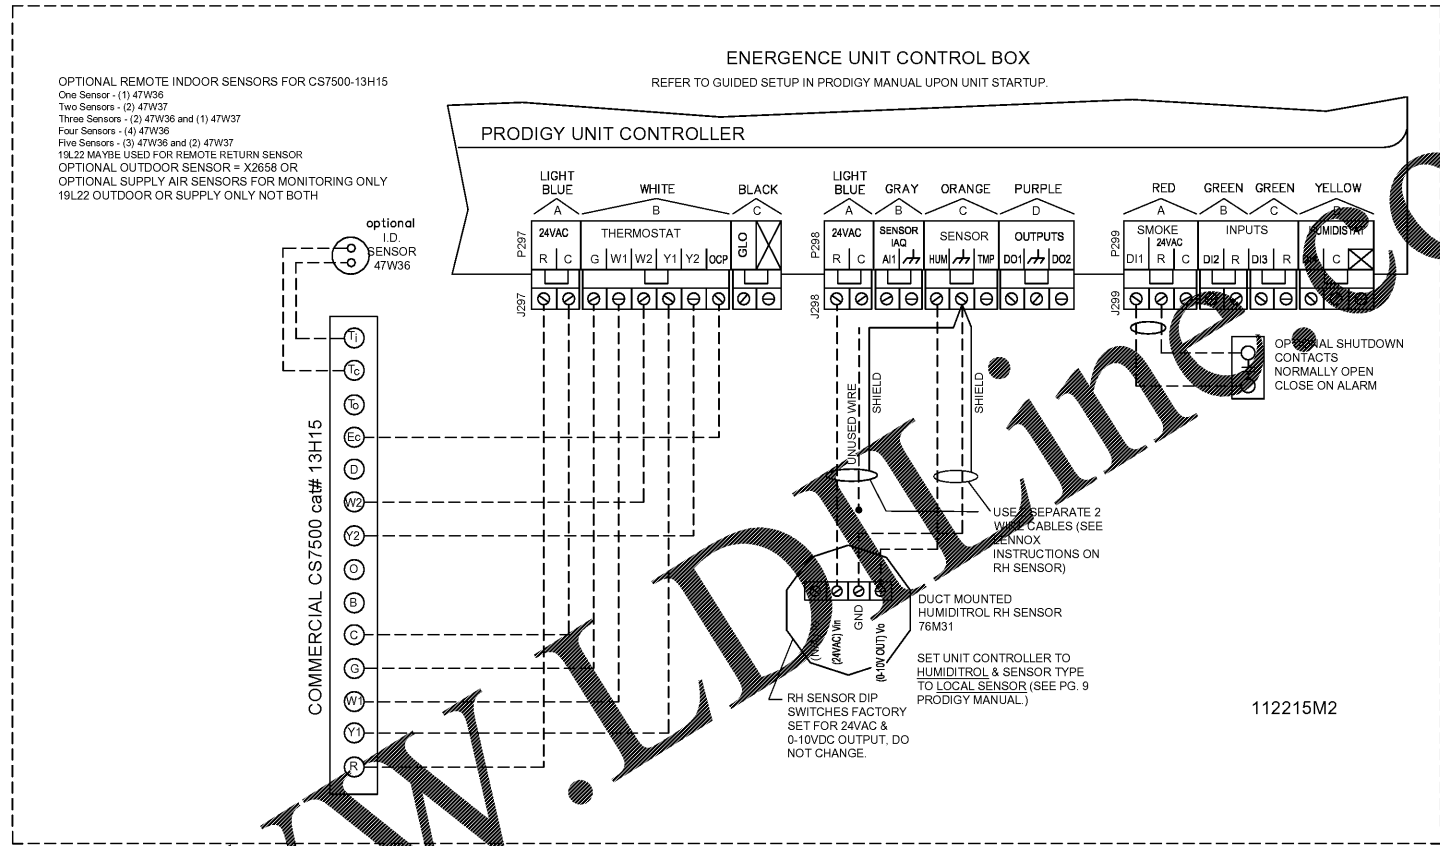


2 LENNOX  
TEMPERATURE CONTROL WIRING DIAGRAM  
SCALE: NONE

Order Plans @ WWW.LDLINE.COM

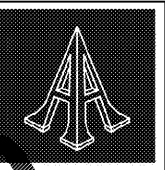

Pascal Aughtry & Associates, PC  
 405.463.3494  
 Fax: 405.463.3493  
 937 East Britton Road  
 Oklahoma City, OK 73114  
 pascalarch.com

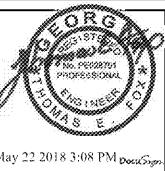

A NEW TRAVEL STOP  
 STORE NO. 735  
 CALHOUN, GA



Revisions:	
No.	Date

Project No.: LVS - 18735  
 Date: 05-22-18  
 Sheet No.:

**BKM3.2**  
 OF: