


C:\Users\daniel.green\Documents\Starbucks_Cypress Gardens & Roosevelt_FL_2017_daniel.green@interbrand.com.rvt 5/2/2018 12:04:00 PM

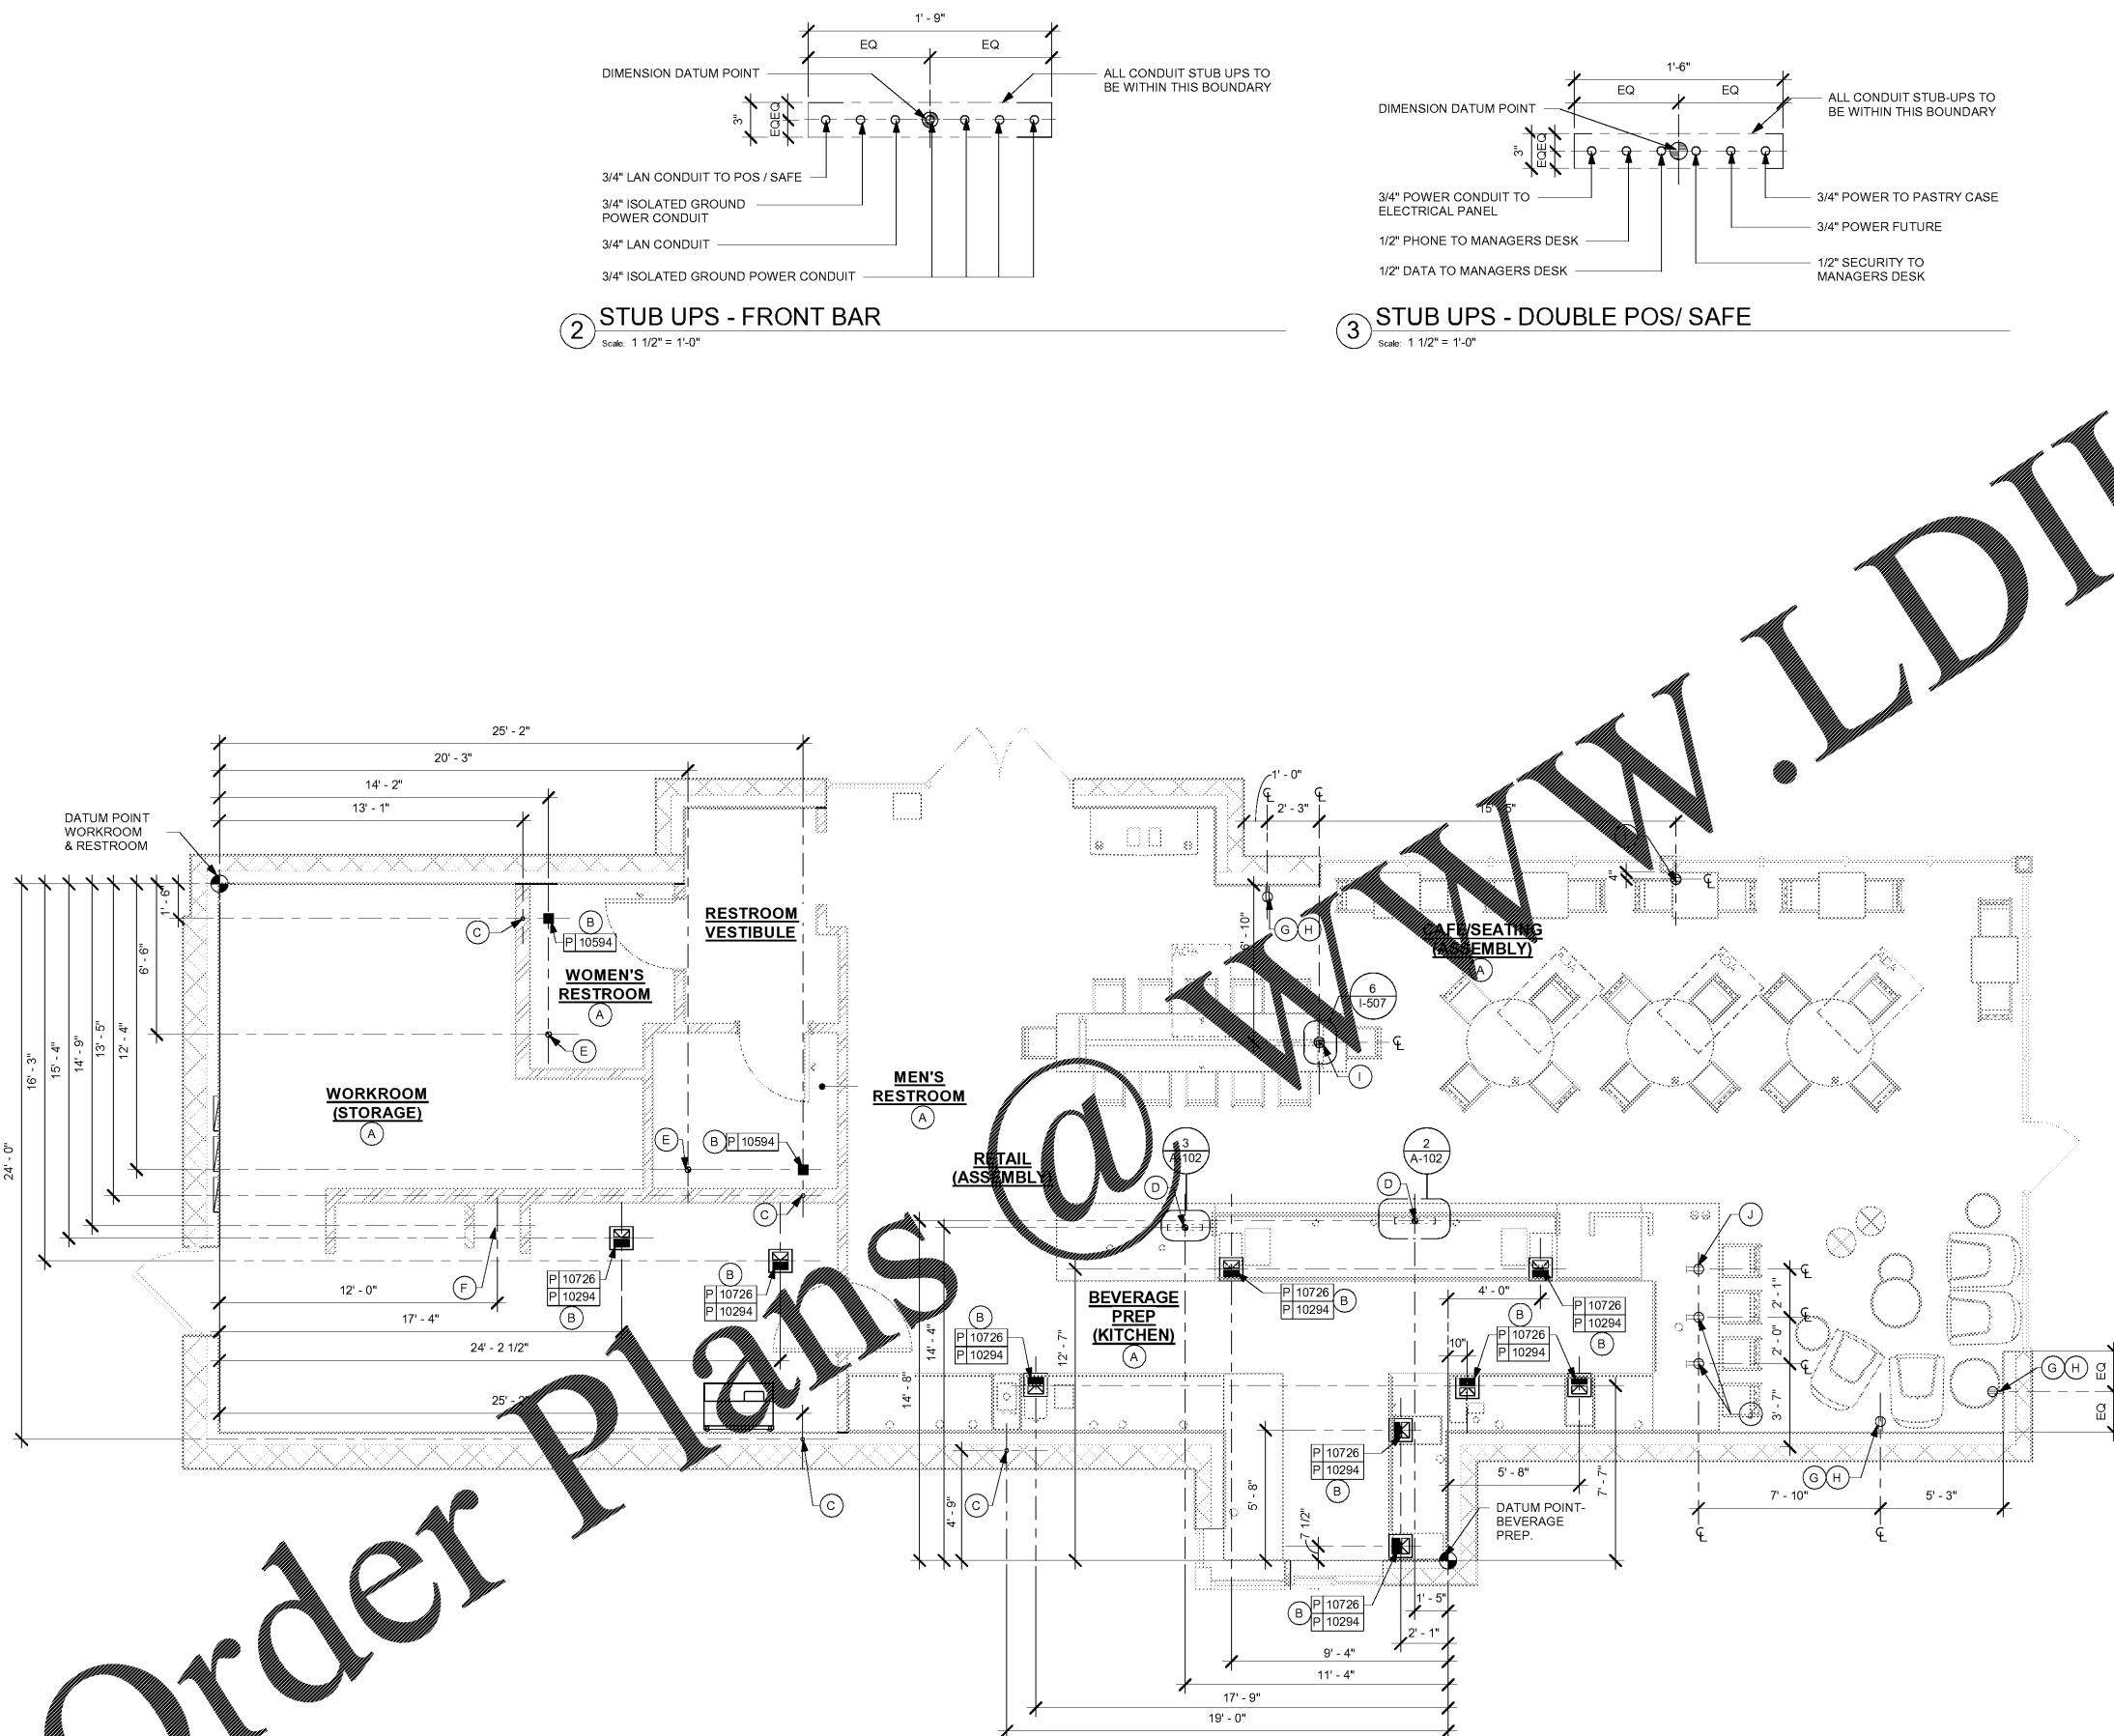

1 PENETRATION PLAN
Scale: 1/4" = 1'-0"

2 STUB UPS - FRONT BAR
Scale: 1 1/2" = 1'-0"

3 STUB UPS - DOUBLE POS/ SAFE
Scale: 1 1/2" = 1'-0"

PENETRATION PLAN NOTES

- A. ALL STUB-UP DIMENSIONS ARE RELATIVE TO FINISHED WALL LOCATIONS (SHOWN AS OUTLINES ON THIS PLAN). REFER TO FLOOR PLAN FOR WALL PLACEMENT.
- B. FLOOR DRAIN: REFER TO CUT SHEETS FOR COMPONENT SPEC AND CUTOUT REQUIREMENTS.
- C. WASTE LINE PENETRATIONS: REFER TO PLUMBING PLANS FOR INDIVIDUAL LINE SPEC. PENETRATION TO BE LOCATED ON CENTERLINE OF WALL OR AS REQ'D PER CONDITIONS.
- D. STUB-UP PENETRATIONS: REFER TO PLUMBING PLANS FOR INDIVIDUAL STUB-UP SPEC.
- E. TOILET FLOOR PENETRATION: REFER TO CUT SHEETS FOR STUB-UP LOCATION RELATIVE TO FINISHED WALL.
- F. FLOOR PENETRATIONS AT MOP SINK: REFER TO PLUMBING PLANS FOR INDIVIDUAL LINE SPECIFICATION.
- G. LOCATION OF DUPLEX OUTLET AT SERVICE BAR: COORDINATE LOCATIONS WITH STARBUCKS STORE REFERENCE TO ELECTRICAL SHEETS FOR MORE INFORMATION.
- H. ALL OUTLETS IN CAFE/RECIPE RECEPTABLES AND COFFEE PLATE TO MATCH JACOBI FINISH.
- I. NEW DUPLEX FOR OUTLET COORDINATE FLOOR RECEPTACLE LOCATION WITH TABLE LEG.
- J. LOCATION OF OUTLET AT SERVICE BAR @ 6IN BELOW FROM THE BOTTOM OF COUNTER. COORDINATE LOCATIONS WITH STARBUCKS STORE REFERENCE TO ELECTRICAL SHEETS FOR MORE INFORMATION.

PENETRATION SYMBOL LEGEND

- FLOOR SINK
- FLOOR PENETRATION
- ELECTRICAL PENETRATION AREA
- WALL OUTLET
- FLOOR OUTLET
- DRAIN FLOOR SINK (RESTROOMS)
- DATUM POINT

NOTE: SEE SHEET I-101.1 FOR PLUMBING FIXTURE SCHEDULE



STARBUCKS
2401 UTAH AVENUE SOUTH
SEATTLE, WASHINGTON 98134
(206) 318-1575

THESE DRAWINGS AND SPECIFICATIONS ARE CONFIDENTIAL AND SHALL REMAIN THE SOLE PROPERTY OF STARBUCKS CORPORATION, WHICH IS THE OWNER OF THE COPYRIGHT IN THIS WORK. THEY SHALL NOT BE REPRODUCED (IN WHOLE OR IN PART), SHARED WITH THIRD PARTIES OR USED IN ANY MANNER ON OTHER PROJECTS OR EXTENSIONS TO THIS PROJECT WITHOUT THE PRIOR WRITTEN CONSENT OF STARBUCKS CORPORATION. THESE DRAWINGS AND SPECIFICATIONS ARE INTENDED TO EXPRESS DESIGN INTENT FOR A PROTOTYPICAL STARBUCKS STORE (WHICH IS SUBJECT TO CHANGE AT ANYTIME) AND DO NOT REFLECT ACTUAL SITE CONDITIONS. NEITHER PARTY SHALL HAVE ANY OBLIGATION NOR LIABILITY TO THE OTHER (EXCEPT STATED ABOVE) UNTIL A WRITTEN AGREEMENT IS FULLY EXECUTED BY BOTH PARTIES.

STARBUCKS TEMPLATE VERSION I2018.01.26

Design Forum Architects Inc.
700 W. Pine Rose Way, Suite 400
Cincinnati, OH 45203
Tel: (513) 421-2210
Donald J. Rehrman
Architect in Charge
License: AR0017303

Design Forum Engineering
700 W. Pine Rose Way, Suite 400
Cincinnati, OH 45203
Tel: (513) 421-2210
Timothy L. Radermacher, P.E.
Professional Engineer
License: 62078

PROJECT NAME:
**CYPRESS GARDENS
BLVD & ROOSEVELT**

PROJECT ADDRESS:
**5709 CYPRESS GARDENS BLVD
WINTER HAVEN, FL 33884**

STORE #: 50175
PROJECT #: 73763-001
ISSUE DATE: 04/20/2018
DESIGN PROGRAM: LAIS BRITO
MANAGER:
LEEDO AP: STARBUCKS
PRODUCTION DESIGNER: MICHAEL B. SARKA
CHECKED BY: ANA COSTANZO

Revision Schedule			
Rev	Date	By	Description

SHEET TITLE:
PENETRATION PLAN

SCALE: AS SHOWN

SHEET NUMBER:
A-102

Order Plans

WWW.LDILLINE.COM

