

CEILING TREATMENT SCHEDULE - "U"					
DESIGN ID	AREA	DESCRIPTION	FURN. BY	INST. BY	COMMENTS
OTHER					
11302	354 SF	ACT - WHITE - 2X4FT 61X122CM	GC	GC	VINYL CLAD ACT AT BOH AREA

PAINT SCHEDULE					
COLOR CODE	DESCRIPTION	LRV	FURN. BY	INST. BY	COMMENTS
P534-ES	SW - BLACK FOX; NCS/AKZO NOBEL - FOREST BLACK - EGGSHELL	8	GC	GC	SW7020, USE PRIMER CP-1; NCS - S 7502-Y; AKZO NOBEL - 30YY 10/038
P534-SG	SW - BLACK FOX; NCS/AKZO NOBEL - FOREST BLACK - SEMIGLOSS	8	GC	GC	SW7020, USE PRIMER CP-1; NCS - S 7502-Y; AKZO NOBEL - 30YY 10/038
P552-ES	SW - MEGA GREIGE; NCS/AKZO NOBEL - HERON GREY	38			SW7031, USE PRIMER CP-1; NCS - S 3005-Y50R; AKZO NOBEL - 20YY 37/094
P554-ES	SW - INTELLECTUAL GRAY; NCS/AKZO NOBEL - DRY GOODS - EGGSHELL	36	GC	GC	SW7045, USE PRIMER CP-1; NCS - S 3005-Y20R; AKZO NOBEL - 40YY 44/095
P554-SG	SW - INTELLECTUAL GRAY; NCS/AKZO NOBEL - DRY GOODS - SEMIGLOSS	36	GC	GC	SW7045, USE PRIMER CP-1; NCS - S 3005-Y20R; AKZO NOBEL - 40YY 44/095

SHEET NOTES

- INSTALL 2 X 4' ACT CEILING AT WORKROOM AS INDICATED.
- INSTALL GYPSUM BOARD CEILING AS INDICATED.
- LINE OF SOFFIT HEADER.
- LOCATION OF ALL SWITCHING.
- REFER TO INTERIOR ELEVATIONS FOR MENU BOARD SPACING.
- GC TO COORDINATE SECURITY CAMERA QUANTITIES AND LOCATIONS WITH STARBUCKS CONSTRUCTION MANAGER.
- PAINT EXPOSED CEILING SURFACE AS INDICATED.
- PAINT RECESSED LIGHTING TRIM TO MATCH CEILING AS CLOSELY AS POSSIBLE.
- LOCATIONS OF ALL EGRESS LIGHTING FOR REFERENCE ONLY. GC TO VERIFY WITH LOCAL FIRE MARSHAL PRIOR TO INSTALLATION.
- INSTALL SURFACE MOUNTED SPEAKERS AT MAXIMUM ALLOWABLE HEIGHT.
- ILLUMINATED EXTERIOR WORDMARK BY SIGNAGE VENDOR. TO BE PERMITTED SEPARATELY. NOT INCLUDED IN BUILDING CONTRACT.
- ILLUMINATED EXTERIOR DRIVE-THRU SIGN BY SIGNAGE VENDOR. TO BE PERMITTED SEPARATELY. NOT INCLUDED IN BUILDING CONTRACT.
- SELF-ILLUMINATED EXTERIOR SIGNAGE BY SIGNAGE VENDOR. TO BE PERMITTED SEPARATELY. NOT INCLUDED IN BUILDING CONTRACT.
- REFER TO EXTERIOR ELEVATIONS FOR SIGNAGE MOUNTING HEIGHTS.
- INSTALL ROLLER SHADES AS INDICATED.
- REFER TO SHEET A-104 FOR LIGHTING LOCATIONS AND INFORMATION.
- EXISTING EXTERIOR WALL SCONCE.
- ALIGN FINISHED SURFACES.
- LINE OF PASTRY CASE BELOW.
- EXISTING CANOPY/AWNING.
- EXISTING EXTERIOR SECURITY LIGHTS.
- CONSTRUCT BULKHEAD AND GYPSUM BOARD SOFFIT AS INDICATED.

NOTE:
REFER TO SHEET I-101.1 FOR FURNITURE & DATA DEVICE SCHEDULES.

LIGHTING LEGEND


- △ TRACK HEAD: SPOT LIGHT
- △ TRACK HEAD: NARROW FLOOD LIGHT
- 4" RECESSED NARROW FLOOD LIGHT

REFLECTED CEILING PLAN NOTES


- A. IF REQUIRED BY LOCAL CODE, GENERAL CONTRACTOR TO PROVIDE SEMI-RECESSED SPRINKLER HEADS WITH POLISHED CHROME ESCUTCHEONS CENTERED IN ACOUSTICAL CEILING TILE. IF PENDANT HEADS ARE REQUIRED IN GYPSUM SOFFIT OVER FRONT BAR, CONCEAL SUPPLY PIPING WITHIN SOFFIT. GENERAL CONTRACTOR TO SUBMIT SPRINKLER LAYOUT TO STARBUCKS' CONSTRUCTION MANAGER FOR APPROVAL PRIOR TO INSTALLATION.
 - B. GENERAL CONTRACTOR TO PROVIDE AND LOCATE SPRINKLERS PER LOCAL CODES. CONTACT STARBUCKS' CONSTRUCTION MANAGER IF DESIGN INTENT IS AFFECTED.
 - C. WHERE ACOUSTICAL CEILING MEETS WALL, PROVIDE WALL MOLDING FOR REVEAL. MATCH CEILING GRID COLOR WHEN APPLICABLE.
 - D. LEAVE (10) ADDITIONAL RETAIL CEILING TILES TO MATCH RETAIL CEILING PAINT COLOR ABOVE THE WORKROOM CEILING AT MANAGER'S DESK FOR FUTURE USE.
 - E. PROVIDE GROMMET AT ALL CEILING PENETRATIONS FOR FIXTURES OR SUPPORTS.
 - F. HEATING, VENTILATING, AND AIR CONDITIONING (HVAC) SHOWN FOR REFERENCE ONLY. CONTACT PROJECT MANAGER IF CHANGED.
 - G. DIFFUSE GRAND RETURNS A BACKBAR IN ACOUSTICAL CEILING TILES TO BE COVERED IN TILE, PAINTED TO MATCH ADJACENT FINISHES, TYPICAL.
 - H. PAINT ALL HVAC DUCTS, HVAC DIFFUSERS, RECESSED SPEAKERS AND LIGHT TRIM RINGS THE SAME COLOR AS CEILING OR SOFFIT, TYPICAL THROUGHOUT RETAIL PORTION OF STORE.
- PAINT SUBSTITUTIONS ARE NOT ALLOWED. USE STARBUCKS' NATIONAL ACCOUNT "COLOR CODE" WHEN ORDERING PAINTS. SEE SCHEDULE SHEETS FOR SCHEDULES.
- J. SEE LIGHTING DESIGN PLAN FOR FIXTURE TYPES AND LOCATION DIMENSIONS.
 - K. ADJUST EACH TRACK HEAD AT MENU BOARD LIGHTING SO LIGHT BEAMS ARE POINTING CONSISTENTLY, JUST BELOW THE CENTER OF EACH MENU BOARD PANEL.

RESPONSIBILITY LEGEND

- GC - GENERAL CONTRACTOR
 - SB - STARBUCKS
 - EXIST - EXISTING
 - VD - VENDOR
- NOTE:** ALL RESPONSIBILITIES TO BE CONFIRMED WITH STARBUCKS DESIGN MANAGER PRIOR TO ORDERING/CONSTRUCTION

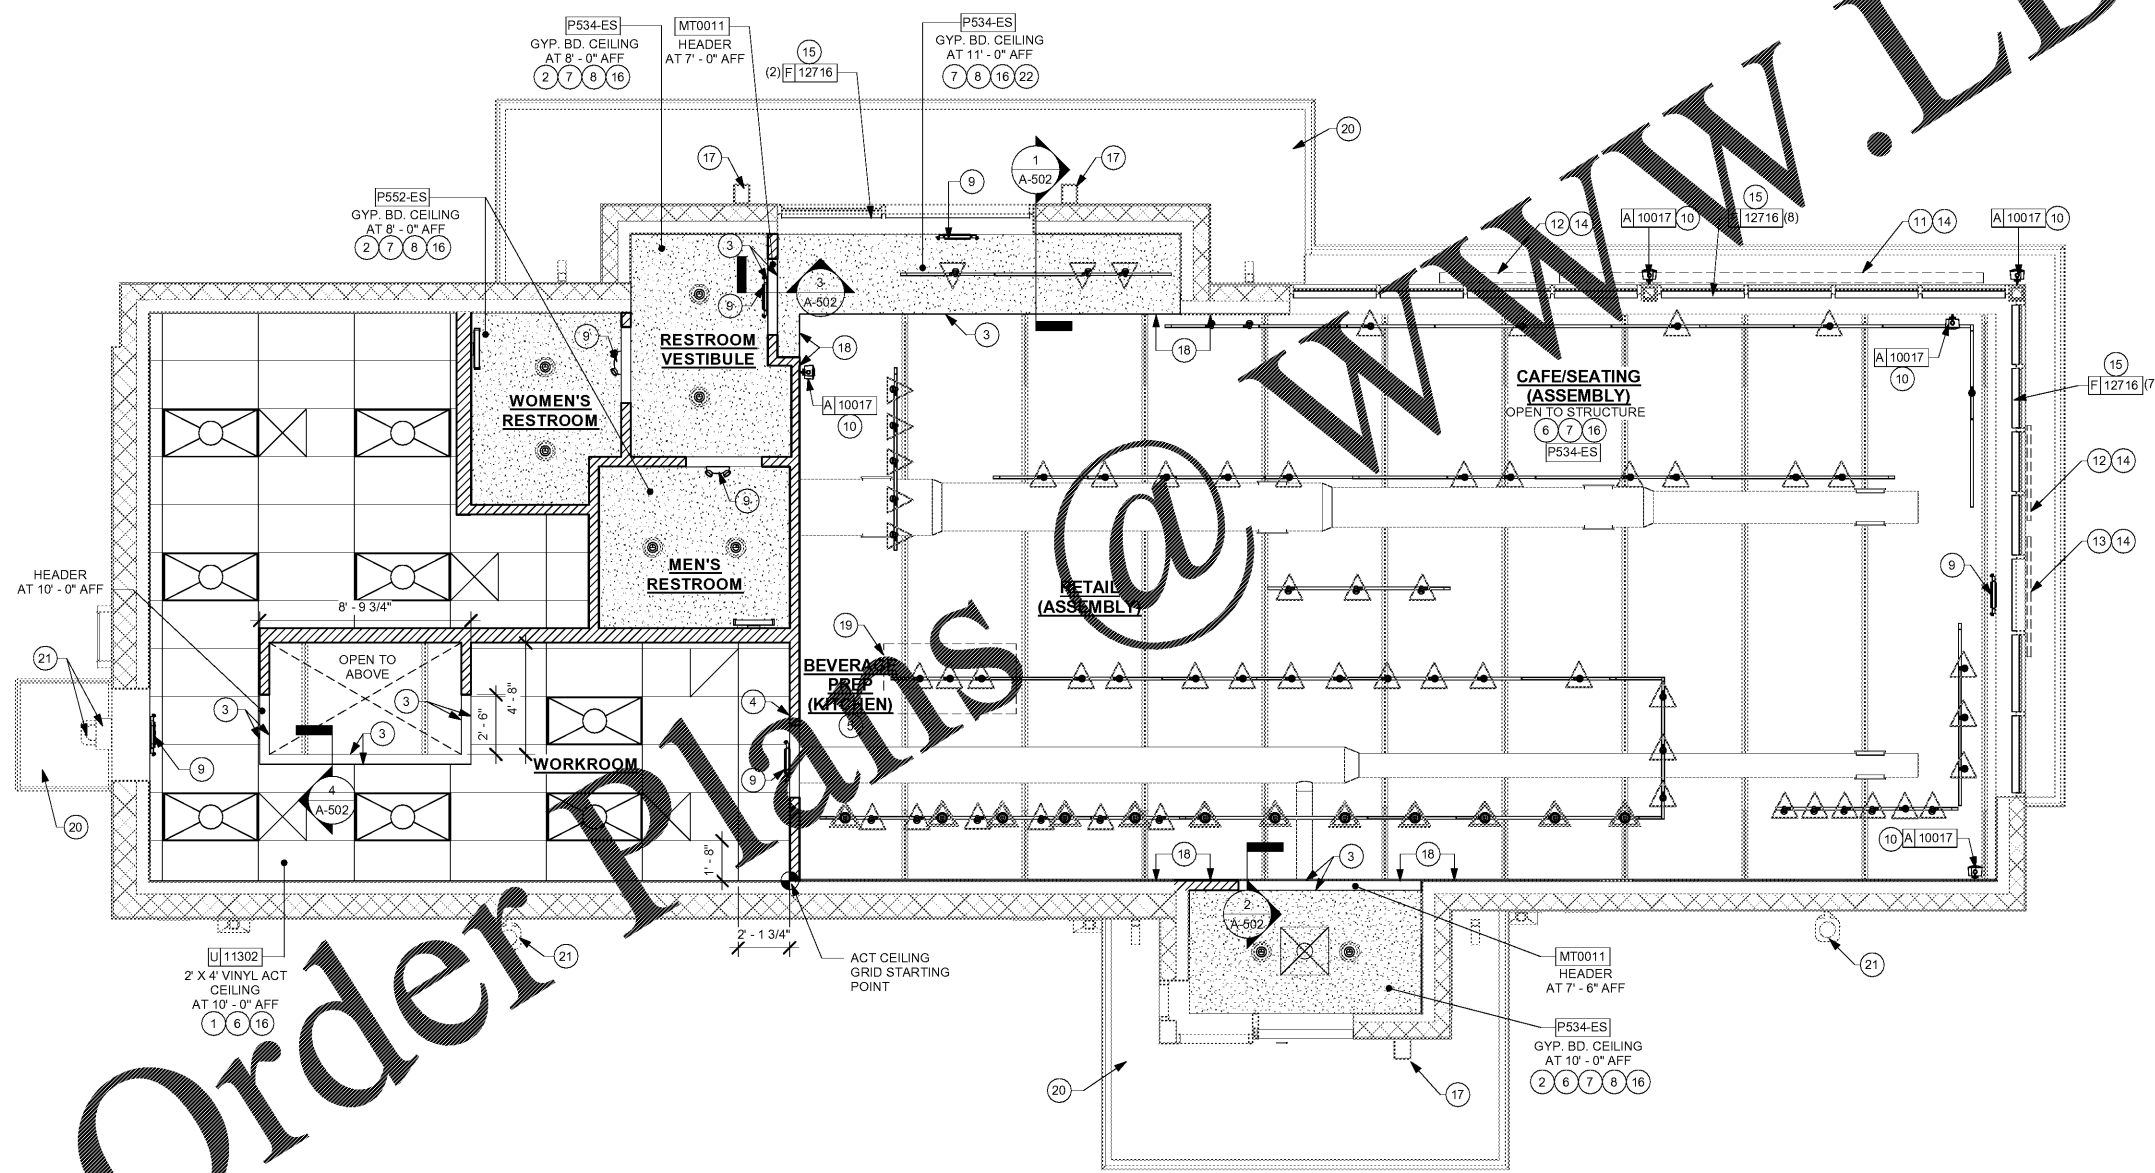

 1 REFLECTED CEILING PLAN
Scale: 1/4" = 1'-0"



STARBUCKS
2401 UTAH AVENUE SOUTH
SEATTLE, WASHINGTON 98134
(206) 318-1575

THESE DRAWINGS AND SPECIFICATIONS ARE CONFIDENTIAL AND SHALL REMAIN THE SOLE PROPERTY OF STARBUCKS CORPORATION, WHICH IS THE OWNER OF THE COPYRIGHT IN THIS WORK. THEY SHALL NOT BE REPRODUCED (IN WHOLE OR IN PART), SHARED WITH THIRD PARTIES OR USED IN ANY MANNER ON OTHER PROJECTS OR EXTENSIONS TO THIS PROJECT WITHOUT THE PRIOR WRITTEN CONSENT OF STARBUCKS CORPORATION. THESE DRAWINGS AND SPECIFICATIONS ARE INTENDED TO EXPRESS DESIGN INTENT FOR A PROTOTYPICAL STARBUCKS STORE (WHICH IS SUBJECT TO CHANGE AT ANYTIME) AND DO NOT REFLECT ACTUAL SITE CONDITIONS. NEITHER PARTY SHALL HAVE ANY OBLIGATION NOR LIABILITY TO THE OTHER (EXCEPT STATED ABOVE) UNTIL A WRITTEN AGREEMENT IS FULLY EXECUTED BY BOTH PARTIES.

STARBUCKS TEMPLATE VERSION I2018.01.26

Design Forum Architects Inc.
700 W. Pine Rose Way, Suite 460
Cincinnati, OH 45203
Tel: (513) 421-2210
Donald J. Rehrman
Architect in Charge
License: AR0017303

Design Forum Engineering
700 W. Pine Rose Way, Suite 460
Cincinnati, OH 45203
Tel: (513) 421-2210
Timothy L. Raderinger, PE
Professional Engineer
License: 62078

PROJECT NAME:
**CYPRESS GARDENS
CYPRESS GARDENS BLVD
& ROOSEVELT**

PROJECT ADDRESS:
**5709 CYPRESS GARDENS BLVD
WINTER HAVEN, FL 33884**

STORE #: 50175
PROJECT #: 73763-001
ISSUE DATE: 04/20/2018
DESIGN PROGRAM LAIS BRITO
MANAGER:
LEEDO AP: STARBUCKS
PRODUCTION DESIGNER: MICHAEL B. SARKA
CHECKED BY: ANA COSTANZO

Revision Schedule			
Rev	Date	By	Description

SHEET TITLE:
REFLECTED CEILING PLAN
SCALE: 1/4" = 1'-0"

SHEET NUMBER:
A-103