

LIGHTING FIXTURE SCHEDULE - "L"						
DESIGN ID	COUNT	DESCRIPTION	FURN. BY	INST. BY	BULB	COMMENTS
<b>EXIT</b>						
11419	2	EMERGENCY LIGHT DOUBLE - BLACK	SB	GC		CED
11517	5	EMERGENCY EXIT LIGHT - BLACK	SB	GC	LED 5W LOW ENERGY OR EQUAL	
<b>RECESSED CAN</b>						
15077	8	CAN - RECESSED HOUSING FOR LED TRIM - 4IN 100MM - NEW CEILING	SB	GC		
15081	8	CAN - RECESSED TRIM ADJUSTABLE WITH LED ENGINE - 4IN 100MM - BLACK - 600LM NFL	SB	GC	INTEGRATED LED	
<b>SCONCE</b>						
16593	2	SCONCE - LED RESTROOM VANITY TUBULAR - OPAL GLASS AND BRUSHED NICKEL	SB	GC	INTEGRATED LED	
<b>TRACK</b>						
12946	1	TRACK - WITH CONNECTORS - 4FT 122CM - BLACK	SB	GC		ALL BAR / CAFE TRACK LIGHTING TO BE RUN THROUGH 1A / 2A CURRENT LIMITING DEVICE #RCLF12BL-TCL2BL; SEE ELECTRICAL DRAWINGS FOR ADDITIONAL INFORMATION
12947	7	TRACK - WITH CONNECTORS - 8FT 244CM - BLACK	SB	GC		ALL BAR / CAFE TRACK LIGHTING TO BE RUN THROUGH 1A / 2A CURRENT LIMITING DEVICE #RCLF12BL-TCL2BL; SEE ELECTRICAL DRAWINGS FOR ADDITIONAL INFORMATION
12948	7	TRACK - WITH CONNECTORS - 16FT 488CM - BLACK	SB	GC		ALL BAR / CAFE TRACK LIGHTING TO BE RUN THROUGH 1A / 2A CURRENT LIMITING DEVICE #RCLF12BL-TCL2BL; SEE ELECTRICAL DRAWINGS FOR ADDITIONAL INFORMATION
12949	2	TRACK - WITH CONNECTORS - 12FT 365CM - BLACK	SB	GC		ALL BAR / CAFE TRACK LIGHTING TO BE RUN THROUGH 1A / 2A CURRENT LIMITING DEVICE #RCLF12BL-TCL2BL; SEE ELECTRICAL DRAWINGS FOR ADDITIONAL INFORMATION
12955	60	TRACK - FIXTURE OPEN FLARED - 3.5IN 90MM - BLACK	SB	GC	(1) 14516 - LED PAR 20 500LM SPOT BLACK, OR EQUAL	
12958	12	TRACK - FIXTURE OPEN FLARED - 5IN 125MM - BLACK	SB	GC	(1) 14673 - LED PAR 30 850LM NFL BLACK, OR EQUAL	
15058	1	TRACK - WITH CONNECTORS - 6FT 183CM - BLACK	SB	GC		ALL BAR / CAFE TRACK LIGHTING TO BE RUN THROUGH 1A / 2A CURRENT LIMITING DEVICE #RCLF12BL-TCL2BL; SEE ELECTRICAL DRAWINGS FOR ADDITIONAL INFORMATION
17472	2	TRACK - WITH CONNECTORS - VARIABLE LENGTH - BLACK	SB	GC		ALL BAR / CAFE TRACK LIGHTING TO BE RUN THROUGH 1A / 2A CURRENT LIMITING DEVICE #RCLF12BL-TCL2BL; SEE ELECTRICAL DRAWINGS FOR ADDITIONAL INFORMATION
<b>TROFFER</b>						
15057	8	TROFFER - LED RECESSED - 24X48IN 600X1200MM - WHITE - 3900LM	SB	GC	INTEGRATED LED	CED

BULB SCHEDULE - "L"						
DESIGN ID	COUNT	DESCRIPTION	FURN. BY	INST. BY	COMMENTS	
<b>LAMP</b>						
14516	60	LED PAR 20 500LM 2700K SPOT - BLACK	SB	GC		
14673	12	LED PAR 30 850LM 2700K NFL - BLACK	SB	GC		

### BUILDING ROOF PLAN NOTES

- WHERE ACOUSTICAL CEILING MEETS WALL, PROVIDE ANGLE WALL MOULDING FOR REVEAL. MATCH CEILING GRID COLOR WHEN APPLICABLE.
- PAINT SUBSTITUTIONS ARE NOT ALLOWED. USE STARBUCKS' NATIONAL ACCOUNT "COLOR CODE" WHEN ORDERING PAINTS. SEE SHEET A-602 FOR PAINT SCHEDULES.
- ALL FIXTURES IN FOOD PREPARATION AREA SHALL HAVE SHATTERPROOF LAMPS IF THE FIXTURE IS NOT LENSED.
- PROVIDE GROMMET AT ALL CEILING PENETRATIONS FOR FIXTURES/SUPPORTS.
- ADJUST FOCUS OF ALL TRACK AND RECESSED DIRECTIONAL LIGHTING TO FULLY ILLUMINATE ALL ARTWORK, MENU BOARDS, AND MERCHANDISE BAYS.
- IF PENDANT SUSPENDED LENGTH EXCEEDS 48" (1220MM) FROM CEILING, REPLACE WITH SURFACE-MOUNTED PENDANT AND SUSPEND WITH GC-SUPPLIED CONDUIT AND BOX TO DIMENSIONED HEIGHT.
- ENTER EMERGENCY EXIT LIGHTS ABOVE DOORS, UON.

### SHEET NOTES

- INSTALL RECESSED CAN LIGHTS AS INDICATED.
- INSTALL SUSPENDED TRACK LIGHTING AS INDICATED. REFER TO INTERIOR ELEVATION FOR MOUNTING HEIGHT. INSTALL RECESSED TROFFER LIGHTS AS INDICATED.
- MOUNT RESTROOM WALL SCONCE WITH CENTER OF J-BOX AT 6" - 8" AFF AS INDICATED ON RR ELEVATIONS.
- LOCATIONS OF ALL EGRESS LIGHTING FOR REFERENCE ONLY. GC TO VERIFY WITH LOCAL FIRE MARSHALL PRIOR TO INSTALLATION.
- EXISTING EXTERIOR WALL SCONCE.
- EXISTING SECURITY LIGHT.


### LIGHTING LEGEND

- △ TRACK HEAD: SPOT LIGHT
- △ TRACK HEAD: NARROW FLOOD LIGHT
- 5" RECESSED NARROW FLOOD LIGHT


### RESPONSIBILITY LEGEND

- GC - GENERAL CONTRACTOR
- SB - STARBUCKS
- EXIST - EXISTING
- VD - VENDOR

**NOTE:** ALL RESPONSIBILITIES TO BE CONFIRMED WITH STARBUCKS DESIGN MANAGER PRIOR TO ORDERING/CONSTRUCTION

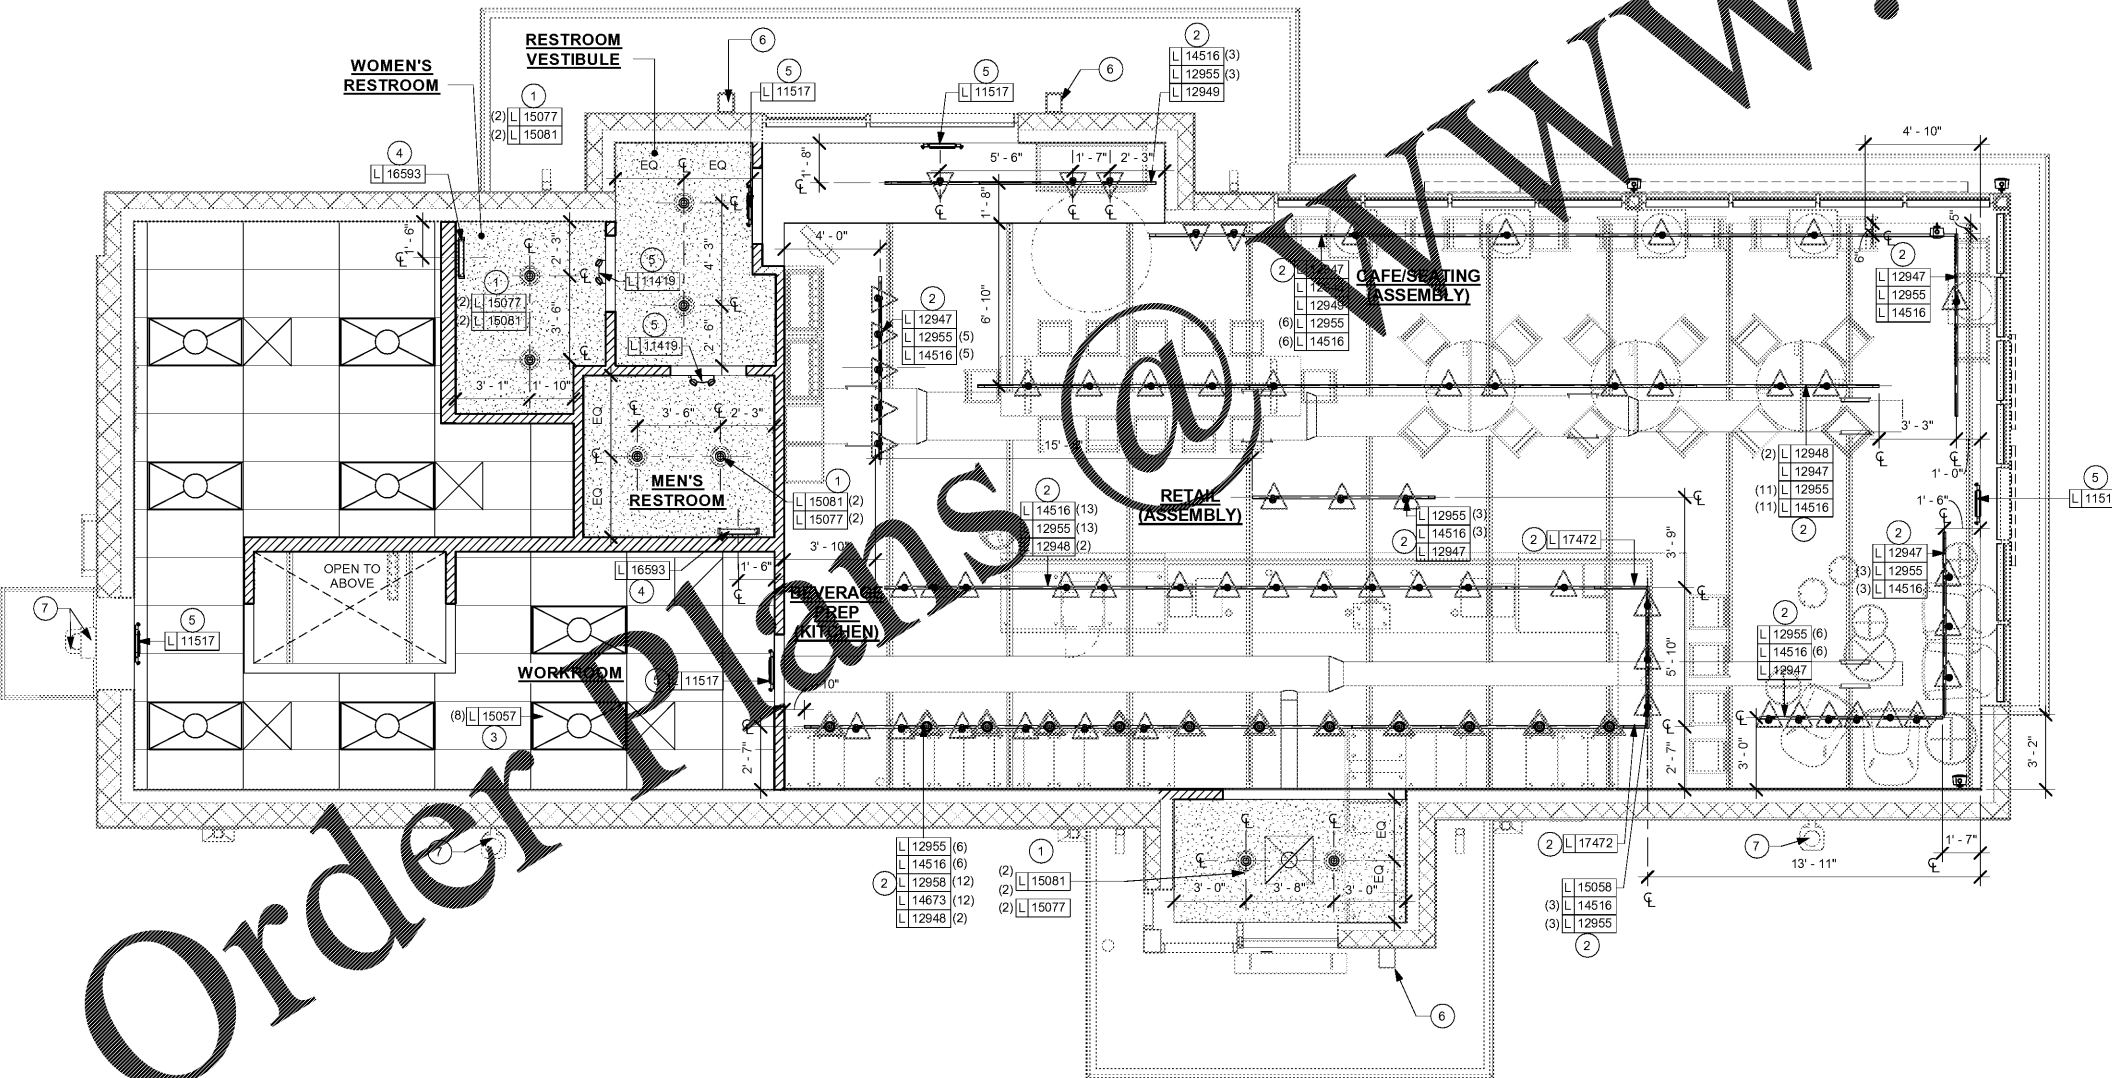

 1 DIMENSIONED CEILING & LIGHTING PLAN  
Scale: 1/4" = 1'-0"



**STARBUCKS**  
2401 UTAH AVENUE SOUTH  
SEATTLE, WASHINGTON 98134  
(206) 318-1575

THESE DRAWINGS AND SPECIFICATIONS ARE CONFIDENTIAL AND SHALL REMAIN THE SOLE PROPERTY OF STARBUCKS CORPORATION, WHICH IS THE OWNER OF THE COPYRIGHT IN THIS WORK. THEY SHALL NOT BE REPRODUCED (IN WHOLE OR IN PART), SHARED WITH THIRD PARTIES OR USED IN ANY MANNER ON OTHER PROJECTS OR EXTENSIONS TO THIS PROJECT WITHOUT THE PRIOR WRITTEN CONSENT OF STARBUCKS CORPORATION. THESE DRAWINGS AND SPECIFICATIONS ARE INTENDED TO EXPRESS DESIGN INTENT FOR A PROTOTYPICAL STARBUCKS STORE (WHICH IS SUBJECT TO CHANGE AT ANYTIME) AND DO NOT REFLECT ACTUAL SITE CONDITIONS. NEITHER PARTY SHALL HAVE ANY OBLIGATION NOR LIABILITY TO THE OTHER (EXCEPT STATED ABOVE) UNTIL A WRITTEN AGREEMENT IS FULLY EXECUTED BY BOTH PARTIES.

STARBUCKS TEMPLATE VERSION |2018.01.26

**Design Forum Architects Inc.**  
700 W. Pine Rose Way, Suite 460  
Cincinnati, OH 45203  
Tel: (513) 421-2210  
Donald J. Rehrman  
Architect In Charge  
License: AR0017303

**Design Forum Engineering**  
700 W. Pine Rose Way, Suite 460  
Cincinnati, OH 45203  
Tel: (513) 421-2210  
Timothy L. Rastetter, PE  
Professional Engineer  
License: 62078

**PROJECT NAME:**  
CYPRESS GARDENS  
BLVD & ROOSEVELT

**PROJECT ADDRESS:**  
5709 CYPRESS GARDENS BLVD  
WINTER HAVEN, FL 33884

**STORE #:** 50175  
**PROJECT #:** 73763-001  
**ISSUE DATE:** 04/20/2018  
**DESIGN PROGRAM MANAGER:** LAIS BRITO  
**LEEDO AP:** STARBUCKS  
**PRODUCTION DESIGNER:** MICHAEL B. SARKA  
**CHECKED BY:** ANA COSTANZO

Revision Schedule			
Rev	Date	By	Description

**SHEET TITLE:**  
DIMENSIONED CEILING  
AND LIGHTING PLAN  
SCALE: 1/4" = 1'-0"

**SHEET NUMBER:**  
A-104

C:\Users\daniel.green\Documents\Starbucks\_Cypress Gardens & Roosevelt\_FL\_2017\_daniel.green@interbrand.com.rvt 5/2/2018 12:04:26 PM

Order Plans @ www.ldilme.com