

C:\Users\daniel.green\Documents\Starbucks\_Cypress Gardens & Roosevelt\_FL\_2017\_daniel.green@interbrand.com.rvt 5/2/2018 12:07:19 PM


**FURNITURE, FIXTURE AND EQUIPMENT PLAN NOTES**

- A. GENERAL CONTRACTOR TO SCHEDULE WITH LOCAL REFRIGERATION CONTRACTOR TO CONDUCT INITIAL FOOD CASE START-UP AND TESTING. FOR LIST OF APPROVED START UP CONTRACTORS, CONTACT PROJECT CONSTRUCTION REPRESENTATIVE.
- B. THE SITE IS SERVED BY THE MUNICIPAL WATER AND SEWER SYSTEM UNLESS OTHERWISE NOTED.
- C. ALL EQUIPMENT AND INSTALLATION WILL MEET NATIONAL SANITATION FOUNDATION STANDARDS OR EQUIVALENT.
- D. EQUIPMENT UNITS SHALL CONTAIN NO EXPOSED THREADS, EMBELLISHMENTS OR OVERHANGING EDGES THAT SERVE AS PLACES FOR ACCUMULATION OF DUST, DIRT AND DEBRIS.
- E. WARMING OVEN(S) SHOWN FOR PERMITTING PURPOSES. INSTALLATION AT STORE OPENING TO BE VERIFIED BY STARBUCKS CONSTRUCTION REPRESENTATIVE.
- F. EACH HAND WASHING SINK SHALL HAVE A SINGLE SERVICE TOWEL AND SOAP DISPENSER AND ALL HAND SINKS TO HAVE A COMBINATION HOT/COLD/HEATING FAUCET.
- G. FOR PLUMBING FIXTURES REFER TO THE PLUMBING DESIGN PLAN. FOR DATA DEVICES SCHEDULE, REFER TO THE ELECTRICAL DESIGN PLAN.
- H. CONFIRM ALL NECESSARY CLEARANCES PER PRODUCT CUT SHEET REQUIREMENTS FOR ALL EQUIPMENT (E.G. ICE MACHINE).
- I. FOR LOCATION OF COUNTERTOP EQUIPMENT, REFER TO COUNTERWORK ELECTRICAL DETAILS.

**SHEET NOTES**


- 1. GENERAL CONTRACTOR TO REVERSE DOOR HINGE ON UNDER COUNTER REFRIGERATOR TO LEFT-HAND SWING, AS SHOWN.
- 2. SECURE LOCKERS TO WALL PER MFGS. RECOMMENDATIONS.
- 3. PLACE FIRE EXTINGUISHER IN WORKROOM PER FIRE INSPECTOR.
- 4. LOCATION OF ALL SWITCHING.
- 5. SEE ELEVATIONS FOR DISTRIBUTION OF CUP DISPENSERS.
- 6. REFER TO ENLARGED RESTROOM PLAN & ELEVATIONS FOR RESTROOM FIXTURE LOCATIONS & MOUNTING HEIGHTS.
- 7. VENDOR TO INSTALL WATER FILTRATION SYSTEM PER MANUFACTURER'S INSTRUCTIONS. GC TO PROVIDE PLUMBING AND ELECTRICAL REQUIREMENTS.
- 8. ELECTRICAL PANELS. REFER TO ELECTRICAL DRAWINGS FOR MORE INFORMATION.
- 9. STARBUCKS TO COORDINATE NEWSPAPER FIXTURE ORDERING. CONTACT TRIAD MANUFACTURING BY EMAIL (starbucks@triadmf.com) OR BY PHONE (314-381-5280 X1111) TO ARRANGE SHIPMENT OF THE FIXTURE. ALLOW (5) DAY LEAD-TIME.
- 10. INSTALL MERCHANDISE BASKETS, PROMOTIONAL BANNER AND CUBES AS INDICATED.
- 11. DO NOT CAULK TRASH RINGS TO COUNTERTOPS.
- 12. INSTALL CORNER GUARDS IN BOH AREA AS INDICATED. SEE INTERIOR ELEVATIONS FOR CLARIFICATION.
- 13. INSTALL NEW MERCH BAYS AS INDICATED. SECURE TO WALL.
- 14. MOBILE ORDER AND PAY STATION. GC TO PROVIDE ELECTRICAL AS REQUIRED FOR INSTALLATION OF PRINTER. SEE ELECTRICAL DRAWINGS FOR MORE INFORMATION.
- 15. EXISTING EXTERIOR PATIO RAILING.
- 16. REFER TO APX-105 FOR ENLARGED PATIO PLAN.
- 17. INSTALL NITRO EQUIPMENT AS INDICATED.
- 18. EXISTING EXTERIOR BIKE RACK TO REMAIN. REFER TO SHEET APX-104 FOR DETAIL.
- 19. EXISTING CUSTOM OUTDOOR BENCH TO REMAIN.
- 20. INDICATES FUTURE MASTRENA.

**NOTE:** REFER SHEET I-101.1 FOR DATA DEVICE, FURNITURE, GRAPHICS, PLUMBING FIXTURE, SPECIALITY EQUIPMENT AND SITE SCHEDULE.

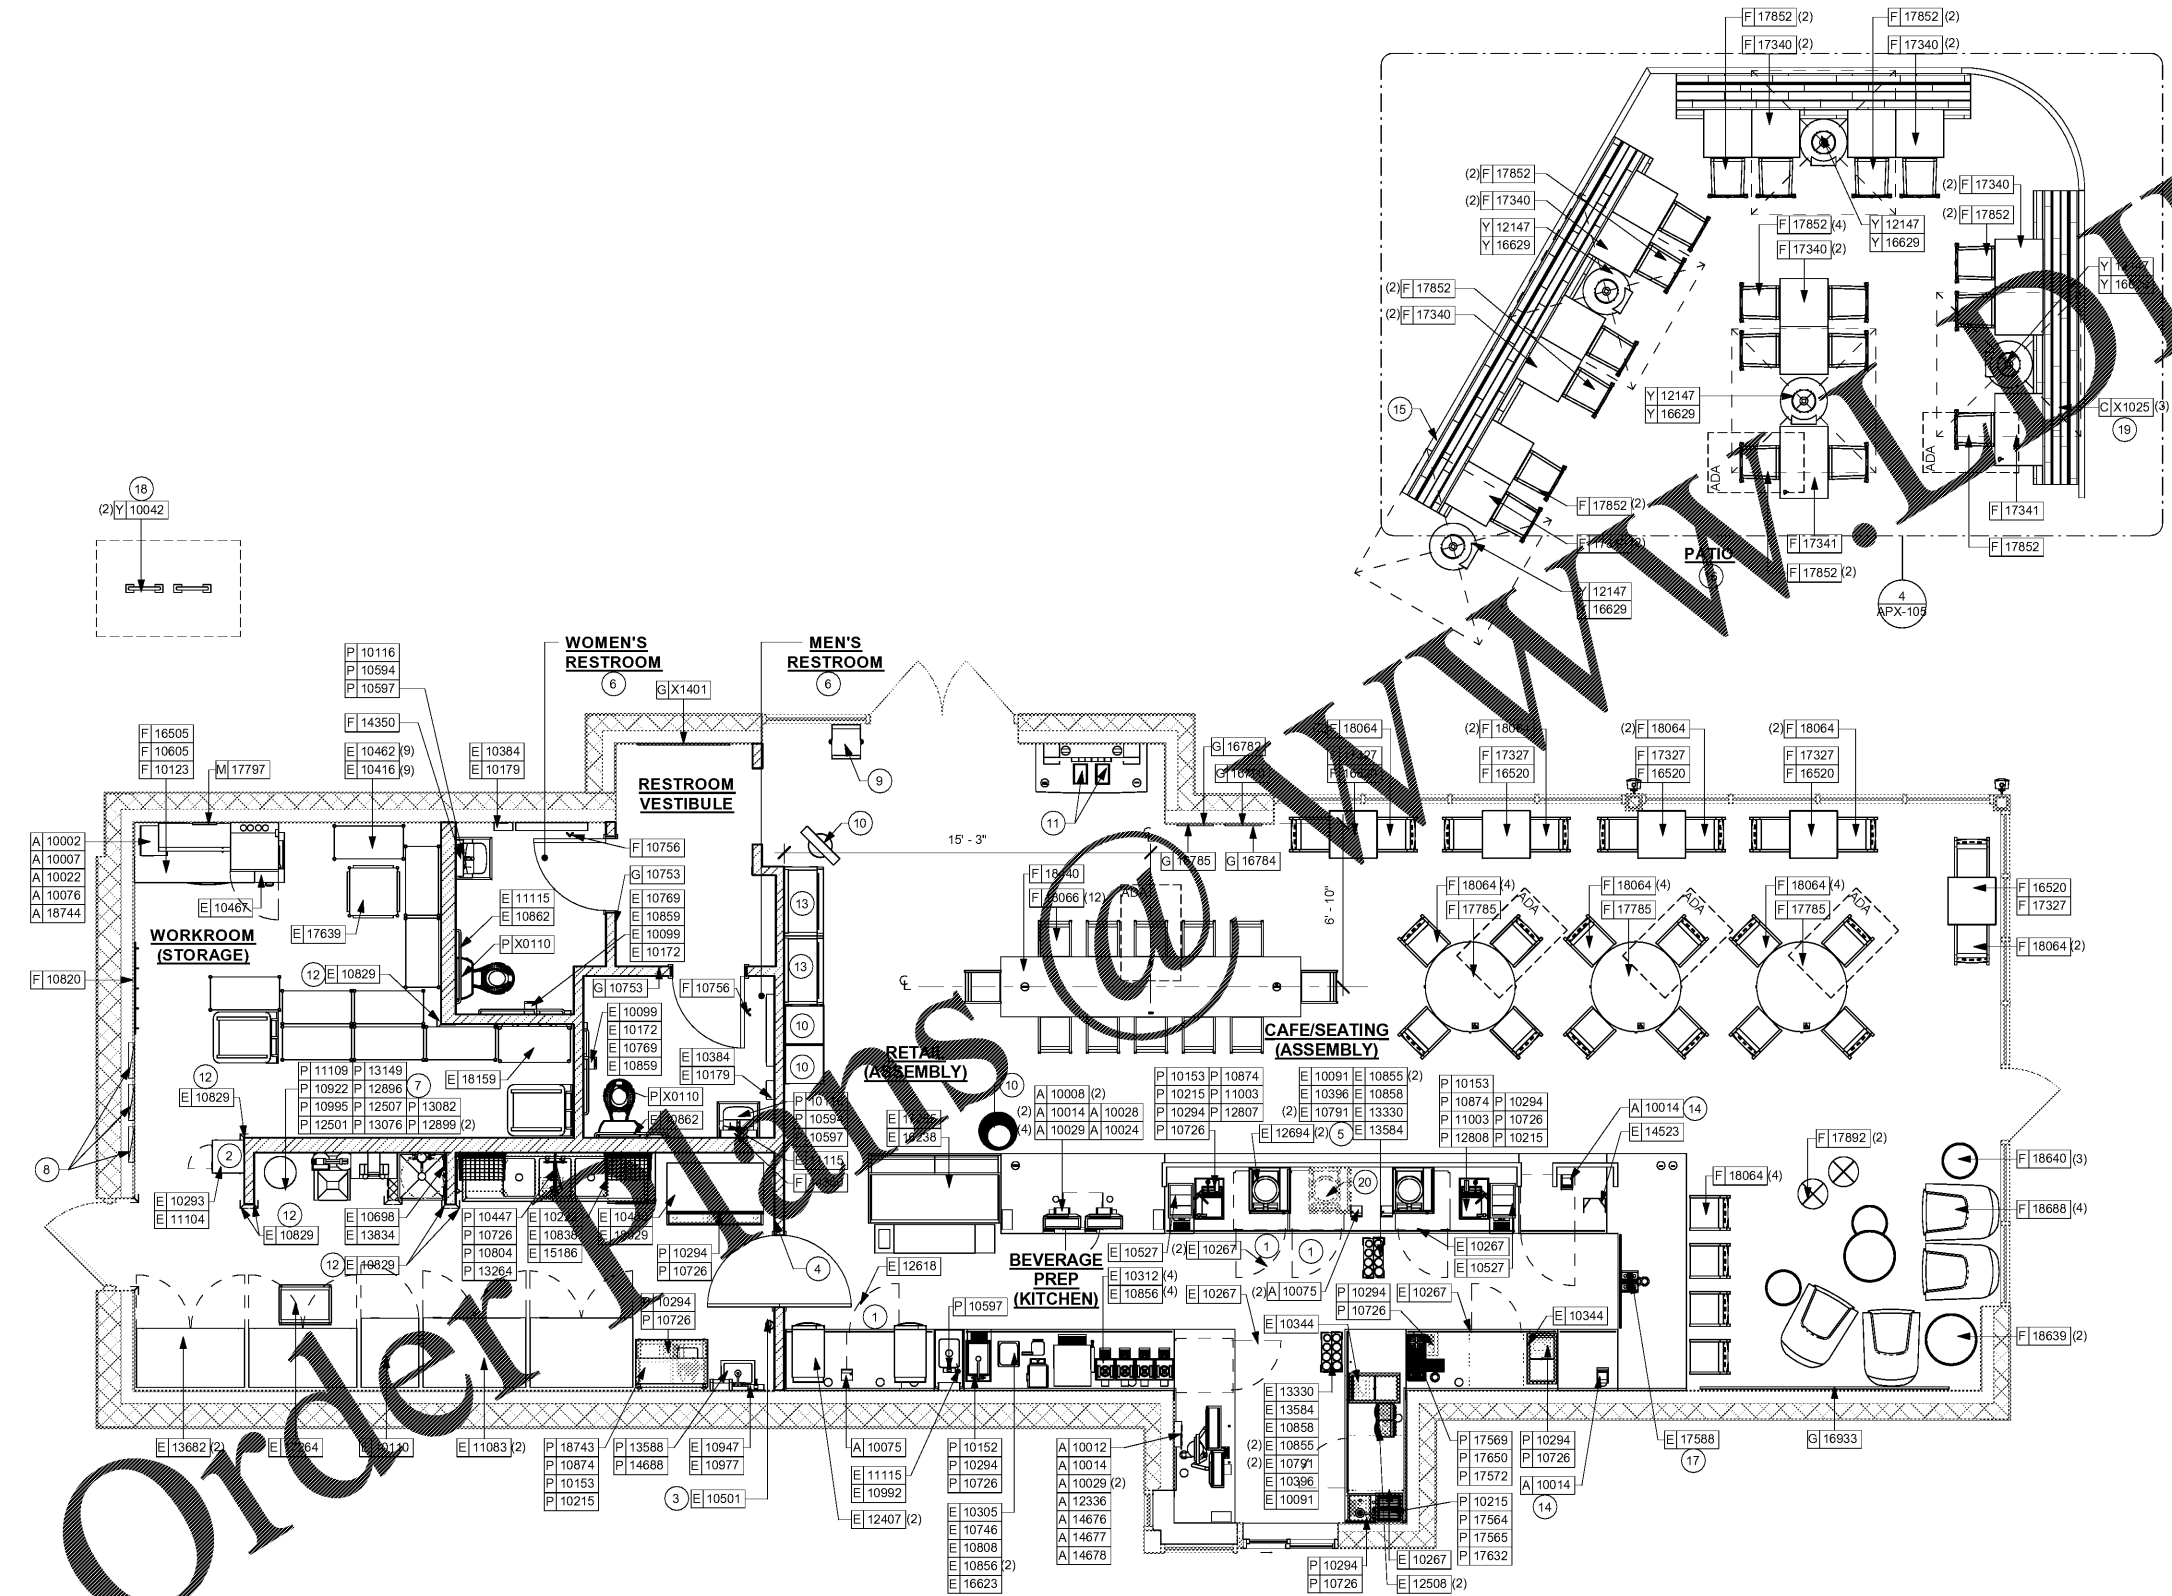

**1 FURNITURE, FIXTURES AND EQUIPMENT PLAN**

 Scale: 1/4" = 1'-0"



**STARBUCKS**  
2401 UTAH AVENUE SOUTH  
SEATTLE, WASHINGTON 98134  
(206) 318-1575

THESE DRAWINGS AND SPECIFICATIONS ARE CONFIDENTIAL AND SHALL REMAIN THE SOLE PROPERTY OF STARBUCKS CORPORATION, WHICH IS THE OWNER OF THE COPYRIGHT IN THIS WORK. THEY SHALL NOT BE REPRODUCED (IN WHOLE OR IN PART), SHARED WITH THIRD PARTIES OR USED IN ANY MANNER ON OTHER PROJECTS OR EXTENSIONS TO THIS PROJECT WITHOUT THE PRIOR WRITTEN CONSENT OF STARBUCKS CORPORATION. THESE DRAWINGS AND SPECIFICATIONS ARE INTENDED TO EXPRESS DESIGN INTENT FOR A PROTOTYPICAL STARBUCKS STORE (WHICH IS SUBJECT TO CHANGE AT ANYTIME) AND DO NOT REFLECT ACTUAL SITE CONDITIONS. NEITHER PARTY SHALL HAVE ANY OBLIGATION NOR LIABILITY TO THE OTHER (EXCEPT STATED ABOVE) UNTIL A WRITTEN AGREEMENT IS FULLY EXECUTED BY BOTH PARTIES.

STARBUCKS TEMPLATE VERSION I2018.01.26

**Design Forum Architects Inc.**  
700 W. Pale Rose Way, Suite 400  
Cincinnati, OH 45203  
Tel: (513) 421-2210  
Donald J. Reithman  
Architect in Charge  
License: AR0017303

**Design Forum Engineering**  
700 W. Pale Rose Way, Suite 400  
Cincinnati, OH 45203  
Tel: (513) 421-2210  
Timothy L. Radermacher PE  
Professional Engineer  
License: 62078

**PROJECT NAME:**  
CYPRESS GARDENS  
BLVD & ROOSEVELT

**PROJECT ADDRESS:**  
5709 CYPRESS GARDENS BLVD  
WINTER HAVEN, FL 33884

**STORE #:** 50175  
**PROJECT #:** 73763-001  
**ISSUE DATE:** 04/20/2018  
**DESIGN PROGRAM:** LAIS BRITO  
**MANAGER:**  
LEEDO AP: STARBUCKS  
**PRODUCTION DESIGNER:** MICHAEL B. SARKA  
**CHECKED BY:** ANA COSTANZO

Revision Schedule			
Rev	Date	By	Description

**SHEET TITLE:**  
FF AND E PLAN

**SCALE:** 1/4" = 1'-0"

**SHEET NUMBER:**  
I-101