


# PLAZA CONSTRUCTION PLANS FOR POWER DESIGN, INC. FOR PDI CAMPUS

1000 118TH AVENUE NORTH  
ST PETERSBURG, FLORIDA 33716  
SECTION 13, TOWNSHIP 30S, RANGE 16E

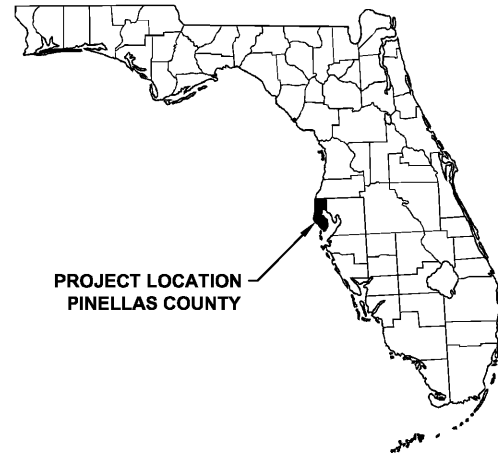

PROJECT LOCATION  
PINELLAS COUNTY

### PROJECT TEAM

**OWNER/DEVELOPER**  
POWER DESIGN, INC.  
11600 DR. ML KING JR. ST. N.  
ST. PETERSBURG, FL 33716  
TEL: (727) 210-0492  
FAX: (727) 210-0503  
CONTACT: FRANK MUSOLINO

**ENGINEER**  
FRONTIER ENGINEERING, INC.  
P.O. BOX 4444  
TAMPA, FL 33677  
TEL: (813) 251-0169  
FAX: (813) 251-0179

**ARCHITECT**  
SOFARELLI ARCHITECTURE, INC.  
6365 142ND AVENUE NORTH  
CLEARWATER, FL 33760  
TEL: (727) 530-3535  
FAX: (727) 530-4419

**LANDSCAPE ARCHITECT**  
KIMLEY HORN AND ASSOCIATES, INC.  
1777 MAIN STREET, SUITE 200  
SARASOTA, FL 34236  
TEL: (941) 379-7600  
CONTACT: CHRISTOPHER D. CIANFAGLIONE, PLA


**SURVEYOR**  
AFN CONSULTING, INC.  
9926 PREAKNESS STAKES WAY  
DADE CITY, FL 33525  
TEL: (813) 503-3226  
FAX: (352) 437-4078

**ELECTRICAL ENGINEER**  
POWER DESIGN, INC.  
11600 9TH STREET NORTH  
ST. PETERSBURG, FL 33716  
TEL: (727) 210-0492  
CONTACT: DOUGLAS P. ENGEL, P.E.

### PROJECT DATA

**PARCEL ID #:**  
13-30-16-78537-001-0011  
13-30-16-78535-002-0050  
13-30-16-78529-001-0010  
13-30-16-78534-001-0010  
13-30-16-78534-001-0020

THE SITE CONSTRUCTION STAKEOUT SHALL BE PERFORMED UNDER THE DIRECTION OF A FLORIDA REGISTERED SURVEYOR. AUTOCAD FILES WILL BE FURNISHED TO AID IN THE SITE CONSTRUCTION STAKEOUT. ANY DISCREPANCIES FOUND BETWEEN AUTOCAD FILES AND SITE CONSTRUCTION PLANS SHALL BE BROUGHT TO THE ENGINEER'S ATTENTION FOR CLARIFICATION PRIOR TO THAT STAKEOUT.

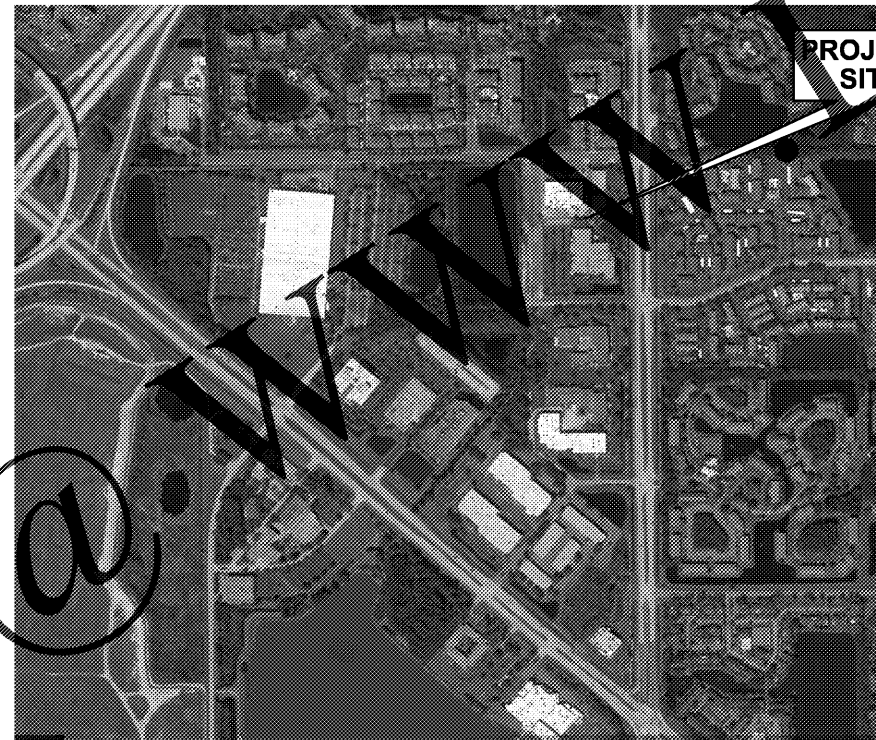

VICINITY MAP  
NTS

## PERMIT SET

JUNE 29, 2018  
Kimley»Horn

©2018 KIMLEY-HORN AND ASSOCIATES, INC.  
1777 MAIN ST, SUITE 200, SARASOTA, FL 34236  
PHONE: 941-379-7600  
WWW.KIMLEY-HORN.COM CA 00000696

Sheet List Table	
SHEET NUMBER	SHEET TITLE
S-000	COVER SHEET
S-100	GENERAL NOTES
S-101	EXISTING CONDITIONS
TM-100	OVERALL TREE MITIGATION PLAN
TM-101	TREE MITIGATION PLAN
TM-102	TREE MITIGATION PLAN
TM-103	TREE MITIGATION DATA AND CALCULATIONS
TM-190	TREE MITIGATION NOTES
H-100	PLAZA HARDSCAPE PLAN
H-101	CENTRAL PLAZA GRADING PLAN
H-150	HARDSCAPE DETAILS
H-151	HARDSCAPE DETAILS
H-152	HARDSCAPE DETAILS
H-154	HARDSCAPE DETAILS
H-155	HARDSCAPE DETAILS
SF-100	PLAZA SITE FURNISHING PLAN
L-100	PLAZA LANDSCAPE PLAN
L-101	PLANT SCHEDULE
IR-150	IRRIGATION PLAN
IR-151	IRRIGATION NOTES AND DETAILS
LV.CVR	COVER PAGE
LV2.01	INDEX, LEGENDS, DETAILS, RISER
LV2.01	PLAZA SITE PLAN
E0.01	ELECTRICAL LEGEND AND SYMBOLS
E0.02	LIGHT FIXTURE SCHEDULE
E1.00	ELECTRICAL SITE PLAN
E1.01	ENLARGED PLAZA - LIGHTING & POWER
E5.01	ELECTRICAL RISER, FEEDER SCHEDULE & DETAILS
E6.01	ELECTRICAL PANEL SCHEDULES

Order Plans

**Kimley»Horn**  
© 2018 KIMLEY-HORN AND ASSOCIATES, INC.  
1777 MAIN STREET, SUITE 200, SARASOTA, FL 34236  
PHONE: 941-379-7600  
WWW.KIMLEY-HORN.COM CA 00000696



K-HA PROJECT  
148299000  
DATE  
JUNE 2018  
SCALE AS SHOWN  
DESIGNED BY K-HA  
DRAWN BY K-HA  
CHECKED BY CDC  
DATE: 6/28/2018

COVER SHEET

PDI CAMPUS  
PREPARED FOR  
POWER DESIGN, INC.  
ST. PETERSBURG  
FLORIDA

SHEET NUMBER  
S-000



Picked By: Icrison, Alico Street Set: PDI\_CAMPUS\_Layouts-000 COVER SHEET June 29, 2018 08:51:44am K:\SAR\_URG\148299000 - pdi campus Improvements\CAD\Layouts-000 COVER SHEET.dwg  
 This document, together with the concepts and designs presented herein, is intended only for the specific purpose and client for which it was prepared. Reuse of and improper reliance on this document without written authorization and adaptation by Kimley-Horn and Associates, Inc. shall be without liability to Kimley-Horn and Associates, Inc.