


Plotted By: *Chris Mosley*
Plot Date / Time: 7/27/2018 7:41 AM
Project Directory: S:\System\Projects\Plaza LV6\AutoCAD\Drawings\LV6.01 - PDI Plaza Floor Plans.dwg

Order Plans @

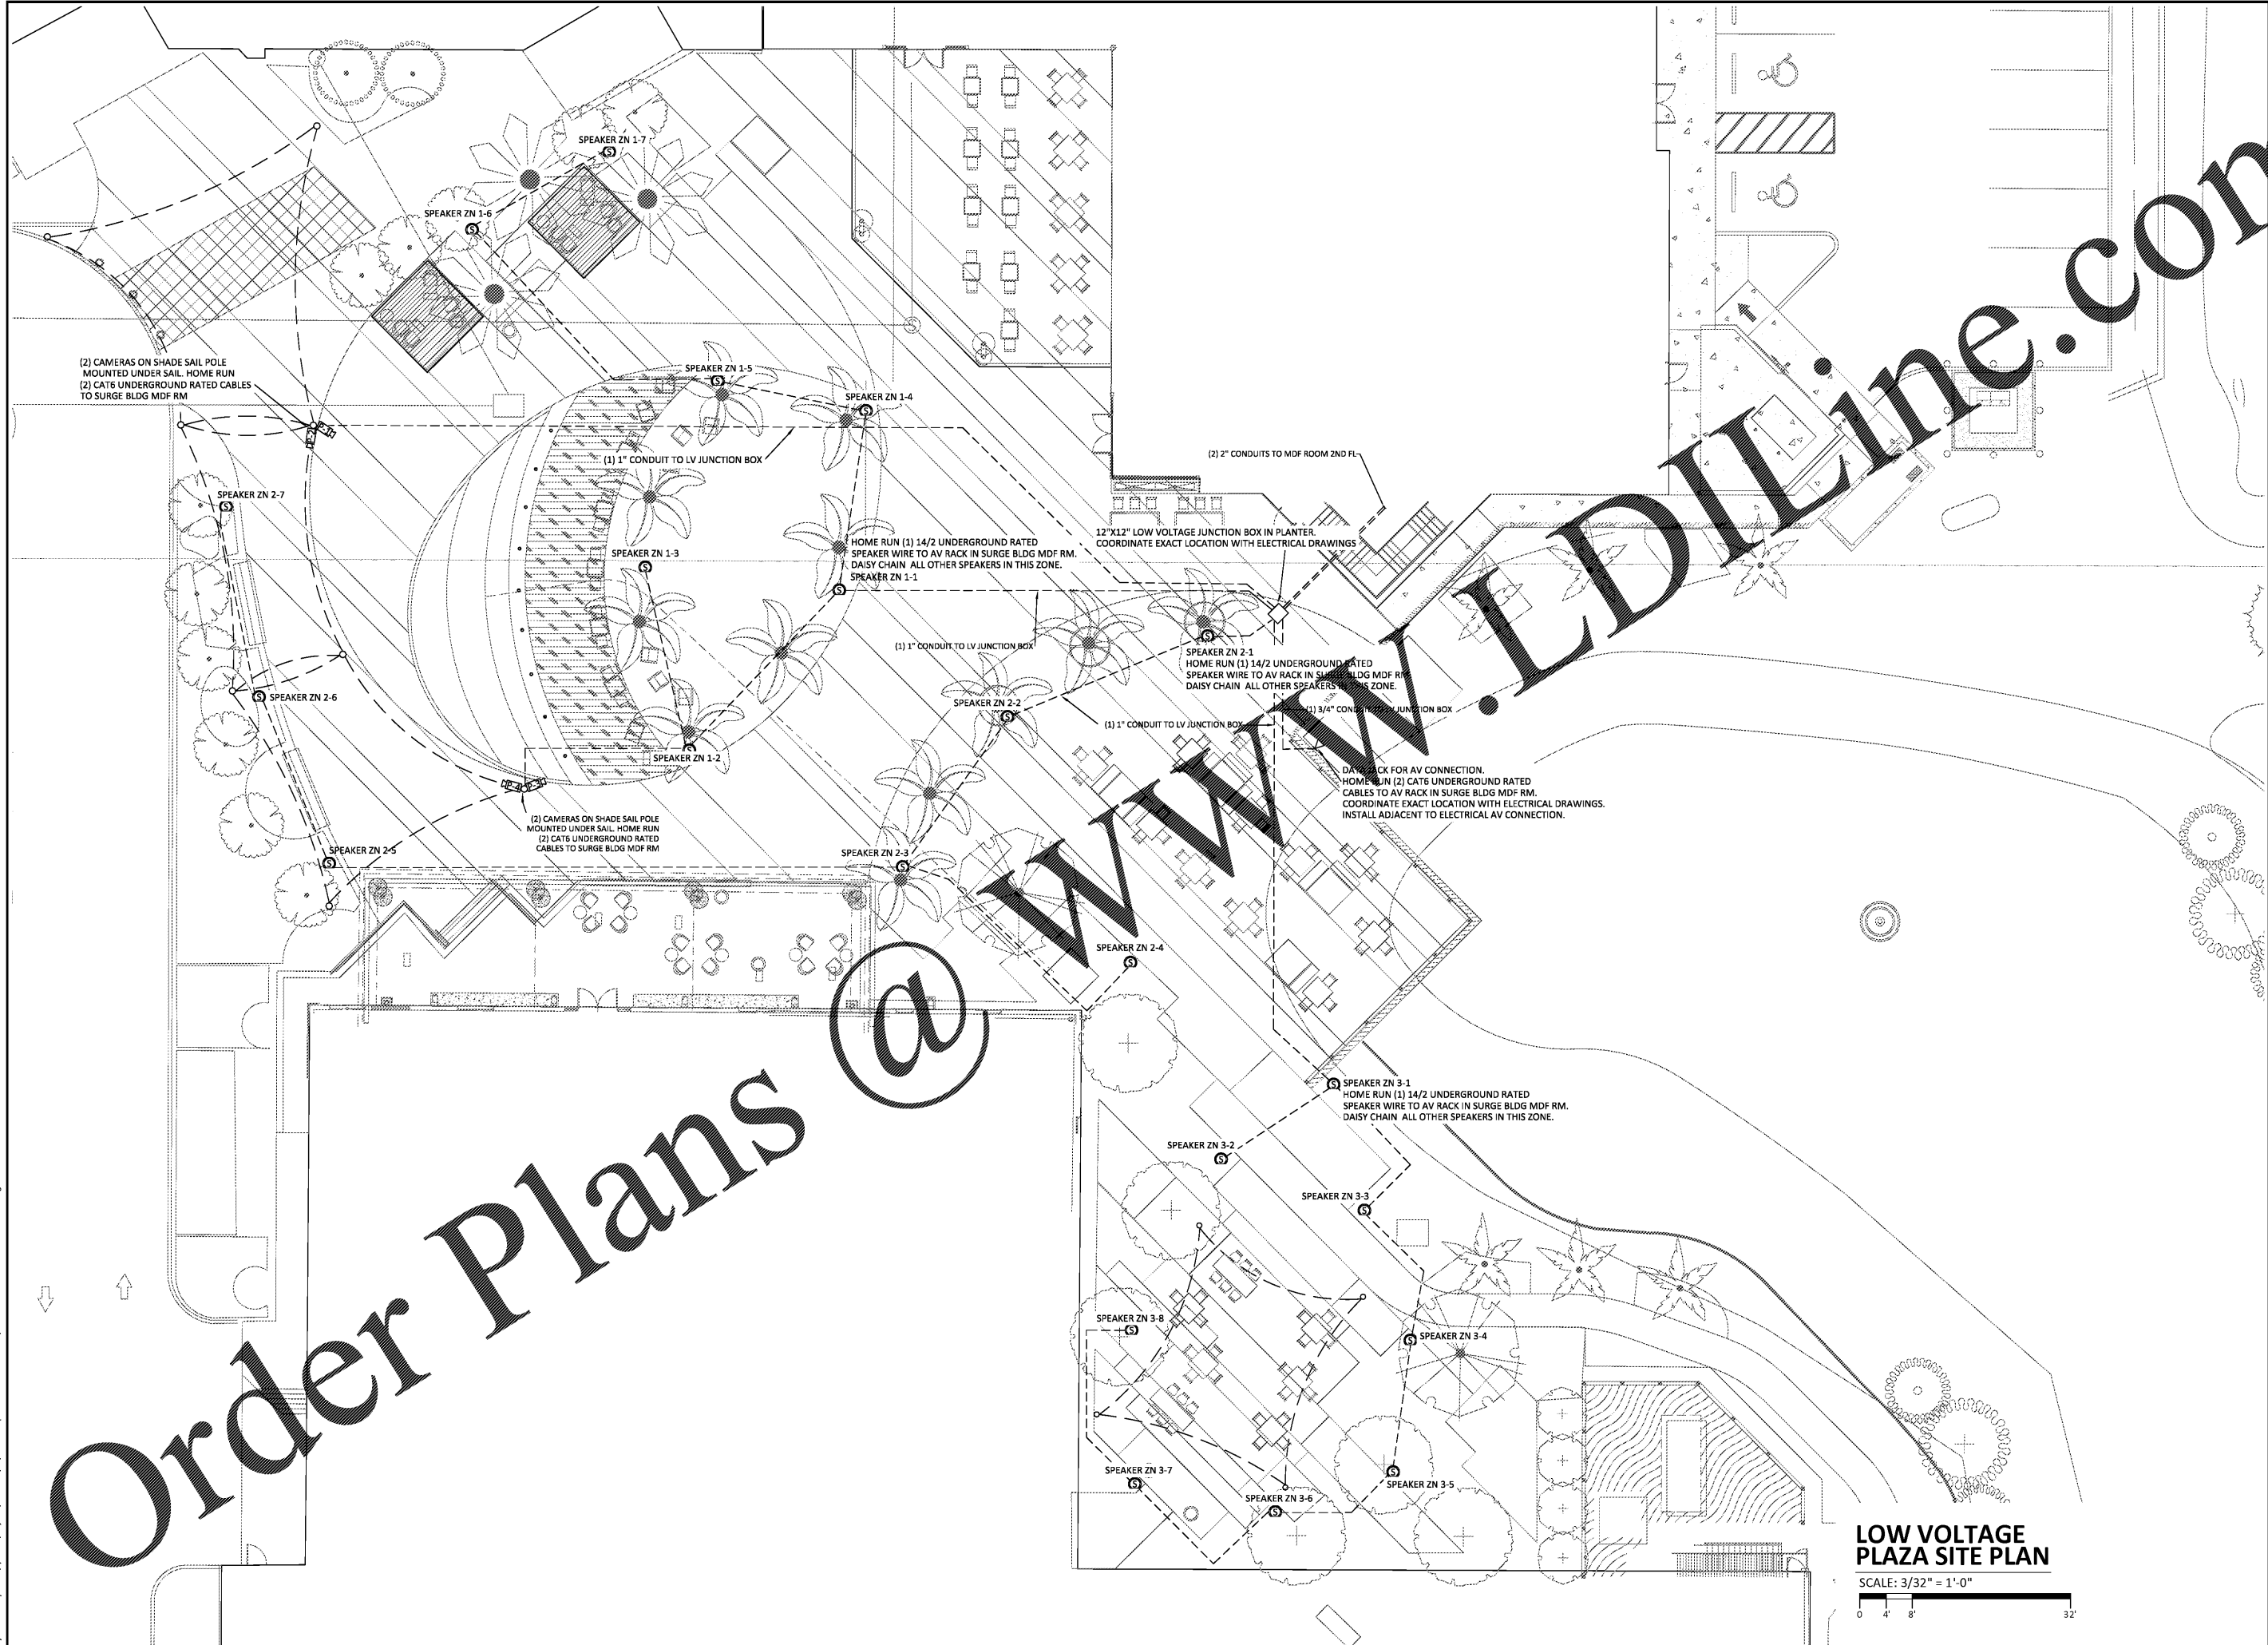

LOW VOLTAGE PLAZA SITE PLAN

SCALE: 3/32" = 1'-0"



 Power Design Incorporated 1600 North Street North, 33716 St. Petersburg, FL 33710-0492 P.O. #00004778076 Expires: 04/17/2018 DC: E.C. #801166 DC: #DN#90039 DC: #DN#90039 powerdesigninc.com	
Key Plan:	
PDI - PLAZA 1000 118th Ave North Saint Petersburg, FL 33716	
PDI - PLAZA	
Low Voltage	
CAD Technician: Perry Chapman	
Low Voltage Project Manager:	
Low Voltage Project Designer:	
6-29-2018 Permit Set	
Plaza Site Plan	
Date Issued: June 29, 2018	
Sheet Number: LV6.01	