

NOTES THIS SHEET

- ① SEE SHEETS P-001 - P-002 FOR SCHEDULES, DETAILS AND SPECIFICATIONS.
- ② PLUMBING CONTRACTOR SHALL TIE NEW SANITARY SEWER INTO CIVIL TAP. FIELD VERIFY EXACT LOCATION, INVERT ELEVATION AND FLOW DIRECTION.

**TEG**  
**TEETER ENGINEERING GROUP, P.A.**  
 RELIABILITY • COLLABORATION • DEDICATION • EXCELLENCE  
 5500 77 CENTER DRIVE • SUITE 140 • CHARLOTTE, NC 28217  
 704.776.2959 • WWW.TEGPA.COM • INFO@TEGPA.COM  
THIS DOCUMENT IS THE PROPERTY OF TEETER ENGINEERING GROUP, P.A. AND IS TO BE USED ONLY FOR THE PROJECT AND SITE SPECIFICALLY IDENTIFIED IN THE TITLE BLOCK. ANY REUSE OR REPRODUCTION OF THIS DOCUMENT WITHOUT WRITTEN PERMISSION FROM TEETER ENGINEERING GROUP, P.A. IS STRICTLY PROHIBITED. CONSULT YOUR ATTORNEY FOR MORE INFORMATION.  
**TEETER ENGINEERING GROUP, P.A.**  
 FLORIDA LICENSE # 6380

THE AUTO CLUB GROUP  
**AAA - CAR CARE CENTER**  
**TAMPA, FL 33607**  
 1701 NORTH WESTSHORE BLVD.

This item has been digitally signed and sealed by M. Michael Wilson, PE on 05-22-2018 using a Digit Signature.  
 Printed copies of this document are not considered signed and sealed and the DSA authentication code must be verified on any electronic copies.



If this document is sealed and signed in a digital or electronic format and is received from someone other than the sealing professional identified in the document, you must contact the sealing professional in writing to validate authenticity of the document. The sealing professional disclaims the seal and signature and shall not be liable for any liability associated with it where the authenticity of any digital or electronic seal or signature has not been validated in this manner.

ISSUANCE


REVISIONS

NO.	DATE	DESCRIPTION

FILE NUMBER	18030
PROJECT MANAGER	
PROFESSIONAL	
DRAWN BY	CLS
CHECKED BY	MMS


RETAIL AREA  
 FLOOR PLAN -  
 WASTE

P-101

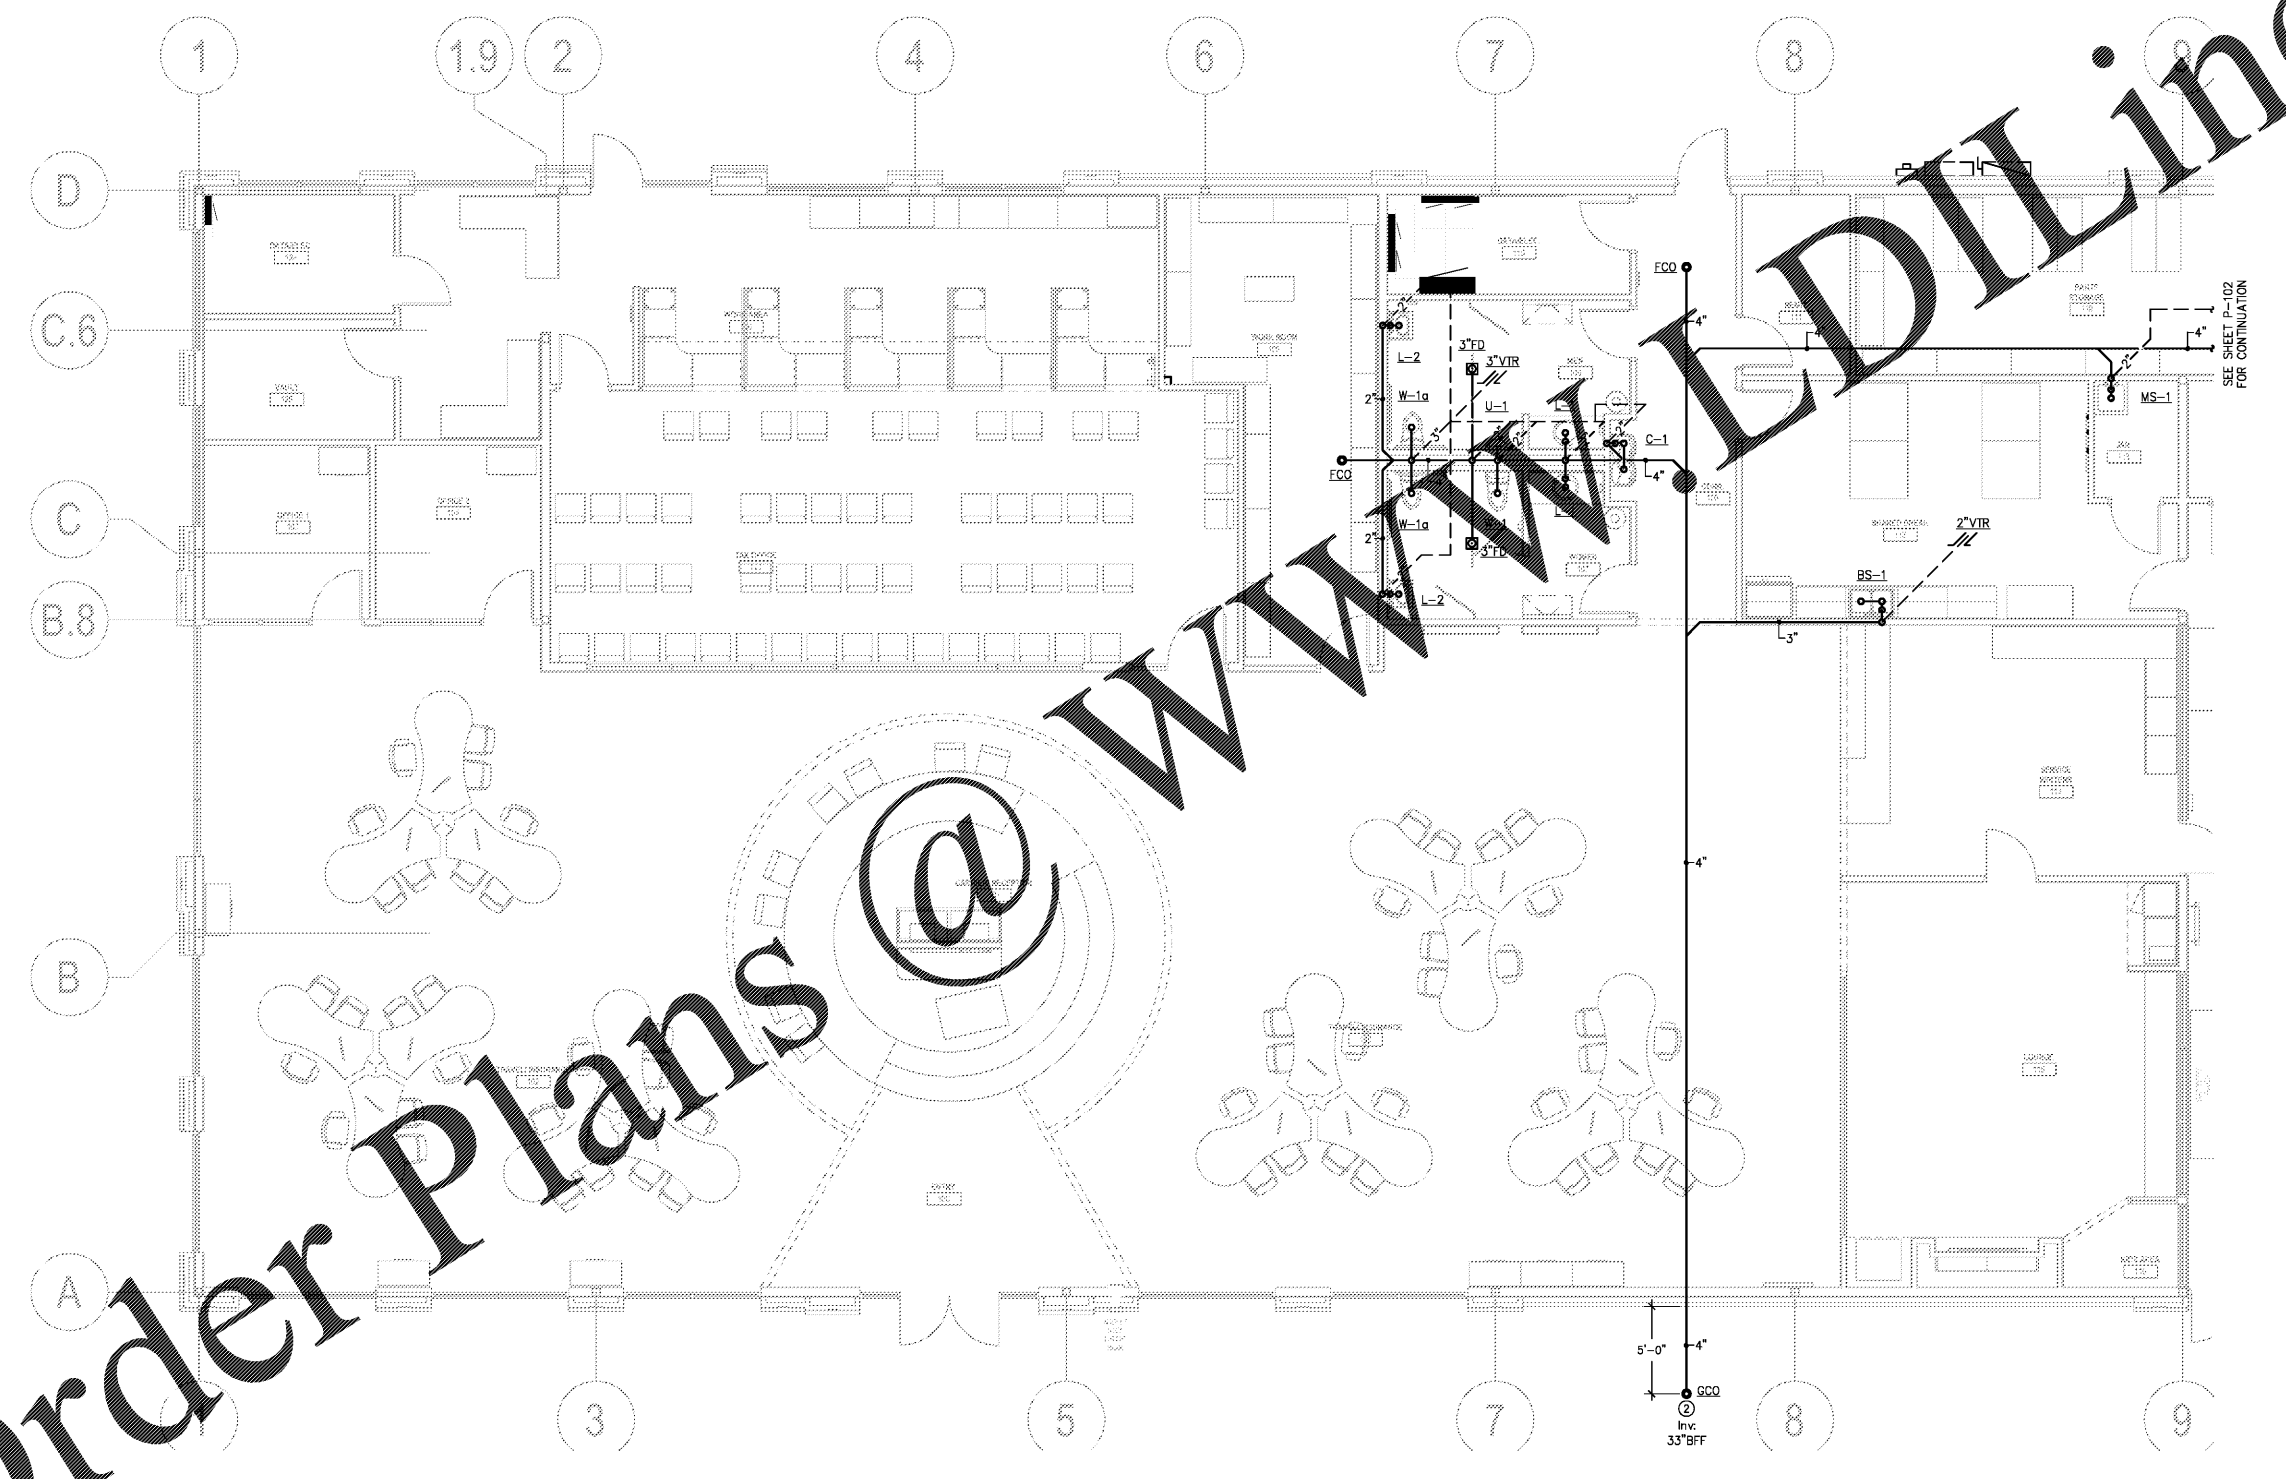

Order Plans @

1 RETAIL AREA  
 FLOOR PLAN - WASTE  
 SCALE: 3/16" = 1'-0"

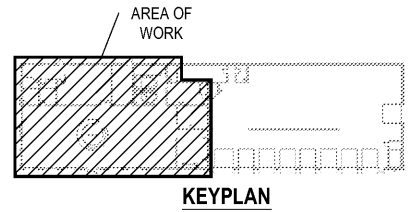

D

C

B

A

1

1.9

2

4

6

7

8

9

D

C.6

C

B.8

B

A

3

5

7

8

9

5'-0"  
 4"  
 GCO  
 Invc  
 33" BFF

SEE SHEET P-102  
 FOR CONTINUATION