


NOTES THIS SHEET

- ① SEE SHEETS P-001 - P-002 FOR SCHEDULES, DETAILS AND SPECIFICATIONS.
- ② PLUMBING CONTRACTOR SHALL TIE NEW STORM DRAIN INTO CIVIL TAP. FIELD VERIFY EXACT LOCATION, INVERT ELEVATION AND FLOW DIRECTION PRIOR TO ROUGH-IN.
- ③ PROVIDE DOWNSPOUT COVER DC. DOWNSPOUT COVER SHALL BE CENTERED IN WALL SEGMENT. COORDINATE EXACT LOCATION AND HEIGHT AFG WITH ARCHITECTURAL DRAWINGS PRIOR TO ROUGHING-IN.
- ④ ROUTE PIPING TO AVOID CONFLICTS. COORDINATE WITH ARCHITECT PRIOR TO ROUGHING-IN. PROVIDE CLEAN-OUT AT BASE OF RISERS.
- ⑤ ROUTE ALL HORIZONTAL RL/ORL PIPING AT 1/8" LN/FT UNLESS NOTED OTHERWISE.



TEETER ENGINEERING GROUP, P.A.
 RELIABILITY • COLLABORATION • DEDICATION • EXCELLENCE
 5500 77 CENTER DRIVE • SUITE 140 • CHARLOTTE, NC 28217
 704.376.2999 • WWW.TEGPA.COM • INFO@TEGPA.COM
 OTHER PROJECTS REFER TO THESE DOCUMENTS: ANY ASSOCIATED PROJECTS ARE NOT PART OF THIS DOCUMENT. ANY ASSOCIATED PROJECTS ARE NOT PART OF THIS DOCUMENT. ANY ASSOCIATED PROJECTS ARE NOT PART OF THIS DOCUMENT.
 TEETER ENGINEERING GROUP, P.A.
 FLORIDA LICENSE # 6380

THE AUTO CLUB GROUP
AAA - CAR CARE CENTER
TAMPA, FL 33607
 1701 NORTH WESTSHORE BLVD.
 PROGRESSIVE ARCHITECTURE ENGINEERING, P.C.
 330 South Tylan St. Suite 500 | Charlotte, NC 28202 | 704.721.6900 | www.progressiveuae.com

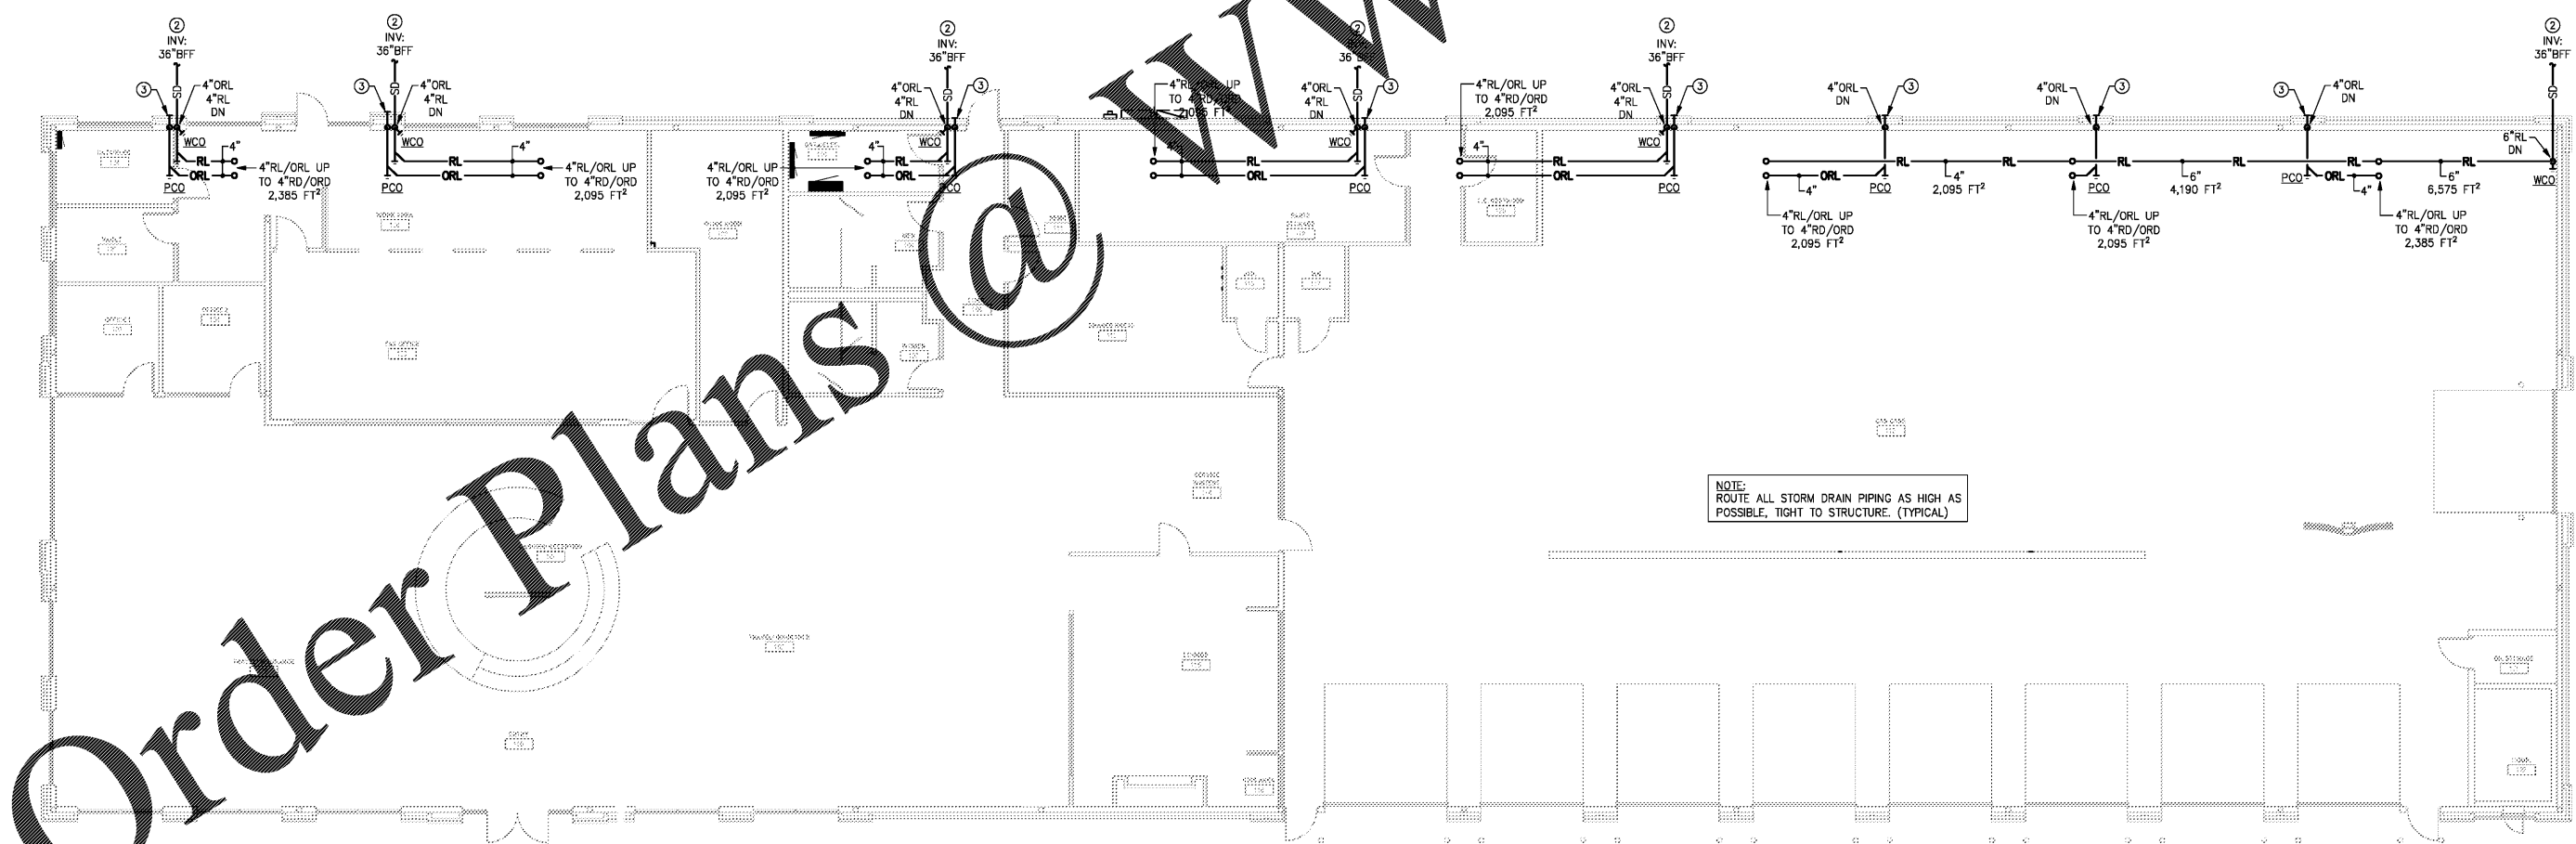

Order Plans @ WWW.LDILine.com

1 FLOOR PLAN - STORM DRAINAGE
 SCALE: 1/8" = 1'-0"

This item has been digitally signed and sealed by Michael Wilson, PE on 08-23-2023 using a Digit Signature.
 Printed copies of this document are not considered signed and sealed and the DSA authentication code may be verified on any electronic copies.



If this document is sealed and signed in a digital or electronic format and is received from someone other than the sealing professional (as listed in the document), you must contact the sealing professional in writing to validate authenticity of this document. The sealing professional guarantees the seal and signature and shall not be liable for any liability associated with it where the authenticity of any digital or electronic seal or signature has not been validated in this manner.

ISSUANCE

NO.	DATE	DESCRIPTION

REVISIONS

NO.	DATE	DESCRIPTION

FILE NUMBER: 16030
 PROJECT MANAGER:
 PROFESSIONAL:
 DRAWN BY: CLS
 CHECKED BY: MMS