

SHEET NOTES


- OPENING IN SOLID SURFACE COUNTERTOP, FIXTURE VENDOR TO COORDINATE WITH EQUIPMENT SPECIFICATIONS REFER TO 1/A4.2.
- TRANSFLETE BOXES, TYP & REFER EQUIPMENT SCHEDULE E20.
- VINYL TAPESTRY GRAPHIC, SIGN VENDOR TO SUPPLY AND INSTALL. REFER 2/A3.1.
- SURFACE APPLIED DIMENSIONAL LETTERS AND HAAGEN DAZS CARTOUCHE SIGNAGE, SUPPLIED AND INSTALLED BY SIGN VENDOR. REFER 5/A3.1. VINYL GRAPHIC, SIGN VENDOR TO SUPPLY AND INSTALL. REFER A3.1.
- PRICING BOARD (20" X 48"), APPLIED TO TILE FINISH WITH DOUBLE-SIDED TAPE.
- HIGH-TOP TABLE TO BE FREE-STANDING, ANCHOR TO FLOOR W/ EXPANSION ANCHORS. REFER TO HIGH-TOP TABLE DETAIL 2/A4.3.
- COORDINATE BAR STOOL, A4.1 FURNITURE FINISH SCHEDULE; FN-1.
- FRAMED ARTWORK COLLAGE, VARIES SIZES, SIGN VENDOR TO SUPPLY AND INSTALL. REFER A3.1.

FOOD SERVICE EQUIPMENT NOTES

- ALL FOOD SERVICE EQUIPMENT TO BE FURNISHED WITH CORD AND PLUG UNLESS OTHERWISE INDICATED.
- ALL FOOD SERVICE EQUIPMENT & BEVERAGE DISPENSING EQUIPMENT SHALL COMPLY WITH NSF REQUIREMENTS, AND REQUIREMENTS OF LOCAL HEALTH DEPARTMENT OFFICIALS HAVING JURISDICTION.
- PROVIDE A SHUTOFF VALVE AT HOT AND/OR COLD WATER SERVICE TO EACH EQUIPMENT ITEM.
- PROVIDE A BACKFLOW PREVENTER HOT AND/OR COLD WATER SERVICE TO EACH EQUIPMENT ITEM (OTHER THAN SINKS) DOWNSTREAM OF SHUT-OFF VALVE. REFERENCE PLUMBING PLAN FOR ADDITIONAL INFORMATION.
- INSTALLATION AND CONNECTION OF ALL FOOD SERVICE EQUIPMENT TO BE PERFORMED BY GENERAL CONTRACTOR UNLESS OTHERWISE INDICATED. ALL SHELVING UNITS SHALL BE ASSEMBLED AND SET IN PLACE BY THE GENERAL CONTRACTOR.
- ALL SINKS PROVIDED BY THE FOOD SERVICE EQUIPMENT SUPPLIER SHALL BE COMPLETE WITH DRAIN TAILPIECE AND FITTINGS. THE GENERAL CONTRACTOR SHALL PROVIDE SHUTOFF VALVES, SUPPLIES AND TRAPS NECESSARY TO CONNECT SUCH SINKS.
- VERIFY ELEC & MECH REQUIREMENTS OF ITEMS NOTED AS BEVERAGE EQUIPMENT (AND NOTED TO BE PROVIDED BY THE OWNER) PRIOR TO INSTALLATION OF SERVICE.

SHEET SYMBOLS

EXX EQUIPMENT TAG - SEE SCHEDULE

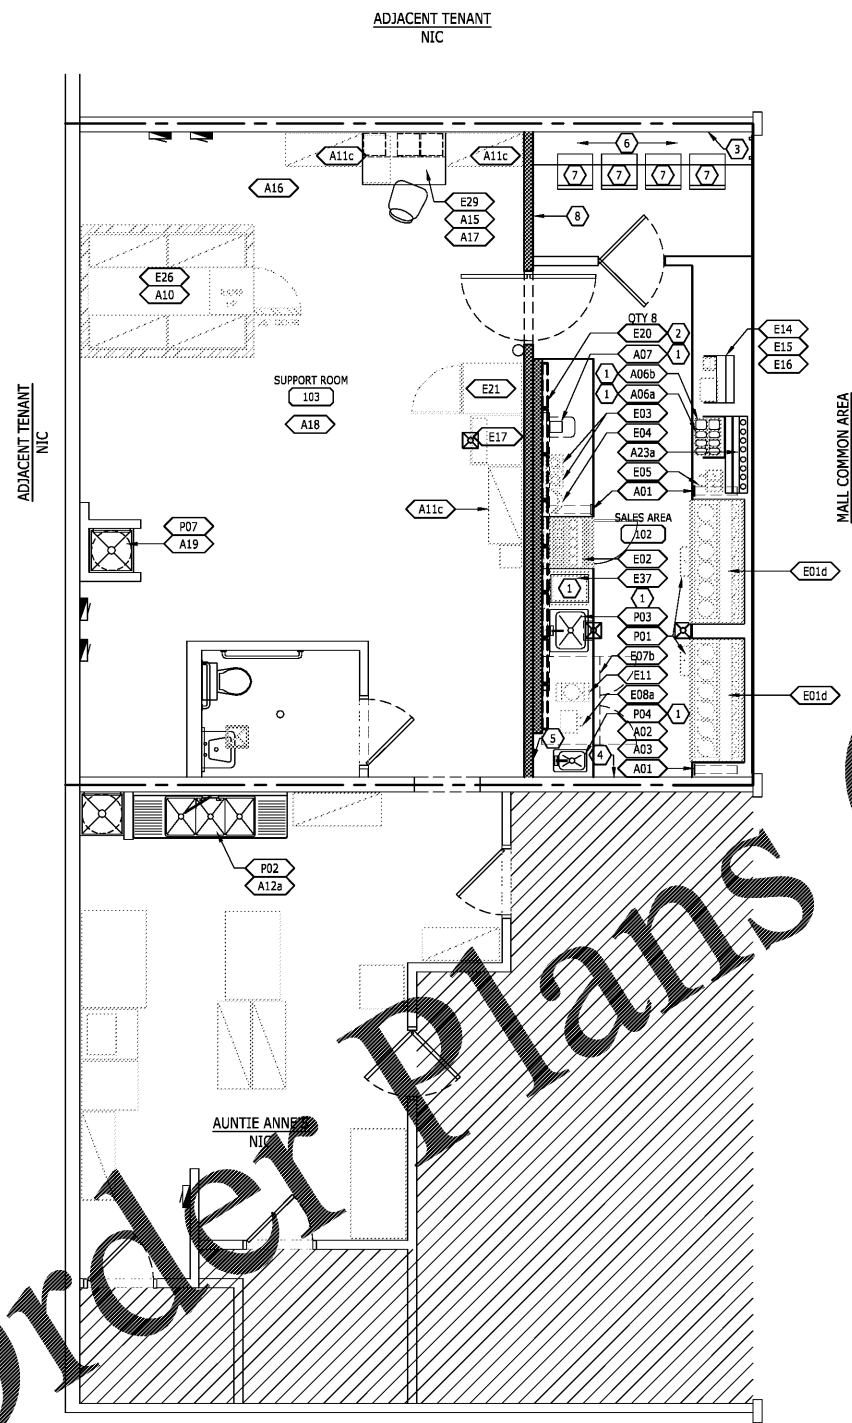

ID	ITEM	AKA	MANUFACTURER	DESCRIPTION	PRODUCT	FINISH	VOLTAGE	AMPS	RECEPT / DISCONNECT	COMMENTS
E01d	Dipping Cabinet (12 Hole)	VISIDIPPER	Global Refrigeration Inc		CKDC67V-W	white/stainless steel	120/1	12.5	NEMA 5-20R	20 X 3 gal TUBS, w/ 1" rollers with pumps and jar kit 22590-02, 2" recessed casters
E02	Syrup Rail	SILVER KING	Silver King		SFK2A/C5	ss/galvanized back	120/1	4.6	NEMA 5-20R	
E03	Blender		Hamilton Beach		HBH550 Fury	Black	120/1	13	NEMA 5-20R	
E04	Triple Spindle Dispenser		Hamilton Beach		HMD400	Silver	120/1	10	NEMA 5-20R	
E05	Hot Topping Dispenser		SERVER		EZT 85899	stainless steel/black	120/1	3.5	NEMA 5-20R	To be modified per drawing
E07b	Two Door Refrigerator		COMMERCIAL FRIDGE		CRMR48	stainless steel	120/1	3.9	NEMA 5-20R	with doors, w/ 3" casters
E08a	2-well dip warmer		CONTOUR WARMER		DI-2 #92020	stainless steel	120/1	1	NEMA 5-20R	
E11	Waffle Cone Baker		CoBatCo		MD-10SSE	stainless steel/black	120/1	10	NEMA 5-20R	
E14	Cash Drawer		APG Cash Drawer		1616	black	120/1		NEMA 5-20R	
E15	Monitor		Samsung		Titan	black	120/1		NEMA 5-20R	
E16	Receipt Printer	RECEIPT PRINTER	Epson		TM-T88V		120/1		NEMA 5-20R	
E19	Cube Refrigerator		Hoshizaki America, Inc.		KMD-410MAH		120/1	8	NEMA 5-20R	with bin EID-300sf (comes with 6" legs)
E20	Transflete Box		VGS			NTM-1 and gold pinstripping	120/1		NEMA 5-20R	By Owner and installed by GC
E21	Door R-1 freezer		Hoshizaki America, Inc.		CF1-S-FS	stainless steel	120/1	9	NEMA 5-20R	single section, full height solid door, w/ 4" casters
E26	Waffle Freezer		Amerikooler		6x8 frz	steel	208/1		30AS/NF/ZP	
E29	Security Video/Monitor		Provided by Owners Vendor				120/1	3.9	NEMA 5-20R	GC to provide wiring to cameras at locations selected by owner
E37	Freezer Drop-in Bin		Advanced Tabco		D-24-1BL	Stainless steel				
P01	Dipper well		Western Pioneer Sales		PMV-16	stainless steel				
P02	(E) 3-Compartment sink	EXISTING								
P03	Drop in waste sink		Advance Tabco		DI-1-2012	stainless steel				with faucet
P04	Drop in hand sink		Klinger's Trading		SPD15-1014	stainless steel				with faucet
P07	(E) Mop Sink	EXISTING								
A01	Cup Dispenser		San Jamar		6200C & 6400C	stainless steel				horizontal
A02	Paper Towel Dispenser		Bobrick		B-2620	stainless steel				
A03	Soap Dispenser		Bobrick		B-2112					
A05a	Food Pan	1/9 pan	WEBSTAURANTSTORE			Clear Polycarbonate				1/9: 6.75" x 4.25" x 4"D, 1.25 QT
A06b	Food Pan	1/6 pan	WEBSTAURANTSTORE			Clear Polycarbonate				1/6: 6.75" x 6 3/8" x 6", 2.5 QT
A07	Trash Bin		Rubbermaid 2957							
A10	6x8 Freezer Storage Shelving Set		Metro		Metroseal	Metroseal coated wire shelving				GC to install freezer shelving at the following Hts. 6" AFF, 38" AFF & 70" AFF
A11c	18" x 42" Storage Shelf Unit		Metro		A1842BR with 86P	Super Erecta Shelf				42"W x 18"D x 86-5/8"H
A12a	(E) 36" Over Shelves	EXISTING								
A15	2-Dwr File Cab		From Office Max or equal							2-dwr file cabinet w/locks
A16	Lockers		Perico/Vanguard or equal		6325V	White				4 tier unit - 12"W x 60"H x 12"D equipped for personal padlocks Provide anchorage to floor, cabinet or shelf as req'd., Coordinate location with owner.
A17	Safe		Provided by Owners Vendor							Owner to provide placement Provide new if not existing
A18	Tackboard		Provided by Owners Vendor							
A19	Mop & Broom Holder		Rubbermaid		Handler #1993	Walnut Wood				
A23a	Topping Ledge (42" length)									By Owner

Order Plans

WWW.LDILine.com



SHOP# 1306
SPACE #1164
WEST TOWN MALL
7600 KINGSTON
PIKE
KNOXVILLE, TN
37919

Date	
Revisions	
NO.	

pams
design group
2225 East Randol Mill Road, Suite #300
Arlington, Texas 76011
817.633.4200 • 817.633.4153 f

mb
MICHAEL R. BLACK, AIA
2225 E. RANDOL MILL RD., SUITE 300
ARLINGTON, TEXAS 76011
817.701.4819
TENNESSEE REG. NO.: 104432



Project No.	180165
Scale	AS NOTED
Drawn	CAL
Checked	RER
Date	06/29/2018
Drawing Title	

EQUIPMENT PLAN & SCHEDULE

Drawing No. **A1.1**

V:\180165\180165_A1.1_6/29/2018 9:29:54 AM, CLIVINGSTON