


- KEYED NOTES**
- EXIT LIGHTS, EMERGENCY, AND NIGHT LIGHTS SHALL BE POWERED BY UN-SWITCHED BRANCH OF CIRCUIT.
  - PROVIDE RECEPTACLE FOR POWER TO TRANSLITE BOX. COORDINATE REQUIREMENTS WITH MANUFACTURER PRIOR TO INSTALLATION. SEE ELEVATIONS 4/A3.1. REFERENCE DETAIL 4/A5.0 FOR INSTALLATION OF ELECTRICAL OUTLET.
  - SWITCH GANG. SEE LIGHTING CONTROL DIAGRAM ON THIS SHEET.
  - EXISTING TOILET EXHAUST FAN TO REMAIN.

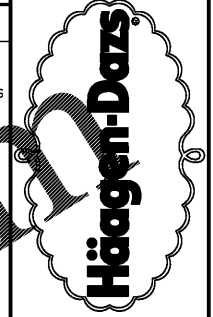

SHOP# 1306  
SPACE #1164  
WEST TOWN MALL  
7600 KINGSTON  
PIKE  
KNOXVILLE, TN  
37919

**1 LIGHTING PLAN**  
1/4"=1'-0"


**GENERAL NOTES**

- COORDINATE ALL WORK WITH OTHER TRADES AND EXISTING CONDITIONS AS REQUIRED TO PROPERLY INSTALL ALL SYSTEMS AS INTENDED, WITHIN THE CONFINES OF THE SPACES AVAILABLE, AND WITHOUT INTERFERENCES.
- IT IS THE ELECTRICAL CONTRACTORS RESPONSIBILITY TO PROPERLY BALANCE ALL BRANCH CIRCUITS BETWEEN THE PHASES OF THE SYSTEM. REGARDLESS OF CIRCUITING INDICATED.
- REFER TO ARCHITECTURAL DRAWINGS FOR EXACT LOCATION OF LIGHT FIXTURES AND DEVICES.
- REFER TO ELECTRICAL SPECIFICATIONS ELSEWHERE IN THESE DRAWINGS FOR FURTHER INFORMATION AND REQUIREMENTS. GENERAL CONDITIONS AND SUMMARY OF WORK ALSO DIRECTLY APPLY TO THIS WORK.
- ALL ELECTRICAL PENETRATIONS INTO COOLER SHALL BE SEALED PER NEC 300-7.
- ALL 120V RECEPTACLES IN THE KITCHEN AREA SHALL BE GFI PROTECTED PER NEC 210-8.

**LUMINAIRE SCHEDULE**

TAG	SYMBOL	MODEL	LAMP	DESCRIPTION	NOTES	MOUNTING	WATTS	QTY.
A		WAC LIGHTING: PD-52214BR	LED (INCLUDED)	BRASS PENDANT FIXTURE	1	SURFACE	4	3
C		SOLAIS: XR4NC-D-XM24-25-30K-1600-WH-H	LED 3000K, 1600lm, 25° OPTIC (INCLUDED)	RECESSED LED DOWNLIGHT (WHITE TRIM)	1	RECESSED	19	6
E		SOLAIS: XFR13-XM24-15M-15M-30K-1850-WH-WH	LED 3000K, 1850lm, 15° OPTIC (INCLUDED)	RECESSED ADJUSTABLE LED DOWNLIGHT (3 LAMP)	1	RECESSED	1	1
EM		ENCORE: PC6-10	5.4W HALOGEN(x2) (INCLUDED)	BATTERY OPERATED EMERGENCY FIXTURE (90 MINUTE MINIMUM DISCHARGE)	1,3	SURFACE	4.4	2
J		METALUX: 24GR-LD4-30-F1-UNV-L830-CD1-U	LED 3000K, 3000lm (INCLUDED)	RECESSED LED 2X4 TROFFER		RECESSED	22	8
X		SURE-LITE: APX7R	LONG LIFE LED (INCLUDED)	BATTERY OPERATED EMERGENCY LIGHT	1,3	SURFACE	1	1

- NOTES:
- LIGHT FIXTURES MUST BE PURCHASED THROUGH THOMAS RIGHARDS WITH TARRANT LIGHTING, (817) 439-1392
  - FIXTURE & ACCESSORIES MUST BE PURCHASED BY T.G.C.
  - PROVIDE UNSWITCHED BRANCH OF CIRCUIT TO POWER EMERGENCY BATTERY

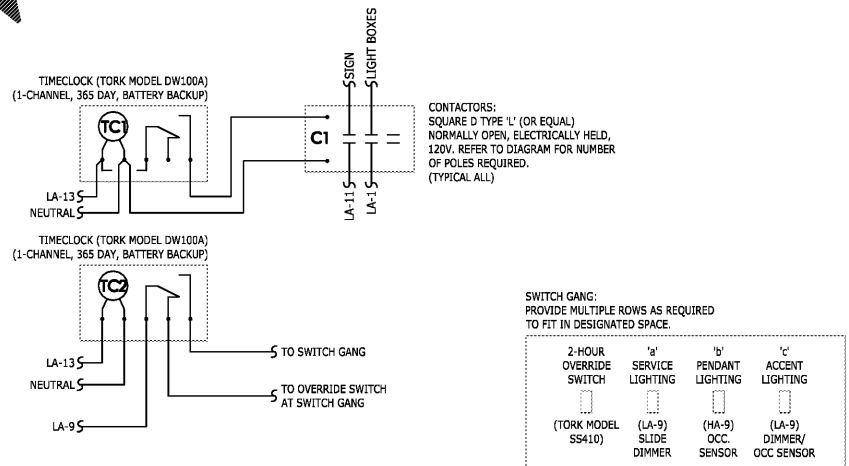

- NOTES:
- CONTRACTOR SHALL PROGRAM ON/OFF TIMES AS DECIDED BY TENANT OR REQUIRED BY LANDLORD.
  - TIMECLOCK AND CONTACTORS SHALL BE LOCATED NEAR ELECTRICAL PANELS. SWITCH GANG SHALL BE LOCATED AS SPECIFIED ON PLAN.
  - PROVIDE LABEL OVER OVERRIDE SWITCH STATING "2-HOUR LIGHTING OVERRIDE". LABEL SHALL BE BAKELITE PLASTIC WITH 1/4" LETTERS.

Order Plans @

WWW.LDILine.com

**2 LIGHT FIXTURE SCHEDULE**

**3 LIGHTING CONTROL DIAGRAM**

**pdm**  
design group  
2225 East Randal Mill Road, Suite #300  
Arlington, Texas 76011  
817.633.4200 • 817.633.4153 F

**DR**  
DANIEL A. REEVES, P.E.  
2225 E. Randal Mill Rd, Suite 300  
Arlington, TX 76011  
(817)701-4808  
FAX (817)633-4153  
Tennessee License #116073



Project No.	180165
Scale	AS NOTED
Drawn	AH
Checked	DAR
Date	06/29/2018
Drawing Title	

**LIGHTING PLAN**  
Drawing No. **E2.0**