


SWED BY: ERIC 5/15/2018 11:33 AM
PRINTED BY: ERIC 7/3/2018 12:17 PM
2180148_P101_Preview.rvt

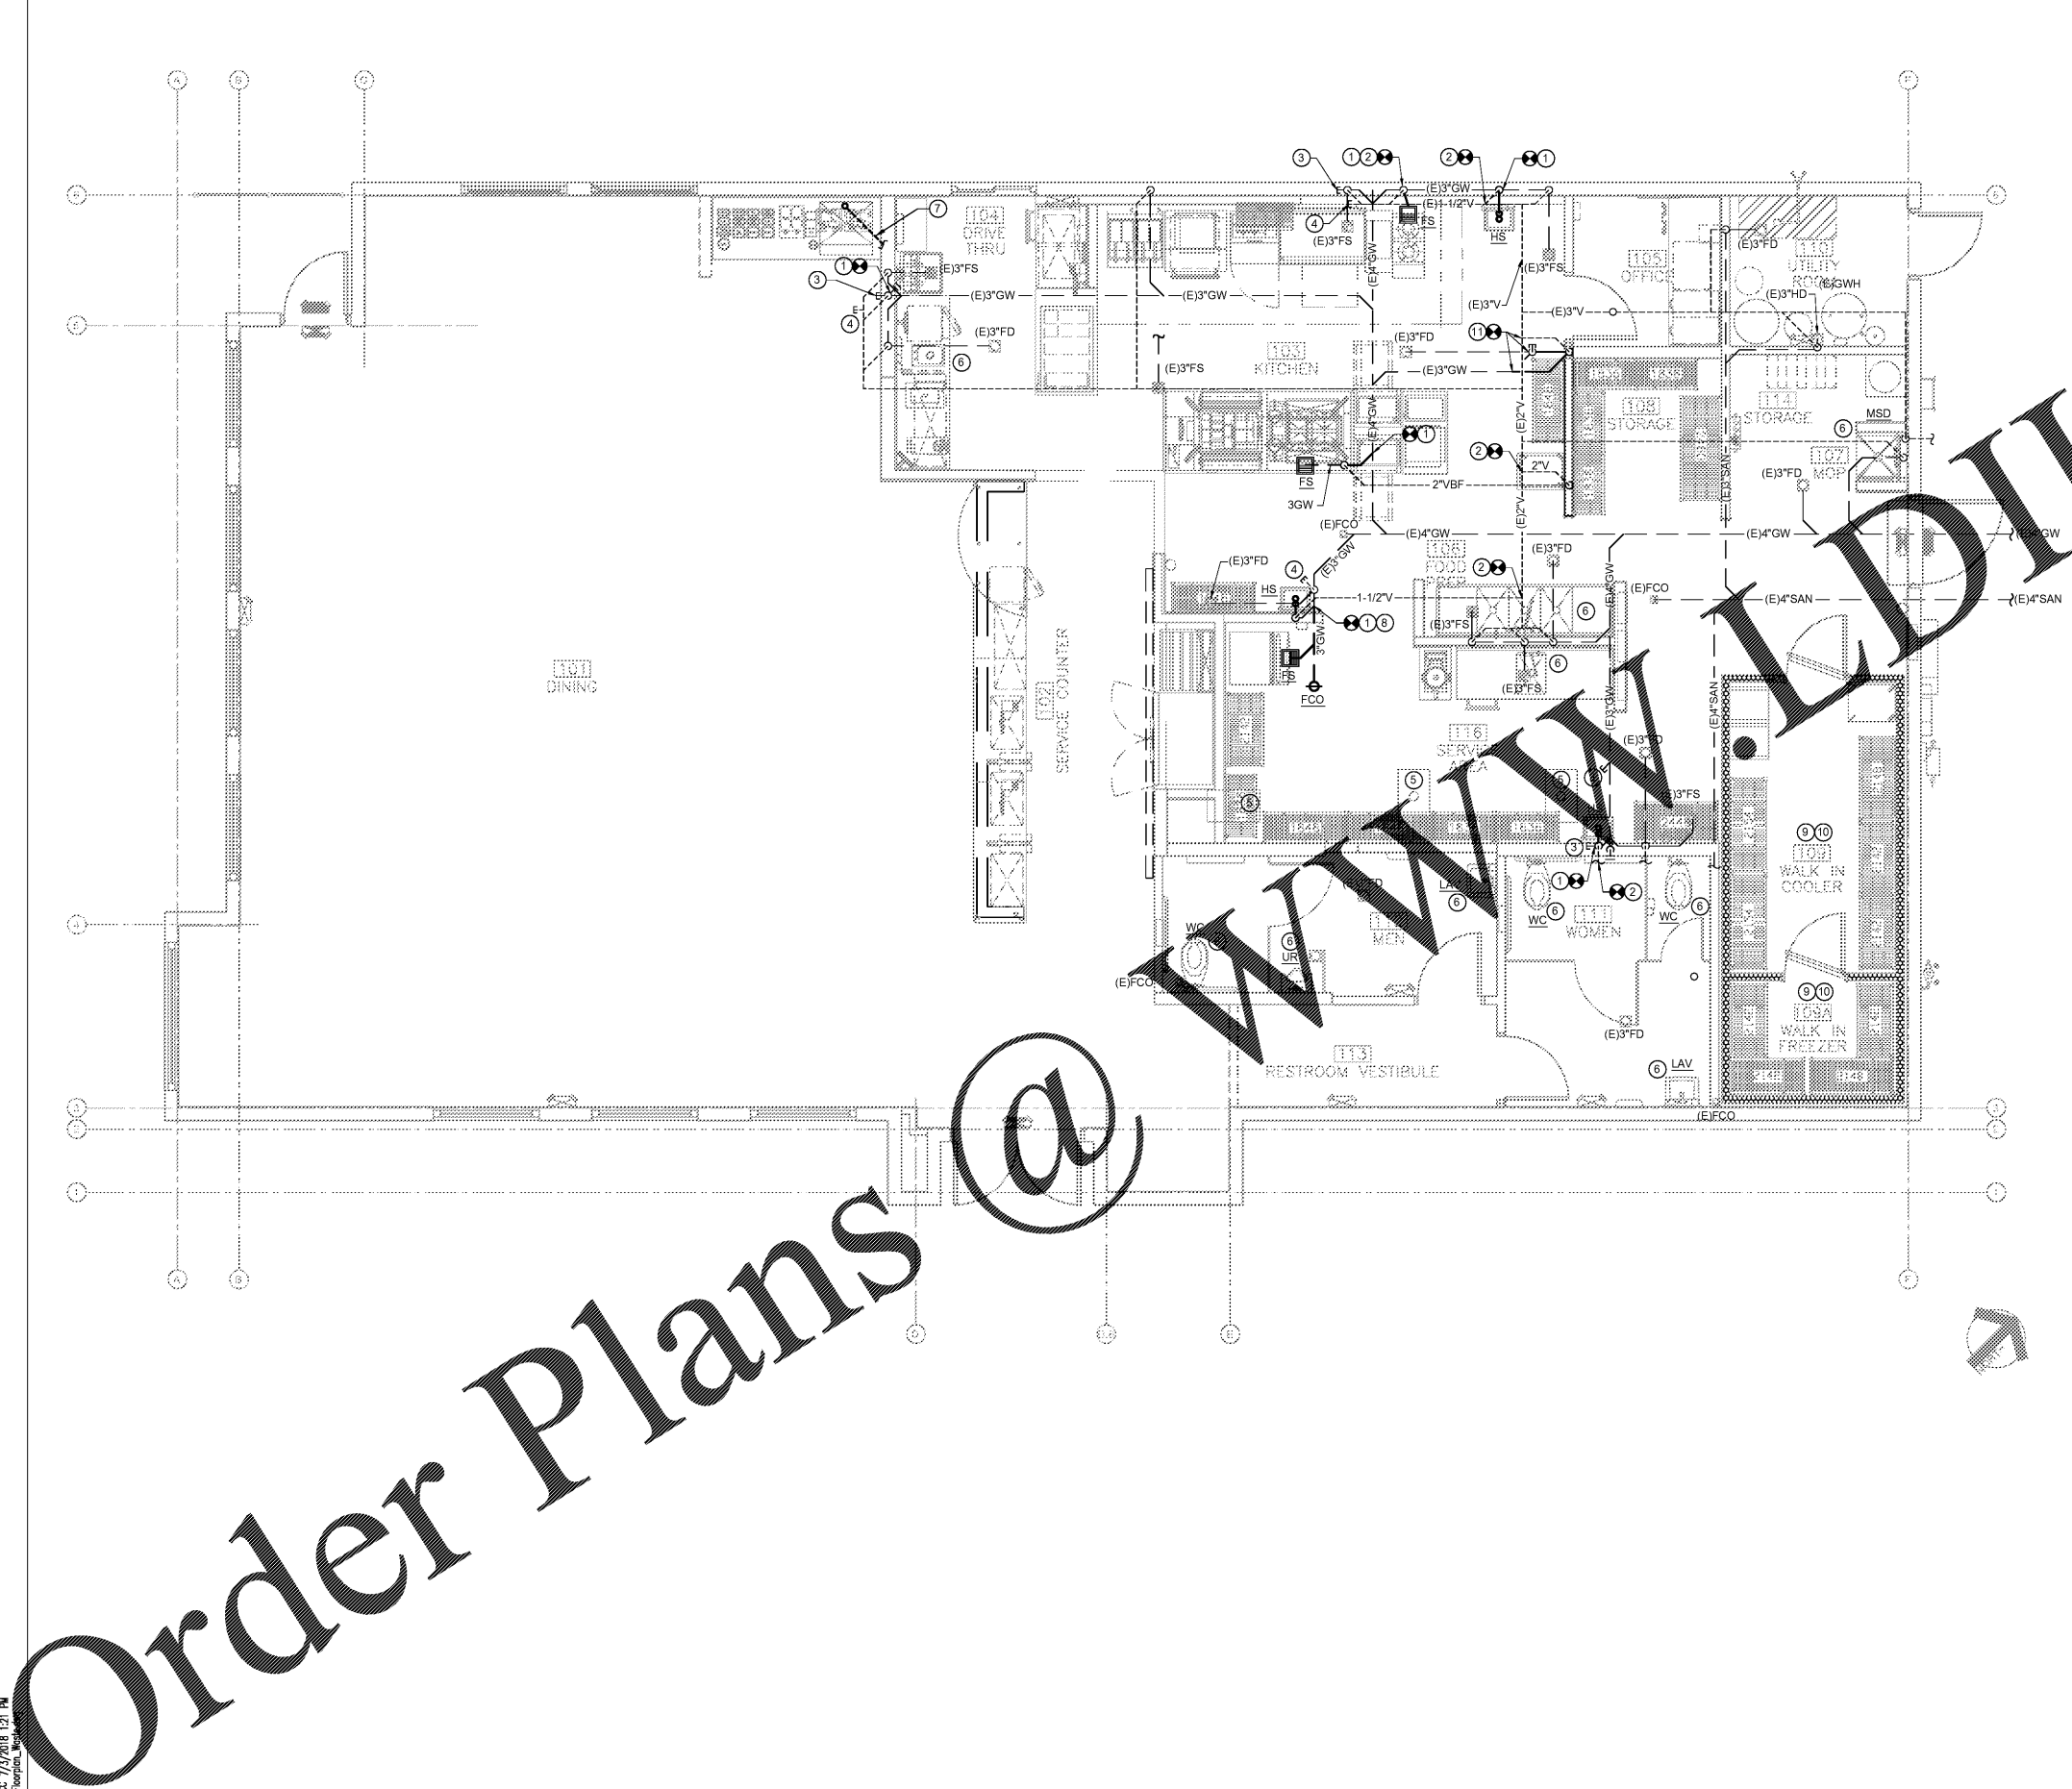


GENERAL NOTES

- REFER TO SHEET P001 FOR GENERAL PLUMBING NOTES APPLICABLE TO ALL PLANS.
- COORDINATE FLOOR DRAIN LOCATIONS WITH FINAL KITCHEN EQUIPMENT PLAN. REFER ALSO ARCHITECTURAL DRAWINGS FOR FLOOR FINISH PLAN FOR ADDITIONAL INFORMATION.
- REFER TO KITCHEN PLANS FOR DETAILS ON INDIRECT WASTE.

KEYNOTES

- CONNECT NEW SANITARY/GREASE WASTE TO EXISTING. VERIFY LOCATION AND INVERT ELEVATION.
- CONNECT NEW VENT PIPING TO EXISTING.
- EXISTING UNDERGROUND PIPING TO BE CAPPED BELOW FINISHED FLOOR. REMOVE EXISTING FIXTURES, DRAINS, SINKS, TUBS, ETC. REMAINING UNUSED PIPING TO BE CAPPED BELOW FINISHED FLOOR AND ABANDONED.
- CAP EXISTING VENT PIPING AT MAIN, AND REMOVE ALL UNUSED ABOVE GROUND VENT PIPING.
- REMOVE EXISTING FIXTURES AND PIPING BELOW FINISHED FLOOR.
- EXISTING FIXTURE TO BE REPLACED WITH NEW. MODIFY/REPLACE PIPING SERVING FIXTURE AS NEEDED.
- REMOVE 3/4\"/>
- REPLACE EXISTING 2\"/>
- FIELD VERIFY THAT ALL CONDENSATE DRAIN LINES IN WALK-IN COOLER AND FREEZER ARE HEAT TRACED AND INSULATED.
- IF EXISTING LINES ARE NOT HEAT TRACED, PROVIDE ELECTRIC HEAT TRACING SERVING CONDENSATE LINES IN FROZEN STORAGE ROOM. CIRCUIT BREAKER JUNCTION BOX MODEL TYCO THERMAL CONTROL RAYCHEM XL-TRACE SYSTEM. CIRCUIT BREAKER SIZE 12XL2-CT, 208 VOLT, TRANSFORMER LOAD= 3.5KW. CONTRACTOR MUST FOLLOW MANUFACTURER INSTALLATION INSTRUCTION. COORDINATE WITH ELECTRICAL.
- EXTEND GREASE WASTE PIPING FROM EXISTING FLOOR DRAIN TO NEW WALL. RELOCATE VENT PIPING UP IN WALL AND CONNECT TO EXISTING VENT PIPING. REPAIR/REPLACE PIPING AS NEEDED.

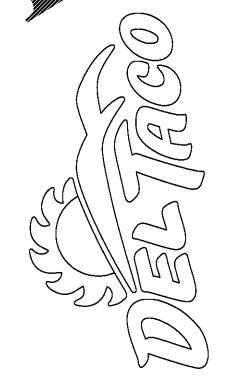

DO NOT SCALE DRAWINGS
CONTRACTOR TO VERIFY
ALL EXISTING CONDITIONS AND
DIMENSIONS-NOTIFY ARCHITECT
OF ANY DISCREPANCIES PRIOR
TO BEGINNING CONSTRUCTION



NO REVISION

DEL TACO STORE # DT2017
4525 JIMMY LEE SMITH PARKWAY
HIRAM, GA 30141
PAULTON COUNTY
1ST PERMIT SUBMITTAL 05-18-18
1ST BID SUBMITTAL 07-05-18

PROJECT NUMBER
2180148

SHEET NAME
**PLUMBING
WASTE & VENT
FLOOR PLAN**

SHEET NUMBER
P101

DATE OF THIS PRINTING - 7/3/2018

Order Plans @

WWW.LDILLING.COM