

Owner  
 SHOP STORE PROPERTIES  
 1077 Fellowship Road, Suite 116  
 Mount Laurel, NJ 08054  
 Telephone (856) 780-4460  
 Fax

Architect  
 SBLM Architects  
 11430 N. Kendall Drive, Suite 310  
 Miami, FL 33176  
 Telephone 305 412 9187  
 Fax 305 412 6731  
 www.sblm.com

Consultants  
 Civil  
 Langan Engineering

Structural  
 Bliss & Nyitray, Inc.  
 Electrical/Mechanical/Plumbing  
 B&K Engineering Group

Revisions/Issues

06/21/18 PERMIT SET

Key Plan



Seal

James L. Cohen AR0015903

Project Title  
 SOUTHERN PALM CROSSING  
 BUILDING SHELL  
 11001-11161 Southern Blvd.  
 Royal Palm Beach, FL. 33411

Job Number 017512.00


Drawing  
 FIRE ALARM PLAN

Scale AS SHOWN  
 Drawing Date 05/16/18

Drawing No.

FA1.1

Sheet Of

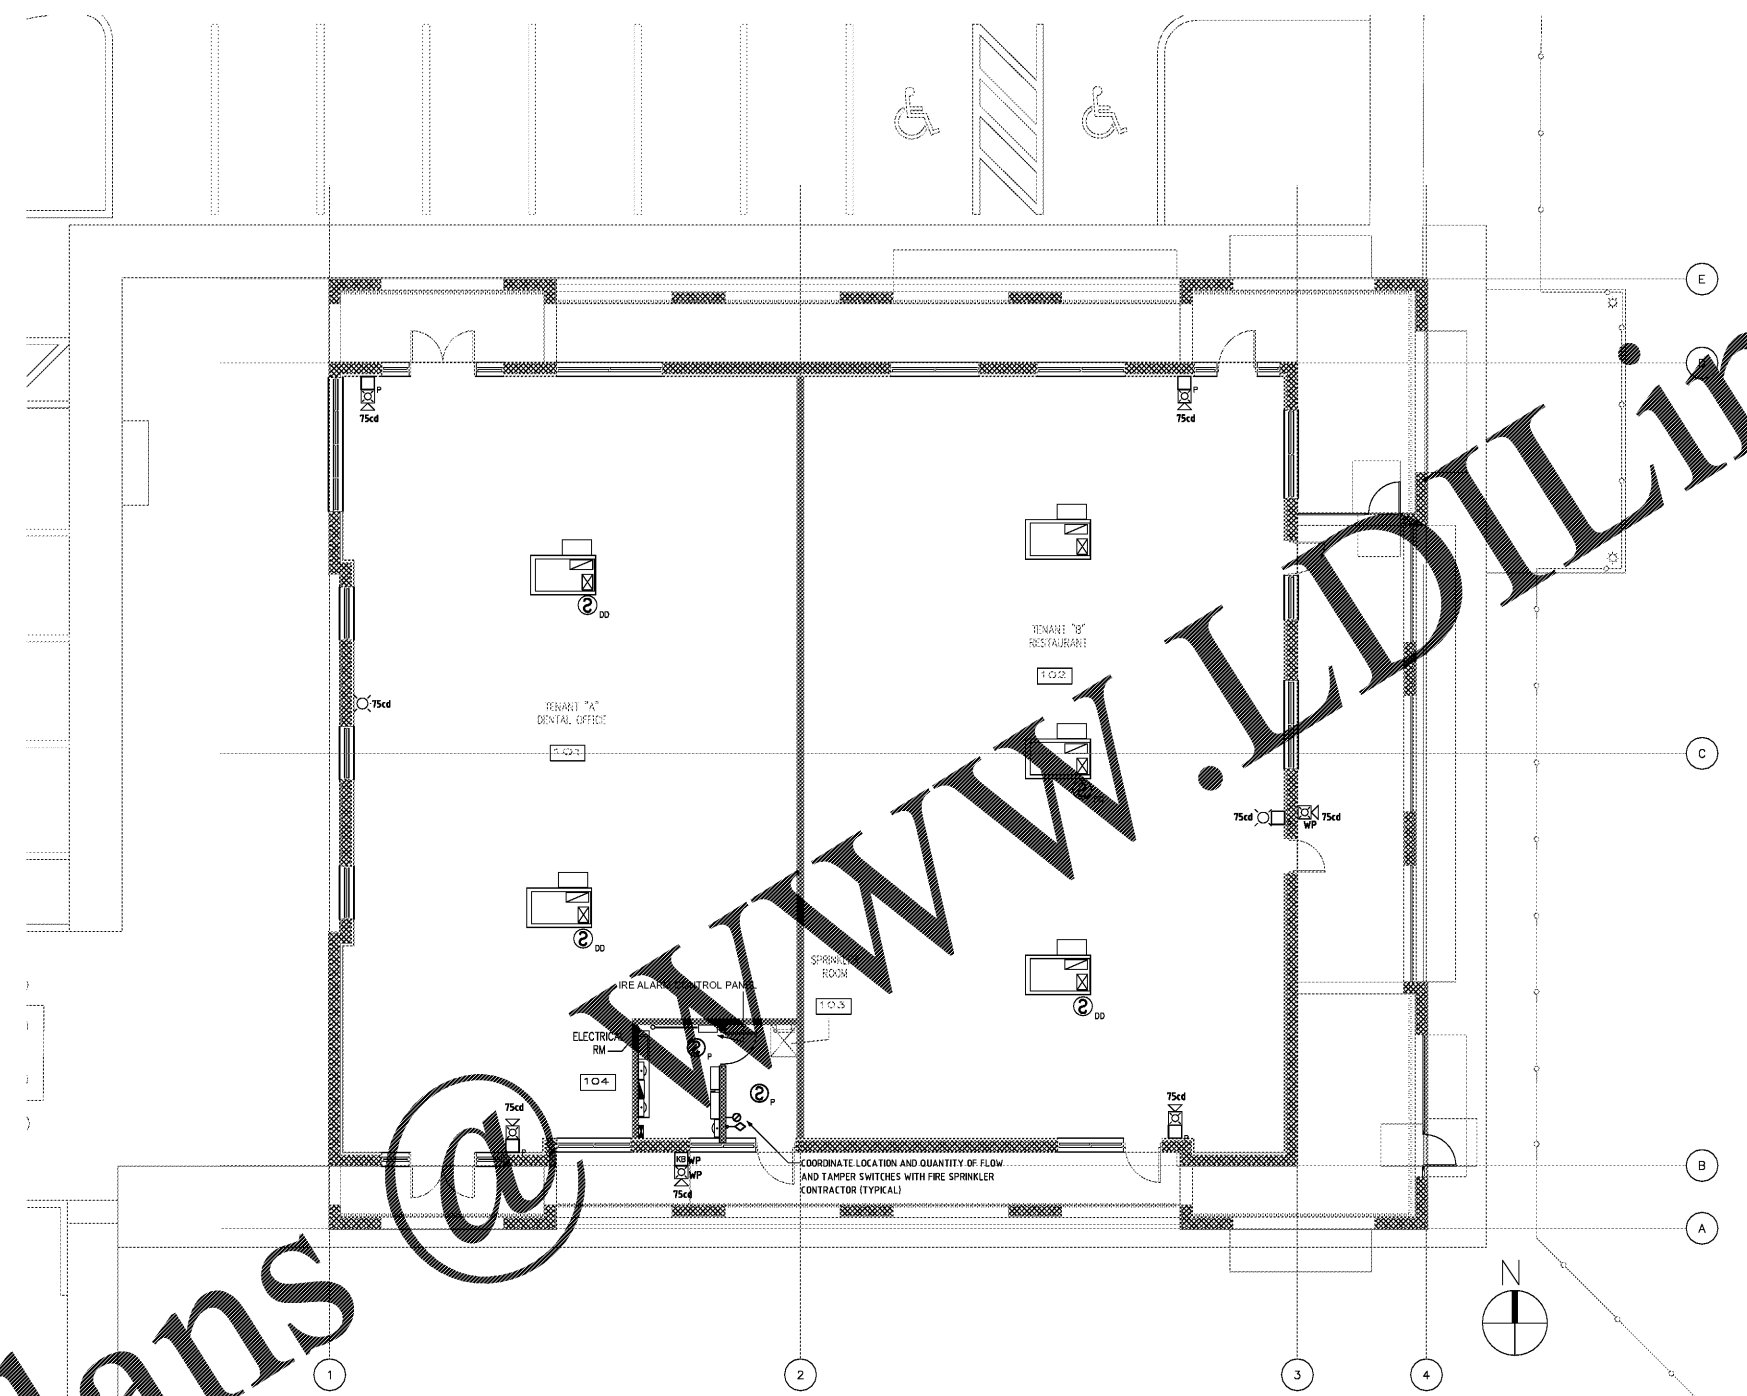

1 FIRE ALARM PLAN  
 SCALE: 1/8" = 1'-0"

06/21/2018  
 DATE

2701 NW BOCA RATON BLVD  
 SUITE 100  
 BOCA RATON, FL 33431

MECH DEPT.  
 TEL: 561-7716-7120  
 ELEC DEPT.  
 TEL: 954-644-9612

CERTIFICATION OF AUTHORIZATION  
 NO. 21929

**B**  
 B&K Engineering Group

PRIOR TO SUBMITTING THE BID, THE CONTRACTOR SHALL FIELD VERIFY ALL EXISTING CONDITIONS AND INFORM THE ARCHITECT AND THE ENGINEER OF ANY DISCREPANCY BETWEEN THESE CONDITIONS AND THE EXISTING CONDITIONS AND SHALL INCLUDE IN THE BID TO CORRECT THE SAME AS DIRECTED. THE ENGINEER IS NOT RESPONSIBLE FOR ANY ADDITIONAL COSTS RESULTING FROM VERIFIABLE EXISTING CONDITIONS DISCOVERED AFTER CONTRACT HAS BEEN AWARDED. NO CHANGES SHALL BE MADE TO THESE PLANS WITHOUT PRIOR APPROVAL FROM THE ENGINEER OF RECORD. ALL CHANGES SHALL BE SUBMITTED FOR REVIEW PRIOR TO INSTALLATION. NOT FOR CONSTRUCTION.

Order Plans