


# Order Plans @ [www.dlLine.com](http://www.dlLine.com)

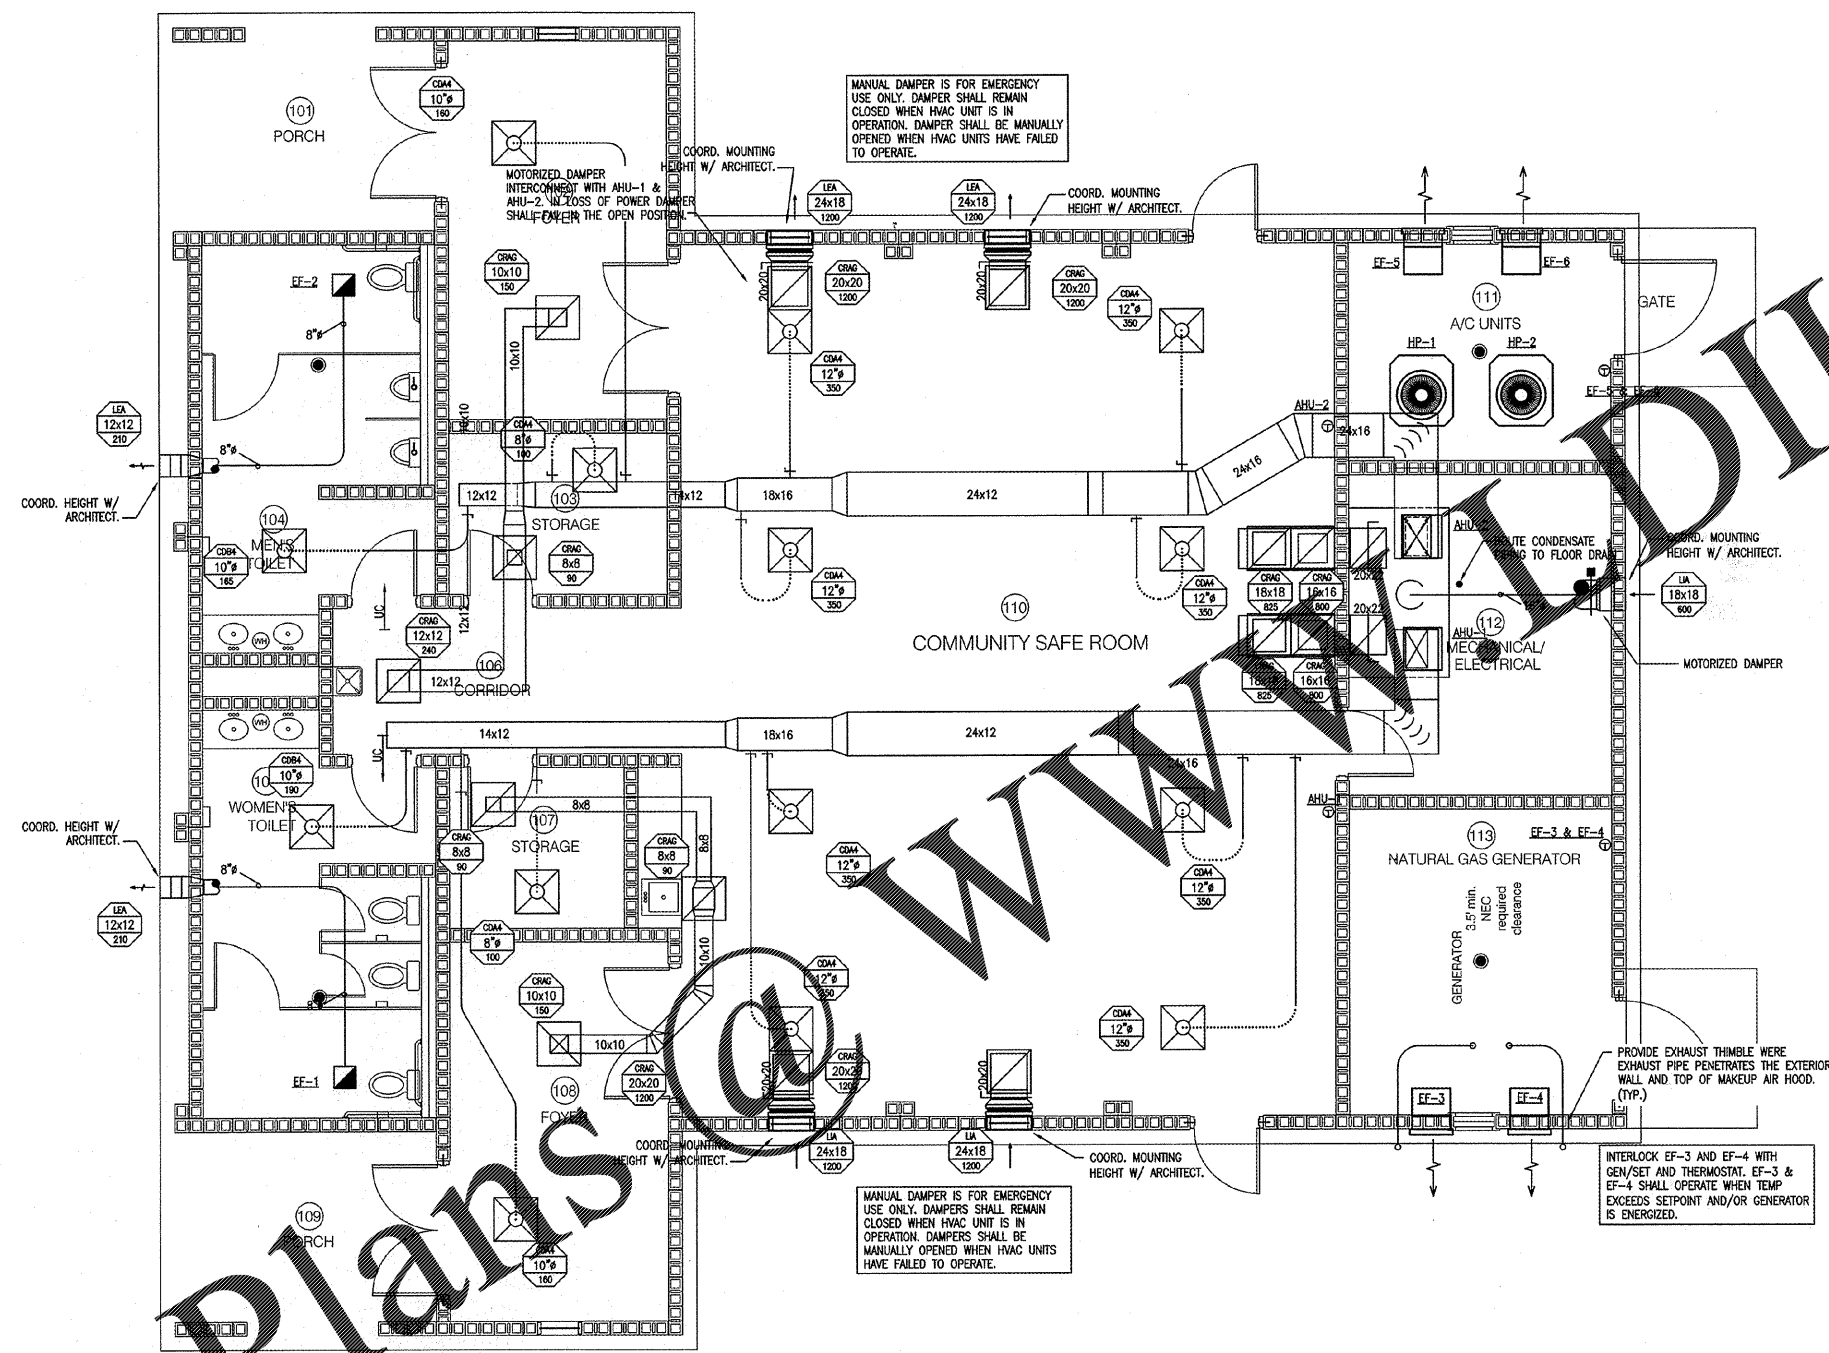

**1 HVAC PLAN**  
 M101 1/4" = 1' - 0"

**SENTLELL**  
 ENGINEERING - SURVEYING  
 CIVIL - STRUCTURAL - ENVIRONMENTAL  
 639 Brock Bears Way Phone (205) 752-5564  
 Tuscaloosa, AL 35401 www.sentlell.net



**JEFFERSON COUNTY**  
 FULLTONDALE STORM SHELTER  
 FULLTONDALE, ALABAMA

NO.	DESCRIPTION:

DATE: 12-20-17  
 JOB NO: 15-211  
 SHEET: **M101**

**ROBBINS**  
 Engineering Company, LLC  
 Mechanical & Electrical  
 5545 Knight Ave, Suite B Tuscaloosa, Alabama 35405  
 Phone (205) 591-7065  
 http://www.robbinsllc.com  
 REC Project 17016

VERIFY SCALES  
 1/4" = 1' - 0"  
 IF NOT ONE INCH  
 ON THIS SHEET  
 ADJUST SCALE  
 ACCORDENTLY