


Order Plans @ WWW.LDLine.com

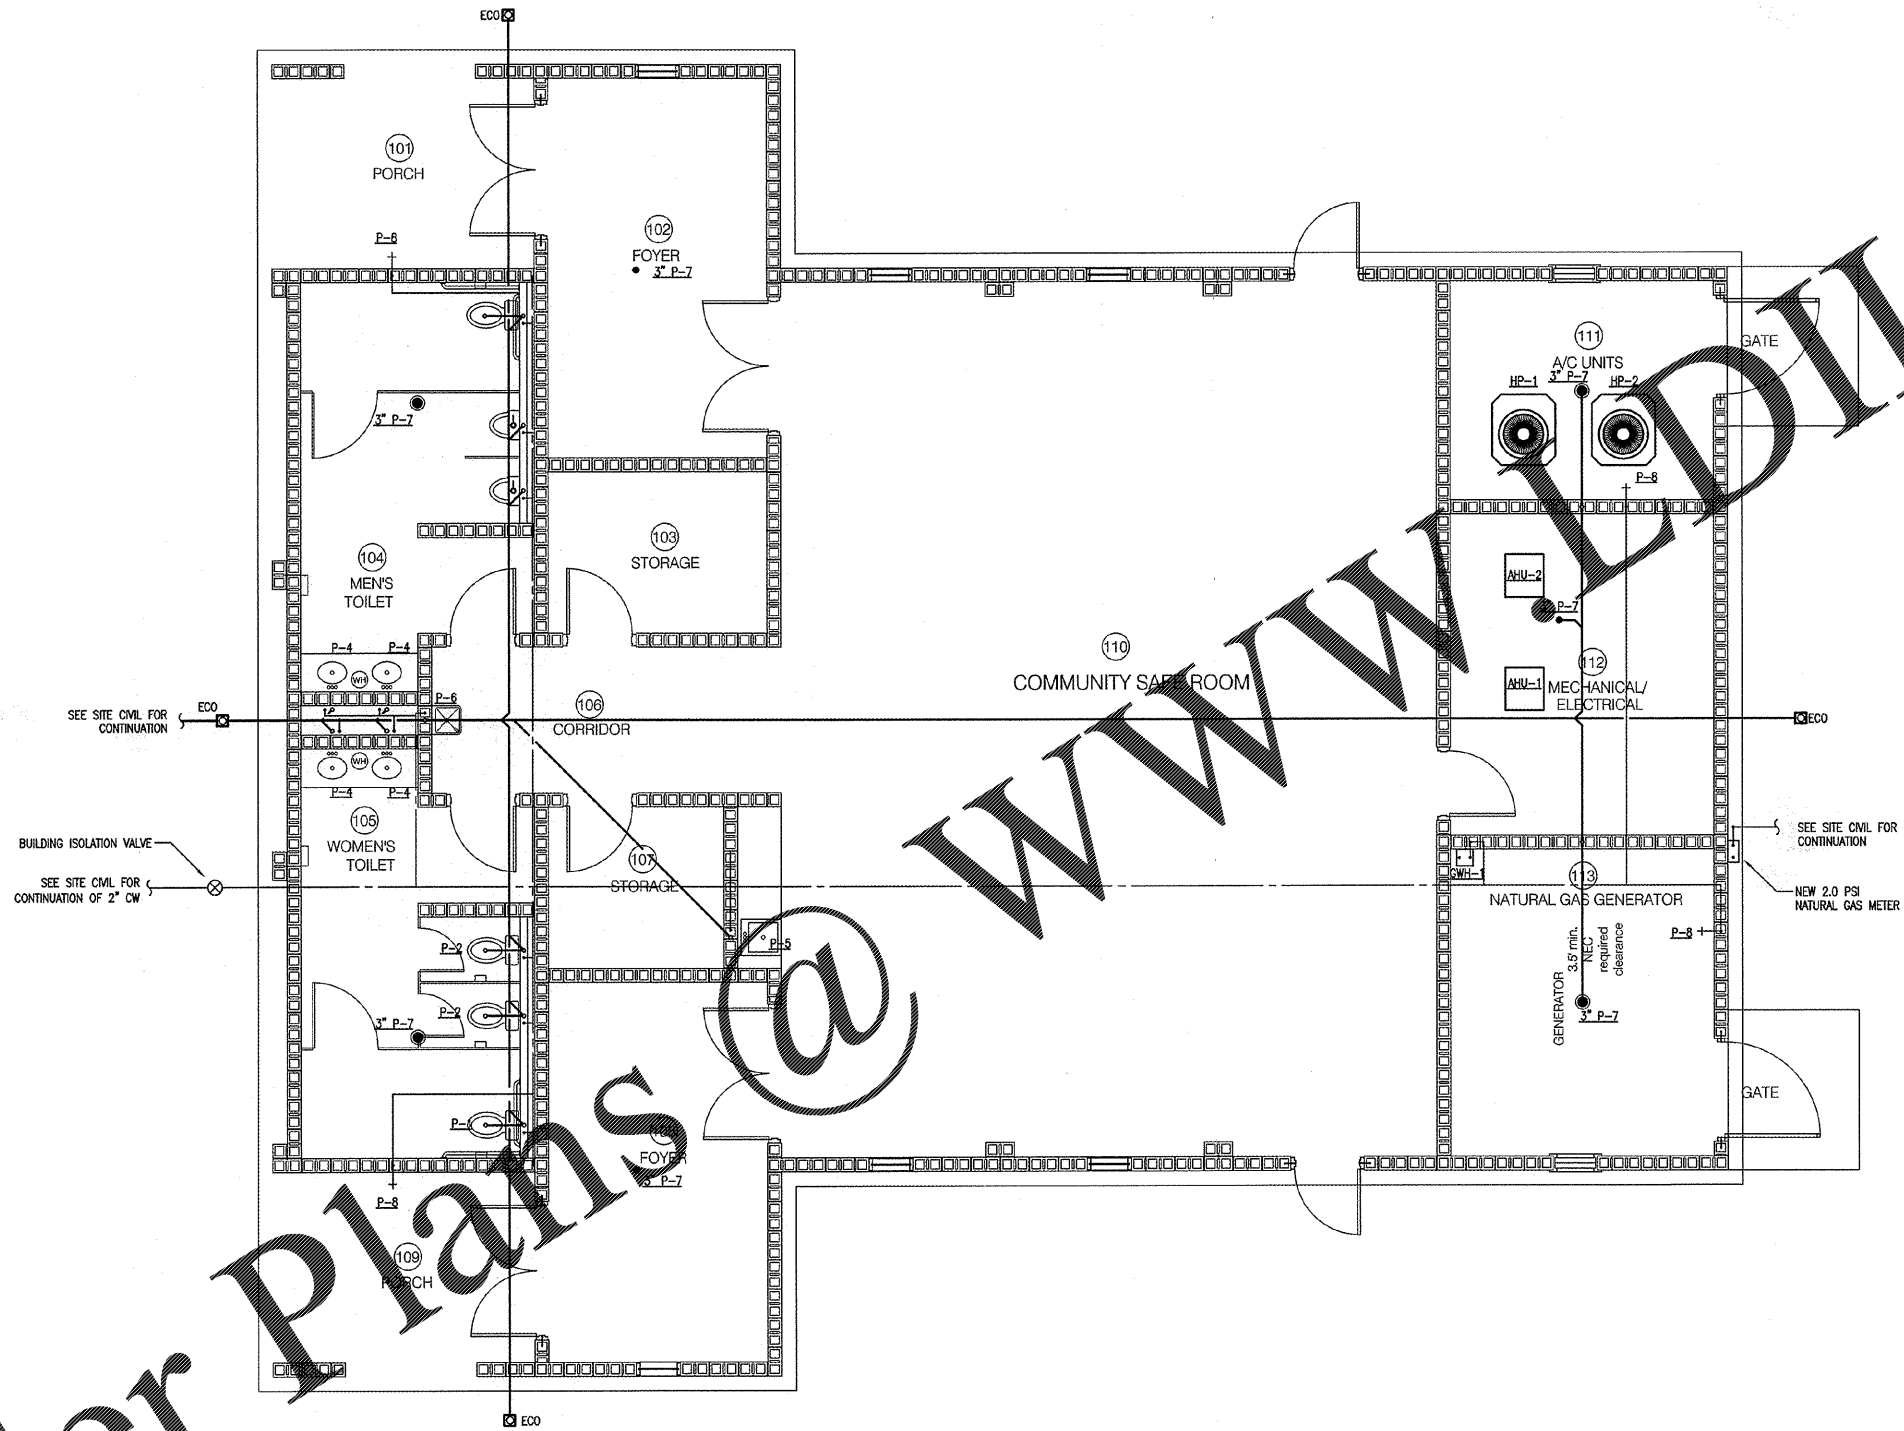

**1 UNDERGROUND PLUMBING PLAN**  
**P101 1/4" = 1' - 0"**



**SENTTELL**  
 ENGINEERING SURVEYING  
 CIVIL · STRUCTURAL · ENVIRONMENTAL · SURVEYING  
 639 Black Bears Way Phone (205) 752-5664  
 Tuscaloosa, AL 35401 www.senttell.net



**JEFFERSON COUNTY**  
 FULTONDALE STORM SHELTER  
 FULTONDALE, ALABAMA

NO.	DESCRIPTION:
DATE:	
NO.	UNDERGROUND PLUMBING PLAN
DATE:	12-20-17
JOB NO.:	15-211
SHEET:	P101

**ROBBINS**  
 Engineering Company, LLC  
 Mechanical & Electrical  
 5945 Knight Ave, Suite B, Tuscaloosa, Alabama 35405  
 Phone: (205) 591-7065  
 http://www.ro-engineers.com REC Project# 17016

VERIFY SCALES  
 BAR IS ONE INCH  
 ON ORIGINAL DWG.  
 IF NOT ONE INCH  
 ON THIS SHEET  
 ADJUST SCALE  
 ACCORDINGLY