

CONTRACT DRAWINGS
06.07.18

RENOVATIONS, MODIFICATIONS, & ADDITIONS TO HENRY COUNTY SCHOOLS - GROUP 10 WOODLAND ELEMENTARY SCHOOL (ITEM A)

830 N. MOSELEY DRIVE, STOCKBRIDGE, GA 30281

LOCAL EFFORT

CLIENT:
HENRY COUNTY BOARD OF EDUCATION

ARCHITECT:
MANLEY SPANGLER SMITH ARCHITECTS
525 EAST TAYLOR STREET
GRIFFIN, GA 30224
770-227-5473


CIVIL ENGINEER:
CARTER ENGINEERING GROUP
6310 WEAKE ROAD, SUITE 200
MACON, GA 31210
478-777-3923

MECHANICAL, PLUMBING & ELECTRICAL:
ANDREWS, HAMMOCK & POWELL
250 CHARTER LANE, SUITE 100
MACON, GA 31210
478-405-8301

INDEX OF DRAWINGS

COVER	COVER SHEET	PLUMBING	ELECTRICAL
PH1.1 PHASING PLAN	D1.21 DEMOLITION PLAN - SECTOR "A"	PI.01 OVERALL PLUMBING FLOOR PLAN AND LARGE SCALE FLOOR PLANS	E001 ELECTRICAL OVERALL DEMOLITION PLAN
D1.22 DEMOLITION PLAN - SECTOR "B"	D1.23 DEMOLITION PLAN - SECTOR "C"		E002 ELECTRICAL SITE PLAN
D1.24 DEMOLITION PLAN - SECTOR "D"	A1.11 FLOOR PLAN		E101 ELECTRICAL NEW WORK LIGHTING FLOOR PLAN - SECTOR "A"
A1.12 FLOOR PLAN - SECTOR "A"	A1.22 FLOOR PLAN - SECTOR "B"		E102 ELECTRICAL NEW WORK LIGHTING FLOOR PLAN - SECTOR "B"
A1.23 FLOOR PLAN - SECTOR "C"	A1.24 FLOOR PLAN - SECTOR "D" & FINISH NOTES		E103 ELECTRICAL NEW WORK LIGHTING FLOOR PLAN - SECTOR "C"
A1.41 MISCELLANEOUS PLAN DETAILS			E104 ELECTRICAL NEW WORK LIGHTING FLOOR PLAN - SECTOR "D"
			E201 ELECTRICAL NEW WORK POWER FLOOR PLAN - SECTOR "A"
			E202 ELECTRICAL NEW WORK POWER FLOOR PLAN - SECTOR "B"
			E203 ELECTRICAL NEW WORK POWER FLOOR PLAN - SECTOR "C"
			E204 ELECTRICAL NEW WORK POWER FLOOR PLAN - SECTOR "D"
			E301 ELECTRICAL NEW WORK LOW VOLTAGE FLOOR PLAN - SECTOR "A"
			E302 ELECTRICAL NEW WORK LOW VOLTAGE FLOOR PLAN - SECTOR "B"
			E303 ELECTRICAL NEW WORK LOW VOLTAGE FLOOR PLAN - SECTOR "C"
			E304 ELECTRICAL NEW WORK LOW VOLTAGE FLOOR PLAN - SECTOR "D"
			E601 ELECTRICAL DETAILS
			E801 ELECTRICAL LEGEND AND SCHEDULES

SYMBOL LEGEND

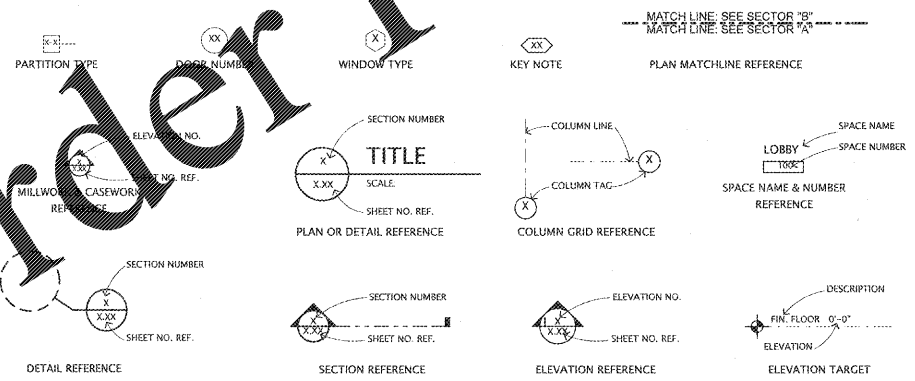

PROJECT DATA

GRADE RANGE:	K-5
INSTRUCTIONAL UNITS:	57
F.T.E.:	887
SCHOOL CODE NO.:	675-0108
BLDG USE:	ELEMENTARY SCHOOL
OCC. GROUP:	EDUCATIONAL
CONST. TYPE:	I-B FULLY SPRINKLERED
BUILDING AREA:	99,151
EXT. COVERED (500):	3,922
TOTAL:	99,073

GENERAL NOTES

1. 24 HOUR CONTACT:
HENRY COUNTY SCHOOLS, 396 TOMLINSON STREET, MCDONOUGH, GA 30253
MR. JOSH MALCOM, 770-937-1891


NEW WORK BASED ON THE BELOW APPLICABLE CODES WITH GEORGIA AMENDMENTS:
International Building Code 2012 edition
International Gas Code 2012 edition
International Plumbing Code 2012 edition
International Mechanical Code 2012 edition
National Electrical Code 2017 edition
International Fire Code 2012 edition
International Energy Code 2009 edition
NFPA 101 2012 edition
2010 ADA Standards for Accessible Design

FIRE MARSHAL CERTIFICATION

The Local Fire Official having jurisdiction has reviewed and approved a set of documents identical to this set of documents on _____


(Signed) _____ Architect

SITE MAP

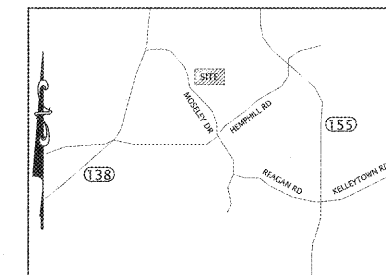

REVISIONS/ISSUANCES		
NO.	DATE	DESCRIPTION

KEYPLAN

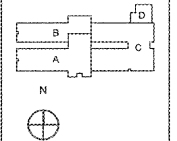

Manley Spangler Smith Architects
A Professional Corporation

525 East Taylor St.
P.O. Box 886
Griffin, Georgia 30224
Office 770.227.5473
Fax 770.228.3442

PROJECT:
RENOVATIONS, MODIFICATIONS, & ADDITIONS TO HENRY COUNTY SCHOOLS - GROUP 10 WOODLAND ELEMENTARY SCHOOL (ITEM A)
CLIENT:
HENRY COUNTY BOARD OF EDUCATION

SHEET TITLE:
COVER SHEET

DATE: 06/07/18
SCALE: AS NOTED
DRAWN BY: JS
CHECKED BY: RV

SHEET NO.:
COVER

Order Plans @

WWW.LDILine.com