


Order Plans

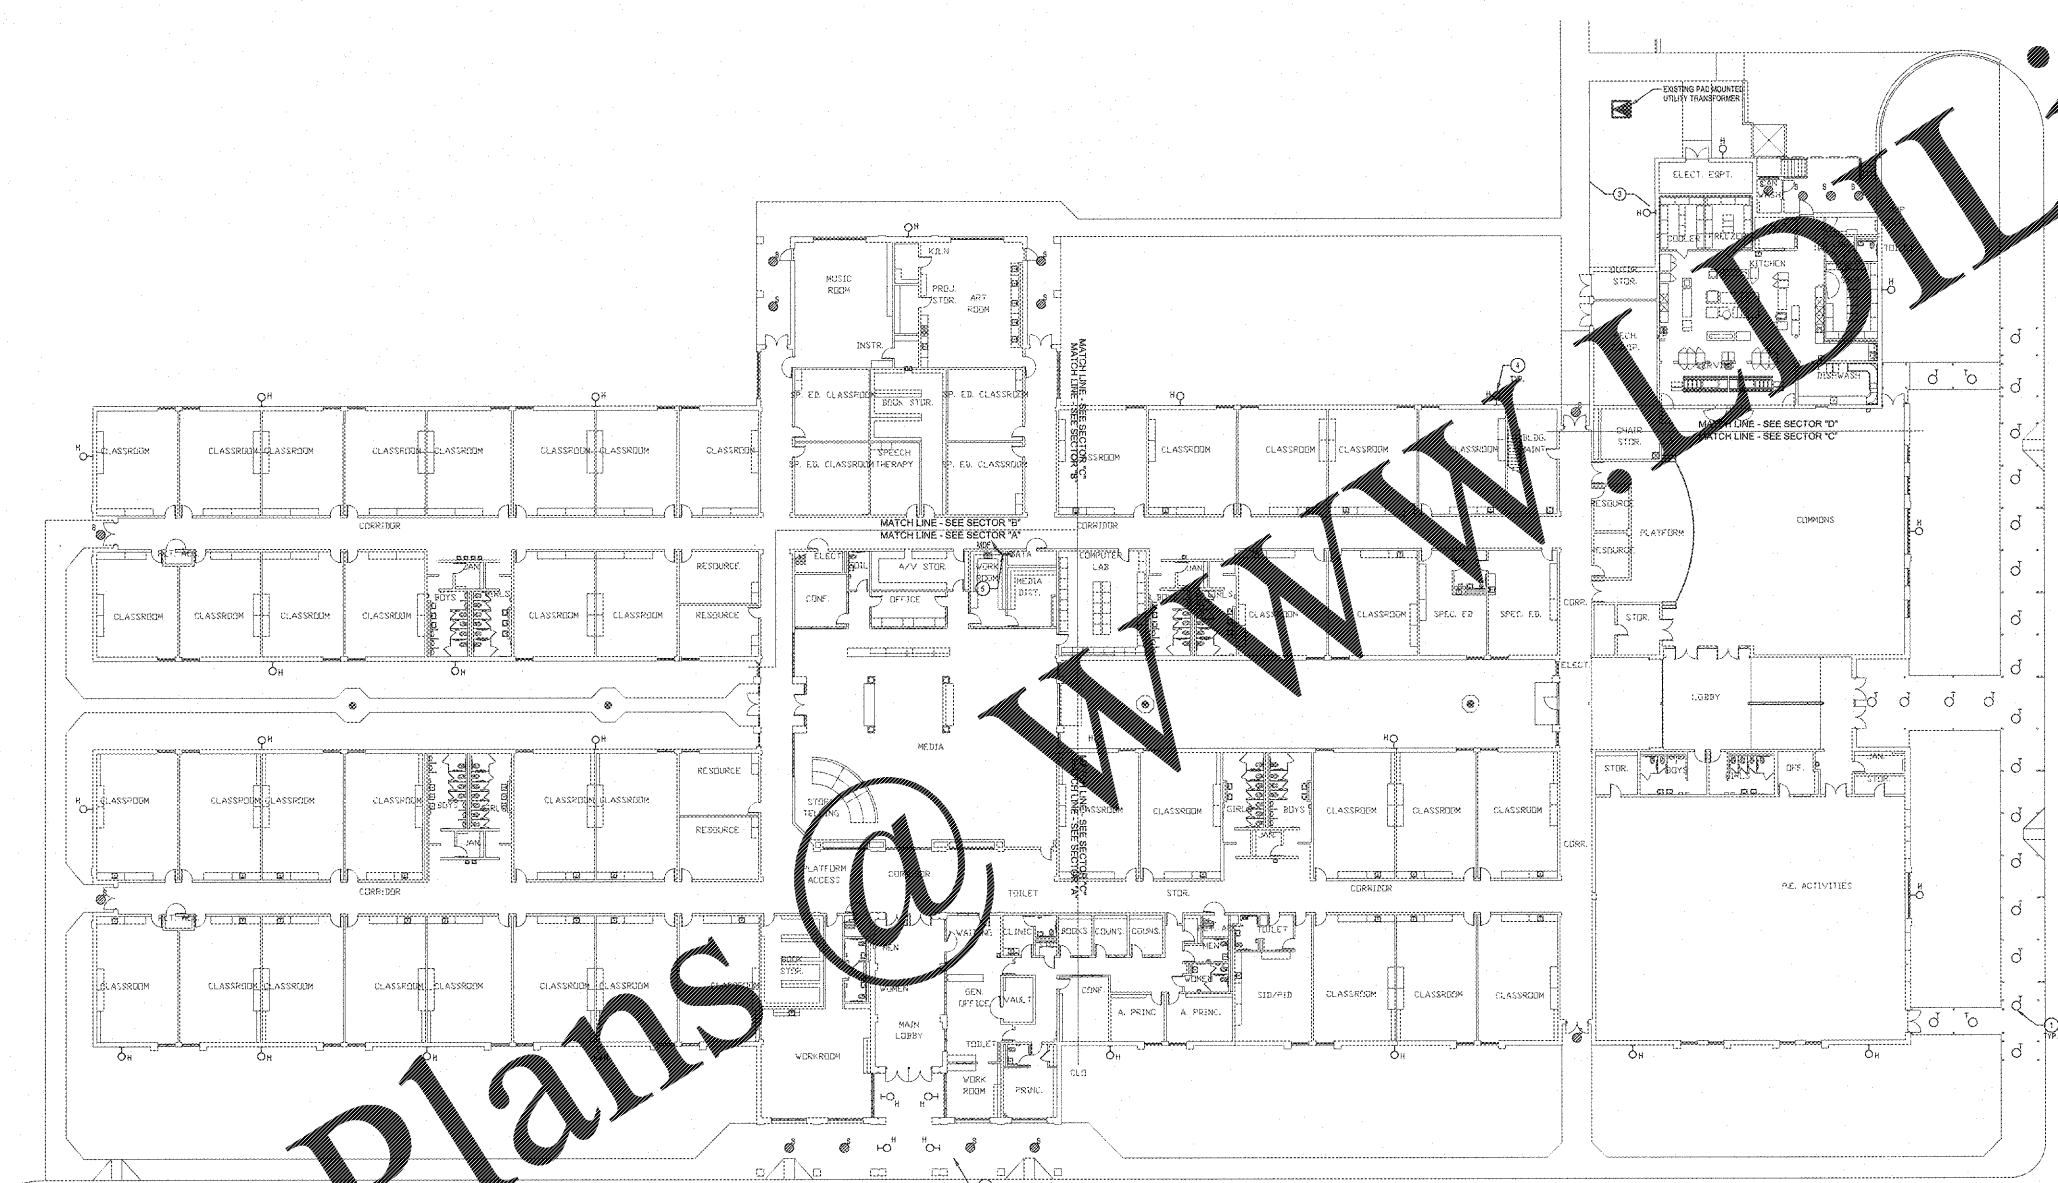

ELECTRICAL SITE PLAN
SCALE: 1"=20'

- LEGEND: SITE PLAN**
- LJE -- NEW UNDERGROUND PRIMARY PROVIDED BY UTILITY COMPANY
 - AE -- NEW AERIAL PRIMARY CABLE OF POWER UTILITY
 - UNDERGROUND CIRCUIT
 - PUB MOUNTED UTILITY TRANSFORMER
 - STOP-UPS OR CAPED AND BURIED
 - UTILITY SERVICE PILES

NOTE: UTILITY COMPANY SHALL DEVELOP SITE LIGHTING PROPOSAL, INCLUDING A POINT-BY-POINT FOOT CANDLE ANALYSIS. PROPOSAL SHALL BE SUBMITTED TO OWNER FOR HIS REVIEW AND ACCEPTANCE.


NOTE TO CONTRACTOR CONCERNING PROJECT PHASING:

THE WORK SPECIFIED ON THE DRAWINGS AND SPECIFICATIONS ILLUSTRATES THE COMPLETED CONTRACTUAL REQUIREMENTS. THIS PROJECT IS PHASED IN MULTIPLE PHASES. THE AREA OF EACH PHASE IS DESCRIBED IN THE ARCHITECTURAL DOCUMENTS AND THE CONTRACTOR SHALL REVIEW THESE PHASING REQUIREMENTS. CONTRACTOR SHALL INCLUDE IN HIS BID ALL COSTS REQUIRED TO ACCOMPLISH THE CONTRACT IN PHASES. THE CONTRACT DOCUMENTS DO NOT DESCRIBE THE SPECIFIC WORK REQUIRED BY THE CONTRACTOR TO PERFORM THE PROJECT IN PHASES, BUT CONTRACTOR SHALL PREPARE PHASING PLAN AND SUBMIT TO ARCHITECT/ENGINEER AND HENRY COUNTY MAINTENANCE DEPARTMENT PRIOR TO BEGINNING WORK.

NOTES: (THIS SHEET ONLY)

1. BUS CANOPY LIGHT FIXTURES ARE APPROX. 19' ON CENTER, CENTERED WITHIN COLUMN BAYS AS SHOWN. INSTALL NEW FIXTURES IN EXISTING LOCATIONS. EXTEND CIRCUITS AND RACEWAYS WITH RIGID CONDUITS IN 1" COORD. 1/2"
2. RECESSED FIXTURE LOCATED IN COVERED ENTRY. PATCH AND PAINT EXISTING PLASTER CEILING TO MATCH EXISTING.
3. COORDINATE INSTALLATION OF UNDERGROUND ELECTRICAL SERVICES WITH BOTH GAS AND WATER UTILITIES TO AVOID CONFLICTS AND MINIMIZE DISTURBANCE.
4. INSTALL NEW FIXTURES IN EXISTING LOCATIONS. EXTEND CIRCUITS AND RACEWAYS WITH RIGID CONDUITS IN 1" COORD. 1/2"
5. ROUTE TWO 3" CONDUITS FROM EXISTING TELEPHONE AND COMMUNICATION FIBER OPTIC ENTRANCE LOCATION TO NEW RAMP BACKBOARD LOCATION. ROUTE CONDUITS CONCEALED ABOVE ACCESSIBLE CEILING.
6. GENERAL: COORDINATE WITH THE UTILITY COMPANY TO REPLACE EXISTING POLE MOUNTED SITE LIGHTING. THE EXISTING SITE LIGHTING FIXTURES ARE BEING LEASED BY THE OWNER.

REVISIONS/ISSUANCES		
NO.	DATE	DESCRIPTION

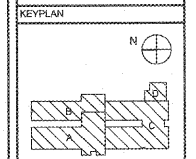

AH&P
CONSULTING ENGINEERS
ANDREWS, HAMMOCK & POWELL, INC.
250 Charter Lane
Suite 100
Macon, Georgia 31210
Macon (478) 405-8301
FAX (478) 405-8210
WWW.AHPENGR.COM



Manley Spangler Smith Architects
A Professional Corporation

525 East Taylor St.
P.O. Box 880
Oxford, Georgia 30224
Office 770.227.3473
Fax 770.226.3442

PROJECT: RENOVATIONS, MODIFICATIONS, & ADDITIONS TO HENRY COUNTY SCHOOLS - GROUP 10 WOODLAND ELEMENTARY SCHOOL (ITEM A)

CLIENT: HENRY COUNTY BOARD OF EDUCATION

SHEET TITLE: ELECTRICAL SITE PLAN

1.1 - 55
F.T.E. - 875
FACILITY CODE: 075-0108
© 2018 Manley Spangler Smith Architects, PC
PROJECT NUMBER: 2017151A
DATE: 06.07.18
SCALE: AS SHOWN
DRAWN BY: CTS
CHECKED BY: NHO
SHEET NO.: E001