


NO.	DATE	DESCRIPTION

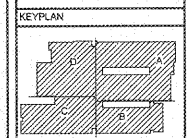

AH&P
CONSULTING
ENGINEERS
ANDREWS, HAMBROCK & POWELL, INC.
250 Charter Lane
Suite 100
Macon, Georgia 31210
Macon (478) 405-9351
FAX (478) 405-8218
WWW.AHPENGR.COM



Manley Spangler Smith Architects
A Professional Corporation

528 East Taylor St.
P.O. Box 880
Covington, Georgia 30224
Office 770.227.5473
Fax 770.228.3462


PROJECT:
RENOVATIONS,
MODIFICATIONS, &
ADDITIONS TO HENRY
COUNTY SCHOOLS -
GROUP 10
WOODLAND MIDDLE
SCHOOL (ITEM 5)

CLIENT:
HENRY COUNTY
BOARD OF EDUCATION

SHEET TITLE:
OVERALL
PLUMBING FLOOR
PLAN AND LARGE
SCALE FLOOR
PLANS

LU: ST
P.T.S.: 800
FACILITY CODE: 677-0008
© 2018 Manley Spangler Smith Architects, PC
PROJECT NUMBER: 2017318
DATE: 08.07.18
SCALE: AS SHOWN
DRAWN BY: JMC
CHECKED BY: JMC

SHEET NO.:
P101

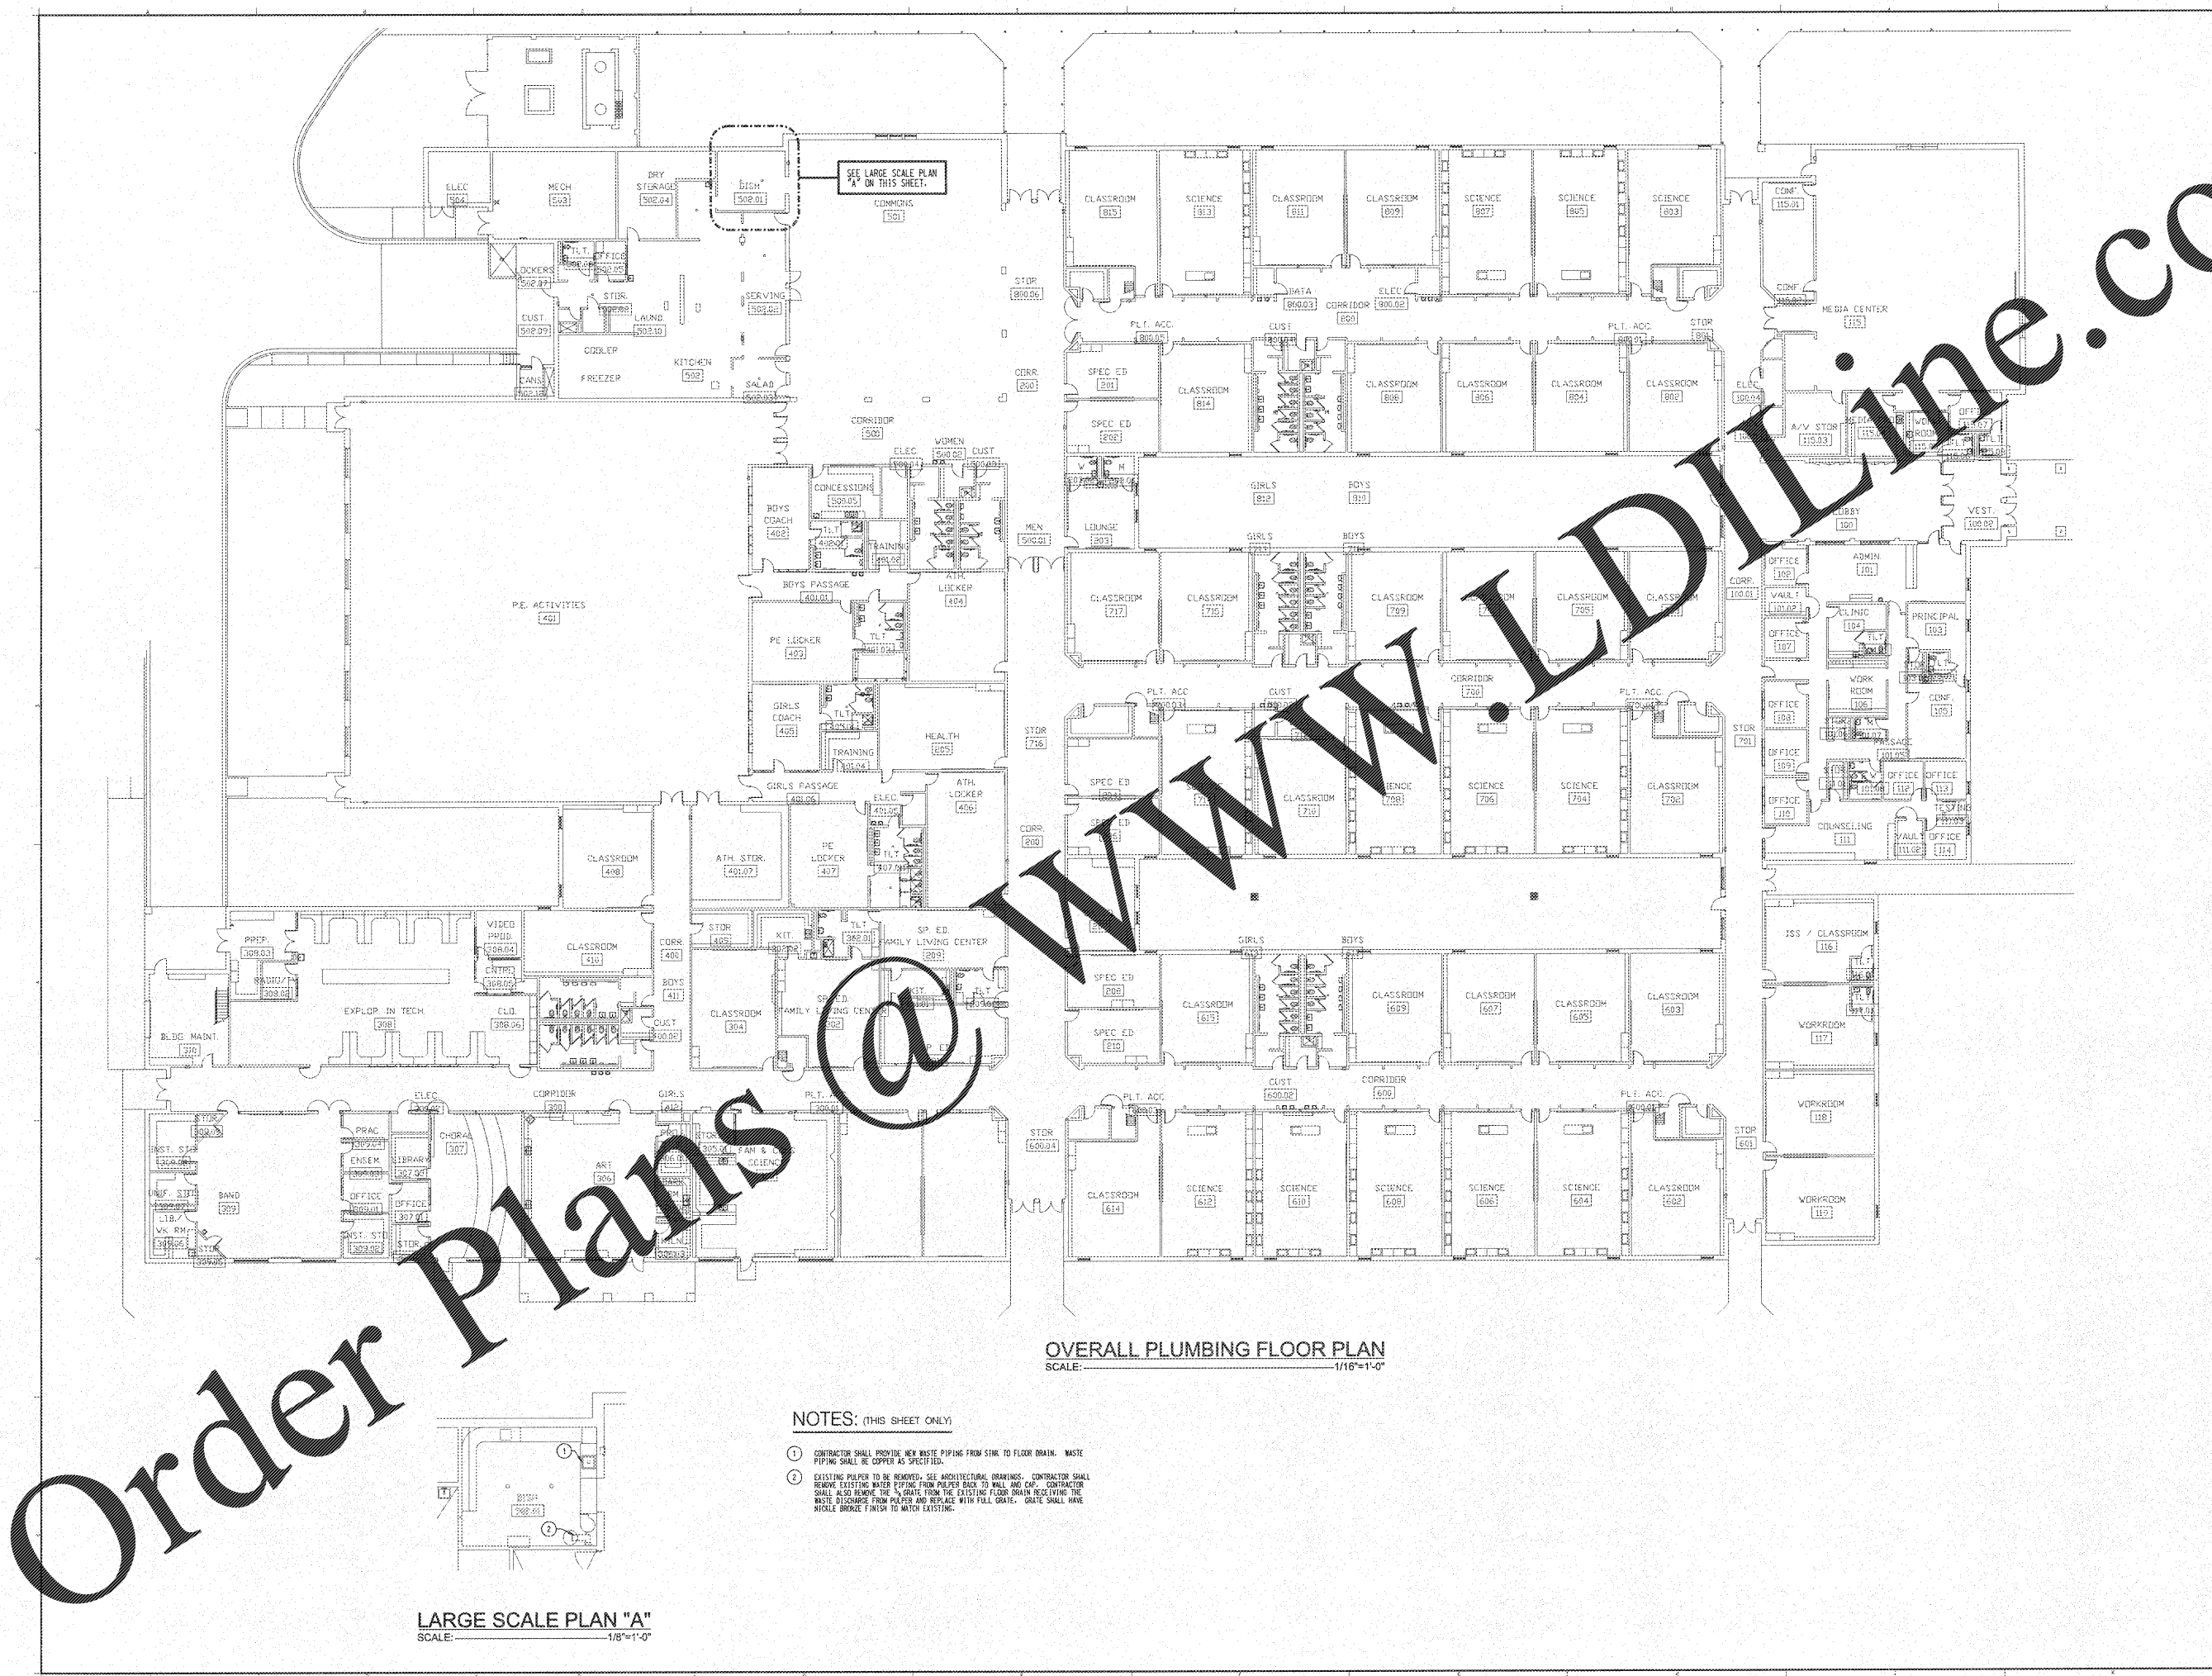

OVERALL PLUMBING FLOOR PLAN
SCALE: 1/16"=1'-0"

NOTES: (THIS SHEET ONLY)

- CONTRACTOR SHALL PROVIDE NEW WASTE PIPING FROM SINK TO FLOOR DRAIN. WASTE PIPING SHALL BE COPPER AS SPECIFIED.
- EXISTING WALKER TO BE REMOVED. SEE ARCHITECTURAL DRAWINGS. CONTRACTOR SHALL REMOVE EXISTING WATER PIPING FROM PULPER BACK TO WALL AND CAP. CONTRACTOR SHALL ALSO REMOVE THE 1/2" GRATE FROM THE EXISTING FLOOR DRAIN RECEIVING THE WASTE ALONGSIDE FROM PLACER AND REPLACE WITH FULL GRATE. GRATE SHALL HAVE NICOLE BRONZE FINISH TO MATCH EXISTING.

LARGE SCALE PLAN "A"
SCALE: 1/8"=1'-0"

Order Plans @