

**Manley Spangler Smith Architects**  
A Professional Corporation


525 East Taylor St.  
P.O. Box 960  
Gresham, Georgia 30224  
Office 770.227.5473  
Fax 770.228.3442

PROJECT:  
**RENOVATIONS, MODIFICATIONS, & ADDITIONS TO HENRY COUNTY SCHOOLS - GROUP 10 WOODLAND HIGH SCHOOL (ITEM C)**  
CLIENT:  
**HENRY COUNTY BOARD OF EDUCATION**

SHEET TITLE:  
**REFLECTED CEILING PLAN - SECTOR "B"**

CU: 87  
P.T.E.: 1,687  
FACILITY CODE: 675-0405  
© 2016 Manley Spangler Smith Architects, PC  
PROJECT NUMBER: 201731C  
DATE: 06/27/18  
SCALE: AS NOTED  
DRAWN BY: JS  
CHECKED BY: RV

SHEET NO.:  
**A7.21B**

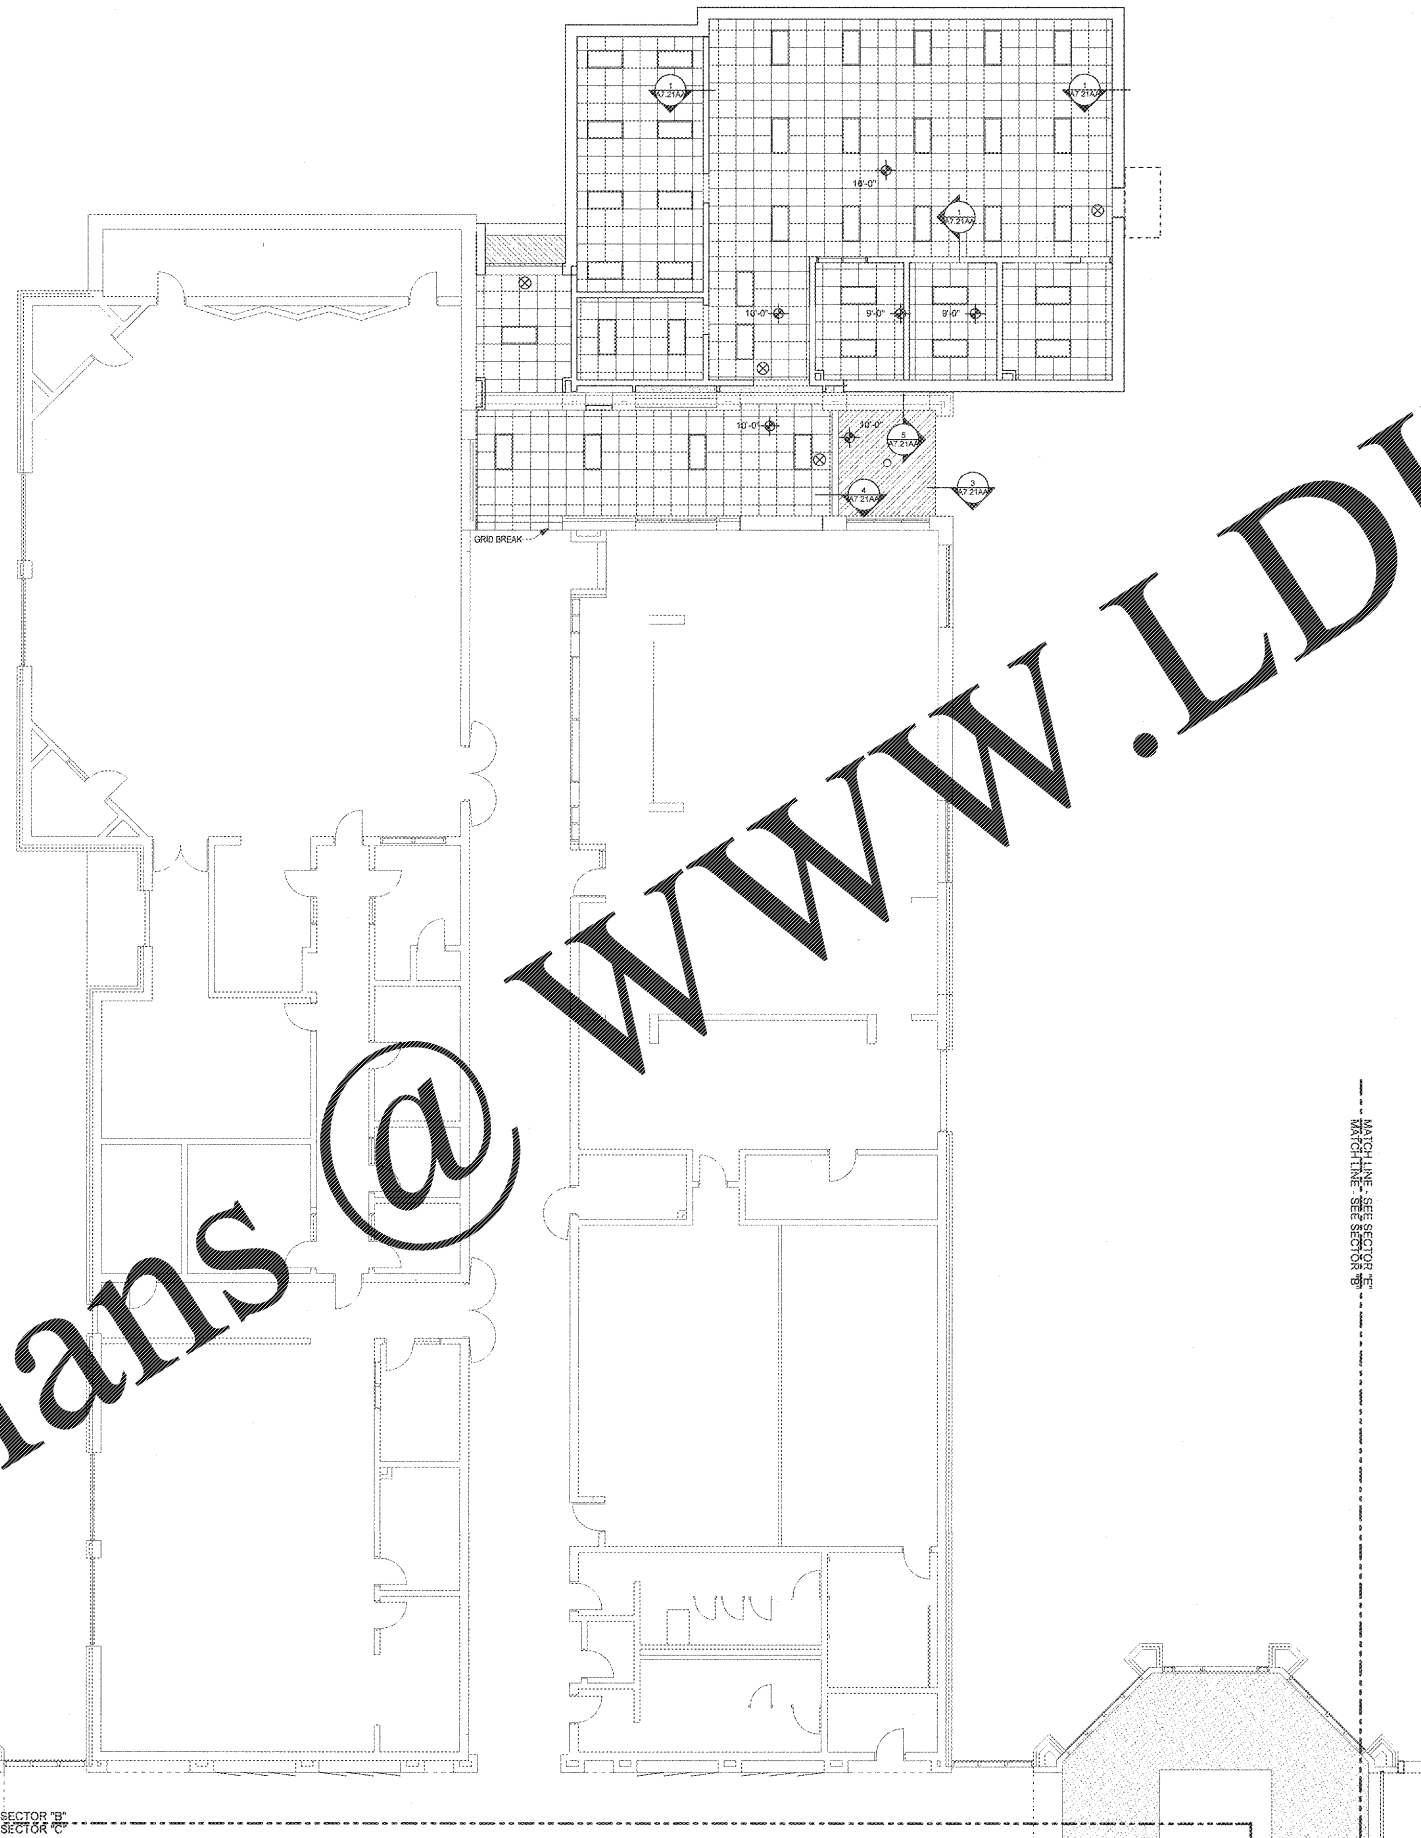

**LEGEND:**

	INDICATES CEILING HEIGHT
	NEW 2' x 2' ACOUSTICAL CEILING PANELS IN NEW GRID
	NEW D.E.F.S. SOFFIT SYSTEM
	NEW CEMENT PLASTER CEILING
	NEW GYPSUM BOARD CEILING IN SECTORS AA, A, B, & C. EXT. GYP. BO. TO BE PAINTED IN ALL OTHER SECTORS.
	NEW 2' x 4' FL. LIGHT FIXTURES IN SECTORS AA, A, B, & C WHERE NEW GRID IS INDICATED. EXT. FIXTURES IN ALL OTHER SECTORS.
	EXIST. 1' x 4' SURFACE MTD. FL. LIGHT FIXTURE
	NEW 1' x 4' FL. LIGHT FIXTURE IN SECTORS AA, A, B, & C WHERE NEW GRID IS INDICATED. EXT. FIXTURES IN ALL OTHER SECTORS.
	NEW EXT. SIGN IN SECTORS AA, A, B, & C WHERE NEW WORK IS INDICATED. EXT. SIGNS IN ALL OTHER SECTORS.
	NEW RECESSED DOWNLIGHT IN SECTORS AA, A, B, & C WHERE NEW WORK IS INDICATED. EXT. FIXTURES IN ALL OTHER SECTORS.
	P.C.L. PRECAST CONCRETE LINTEL
	C.J. GYP. CL. OR DEFS. CONTROL JOINT

- GENERAL NOTES:**
- WHERE NEW GRID IS INSTALLED FINISH CEILING ELEVATION IS 10'-0" ABOVE FINISH FLOOR, UNLESS NOTED OTHERWISE ALIGN BOTTOM OF THE WALL ANGLE WITH THE TOP OF THE MORTAR JOINT IN LIEU OF LEVEL WITH THE FLOOR.
  - CONTRACTOR SHALL COORDINATE ALL TRADES BEFORE INSTALLATION OF CEILING.
  - IN AREAS WHERE GRID REMAINS, ADJUST T'S AS NEEDED FOR NEW LIGHT LAYOUTS.
  - IN LOCATIONS TO RECEIVE NEW CEILING TILE, REINSTALL ALL EXISTING ITEMS LOCATED IN THE CEILING TILE INCLUDING BUT NOT LIMITED TO EXIST. LIGHTS, SPRINKLER HEADS, SPEAKERS, CAMERAS, HVAC RETURN AIR GRILLS, & HVAC CEILING DIFFUSERS ETC. ADJUST SPRINKLER HEADS AND OTHER ITEMS AS NEEDED TO COORDINATE WITH NEW LIGHT LAYOUTS IN AREAS WITH NEW GRID.
  - SEE MECHANICAL DRAWINGS FOR NEW HVAC RETURN AIR GRILLS AND/OR HVAC CEILING DIFFUSERS.
  - WHEN EXPOSED STRUCTURE IS INDICATED AS "PAINTED", IT IS INTENDED TO INCLUDE THE ROOF DECK.
  - SEE FIRE PROTECTION, MECHANICAL AND ELECTRICAL DRAWINGS FOR ITEMS NOT INDICATED ON ARCHITECTURAL CEILING PLANS.
  - EXISTING AND NEW PENETRATIONS NEED TO BE SEALED FOR SMOKE AND/OR RATED PARTITIONS IN AREAS WHERE CEILING TILES ARE REPLACED AND/OR NEW.

Order Plans @

WWW.LDILine.com

REFLECTED CEILING PLAN - SECTOR "B"  
SCALE: 1/8" = 1'-0"