

Manley Spangler Smith Architects
A Professional Corporation

625 East Taylor St.
P.O. Box 680
Griffin, Georgia 30224
Office 770.227.5473
Fax 770.228.3442


PROJECT:
RENOVATIONS, MODIFICATIONS, & ADDITIONS TO HENRY COUNTY SCHOOLS - GROUP 16 WOODLAND HIGH SCHOOL (ITEM C)

CLIENT:
HENRY COUNTY BOARD OF EDUCATION

SHEET TITLE:
REFLECTED CEILING PLAN - SECTOR "C"

1/1 - 87
F.T.E. - 1,687
FACILITY CODE 675-0408
© 2018 Manley Spangler Smith Architects, PC
PROJECT NUMBER: 201731C
DATE: 06.07.18
SCALE: AS NOTED
DRAWN BY: JS
CHECKED BY: RV

SHEET NO.
A7.21C

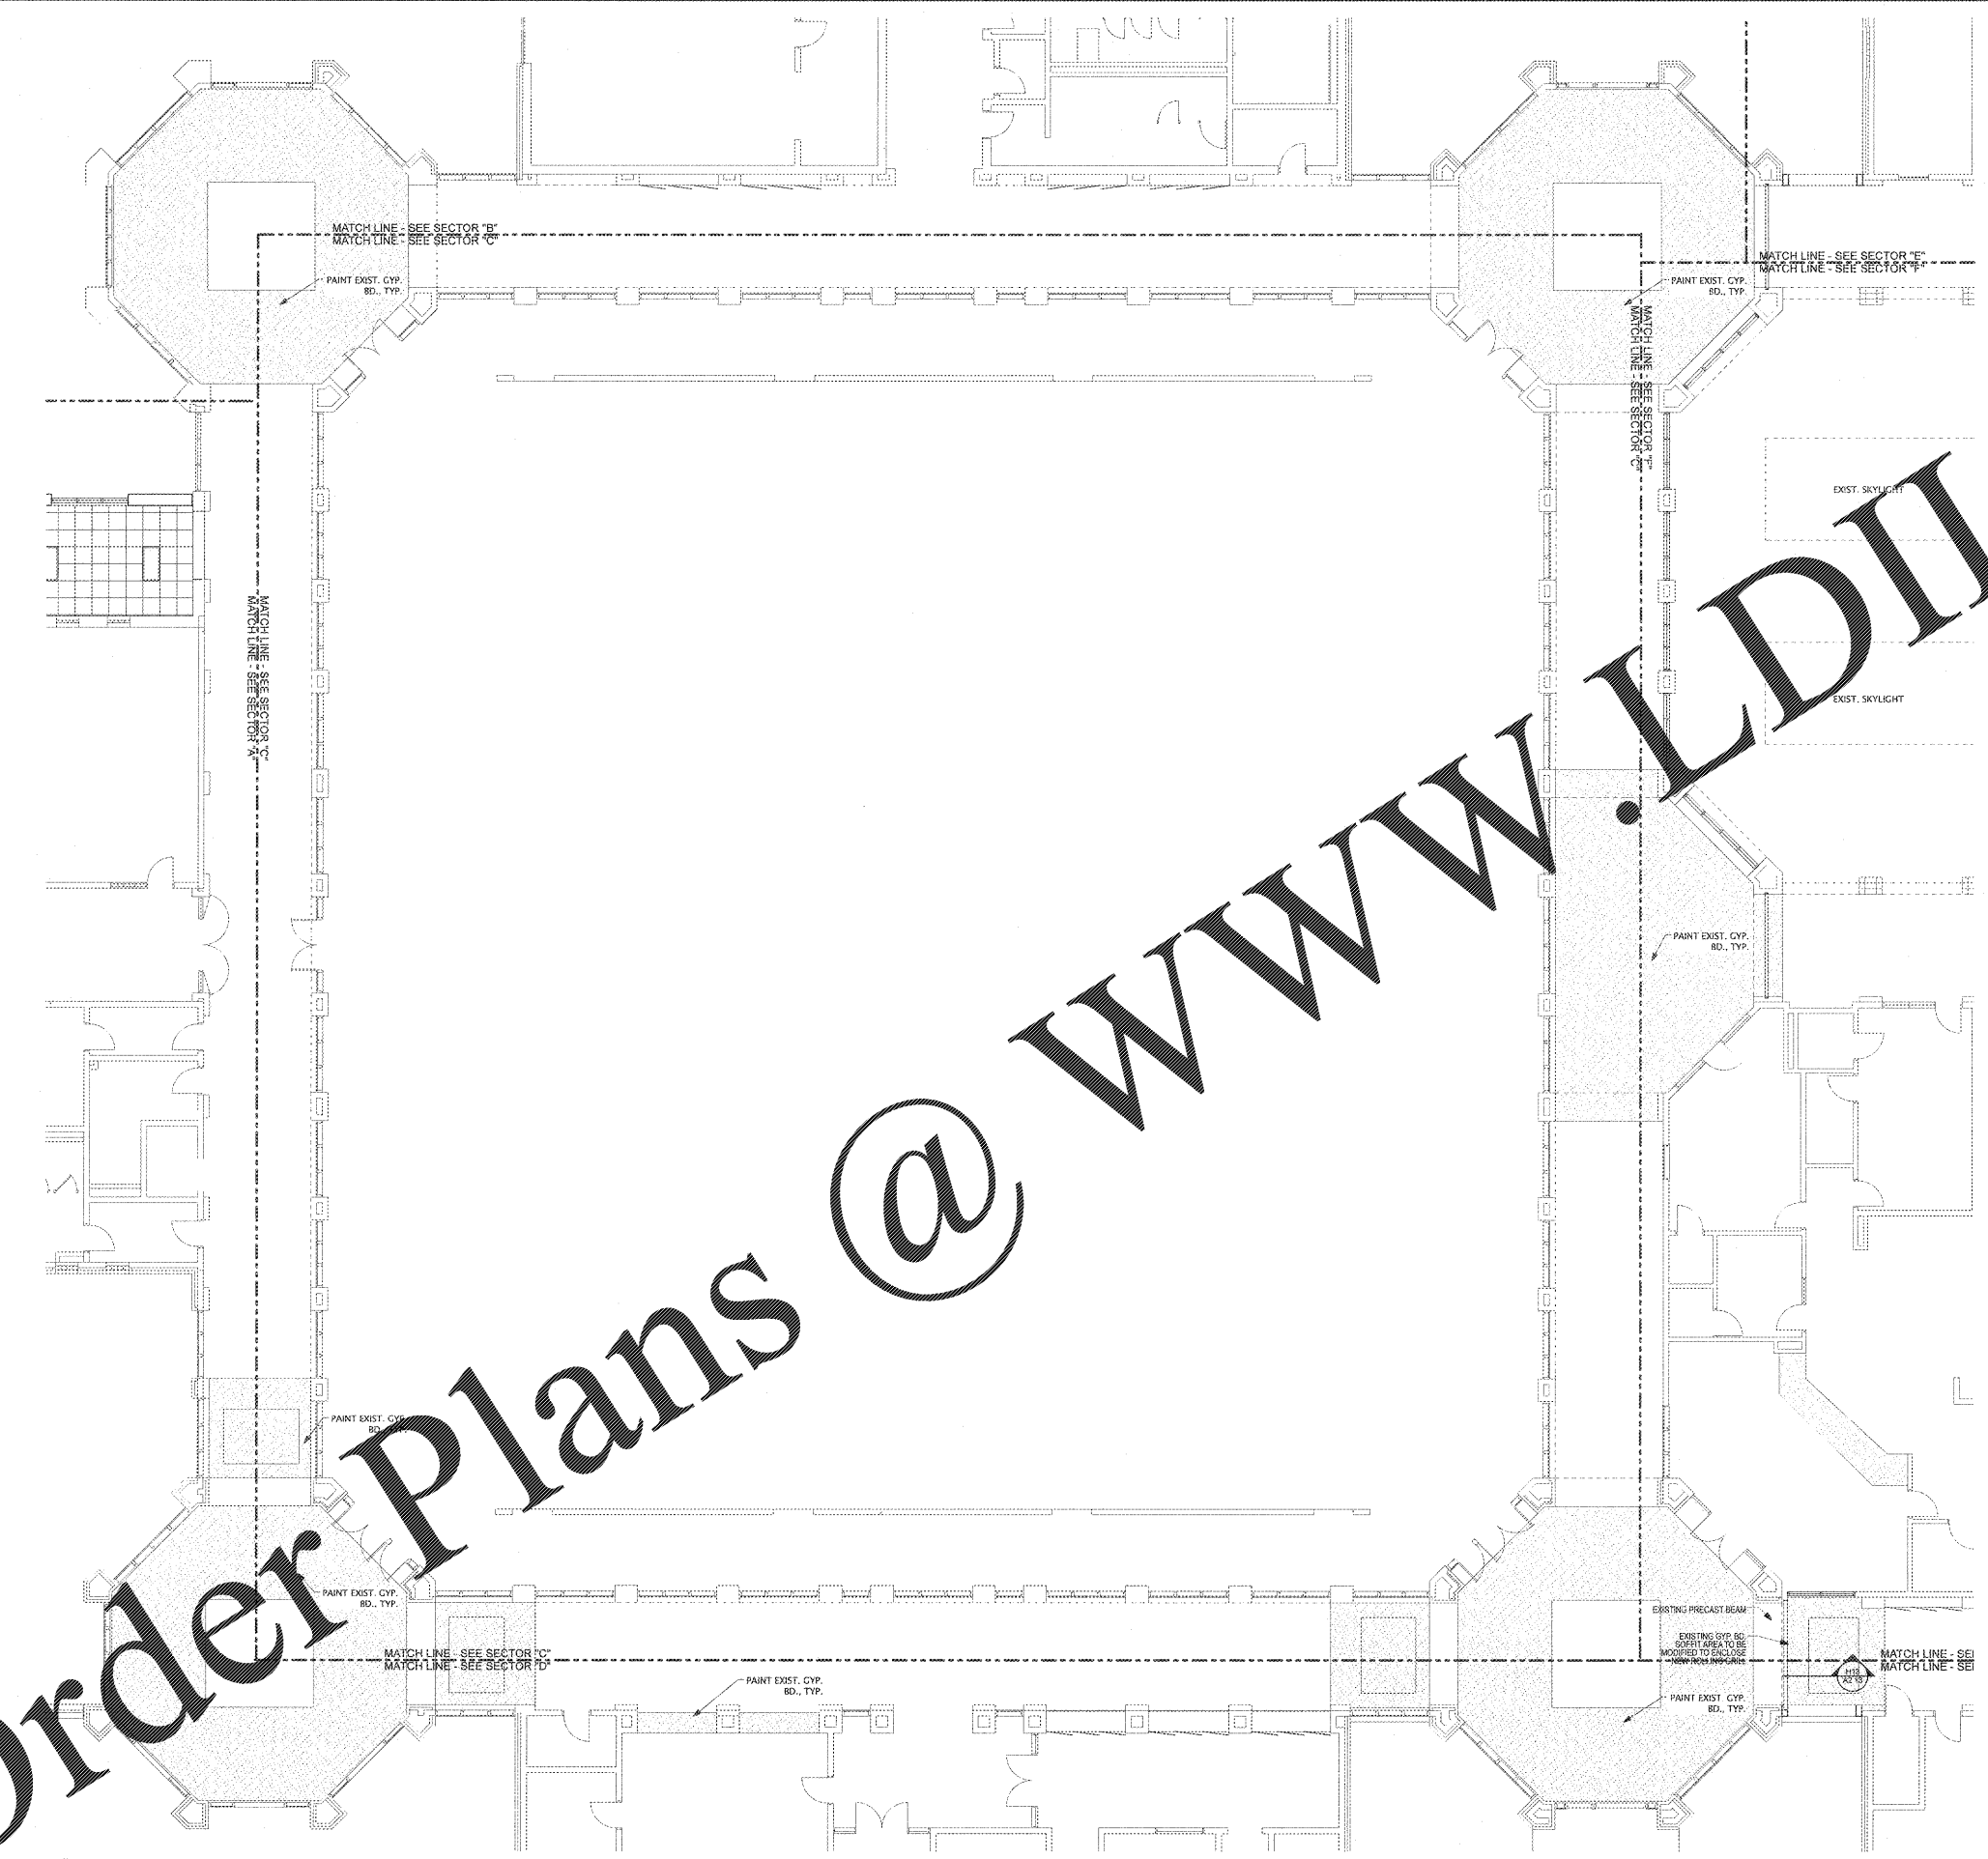

- LEGEND:**
- INDICATES CEILING HEIGHT
 - NEW 2' x 2' ACOUSTICAL CEILING PANELS W/ NEW GRID
 - NEW D.E.F.S. SOFFIT SYSTEM
 - NEW CEMENT PLASTER CEILING
 - NEW GYPSUM BOARD CEILING IN SECTORS AA & ALL EXT. GYP. BD. TO BE PAINTED IN ALL OTHER SECTORS
 - NEW 2' x 4' FL. LIGHT FIXTURES IN SECTORS AA, A, B, & G WHERE NEW GRID IS INDICATED. EXT. FIXTURES IN ALL OTHER SECTORS
 - EXIST. 1x4 SURFACE MTD. FL. LIGHT FIXTURE
 - NEW 1x4 FL. LIGHT FIXTURE IN SECTORS AA, A, B, & G WHERE NEW WORK IS INDICATED. EXT. SIGNS IN ALL OTHER SECTORS
 - NEW EXIT SIGN IN SECTORS AA, A, B, & G WHERE NEW WORK IS INDICATED. EXT. SIGNS IN ALL OTHER SECTORS
 - NEW RECESSED DOWNLIGHT IN SECTORS AA, A, B, & G WHERE NEW WORK IS INDICATED. EXT. FIXTURES IN ALL OTHER SECTORS
 - P.C.L. PRECAST CONCRETE LINTEL
 - C.J. GYP. CL.G. OR DEF'S CONTROL JOINT
- GENERAL NOTES:**
1. WHERE NEW GRID IS INSTALLED FINISH CEILING ELEVATION IS 10'-0" ABOVE FINISH FLOOR UNLESS NOTED OTHERWISE. ALIGN BOTTOM OF THE WALL ANGLE WITH THE TOP OF THE MORTAR JOINT IN LIEU OF LEVEL WITH THE FLOOR.
 2. CONTRACTOR SHALL COORDINATE ALL TRADES BEFORE INSTALLATION OF CEILING.
 3. IN AREAS WHERE GRID REMAINS, ADJUST T'S AS NEEDED FOR NEW LIGHT LAYOUTS.
 4. IN LOCATIONS TO RECEIVE NEW CEILING TILE, REINSTALL ALL EXISTING ITEMS LOCATED IN THE CEILING TILE INCLUDING BUT NOT LIMITED TO EXIT LIGHTS, SPRINKLER HEADS, SPEAKERS, CAMERAS, HVAC RETURN AIR GRILLS, & HVAC CEILING DIFFUSERS ETC. ADJUST SPRINKLER HEADS AND OTHER ITEMS AS NEEDED TO COORDINATE WITH NEW LIGHT LAYOUTS IN AREAS WITH NEW GRID.
 5. SEE MECHANICAL DRAWINGS FOR NEW HVAC RETURN AIR GRILLS AND/OR HVAC CEILING DIFFUSERS.
 6. WHEN EXPOSED STRUCTURE IS INDICATED AS "PAINTED", IT IS INTENDED TO INCLUDE THE ROOF DECK.
 7. SEE FIRE PROTECTION, MECHANICAL AND ELECTRICAL DRAWINGS FOR ITEMS NOT INDICATED ON ARCHITECTURAL CEILING PLANS.
 8. EXISTING AND NEW PENETRATIONS NEED TO BE SEALED FOR SMOKE AND/OR RATED PARTITIONS IN AREAS WHERE CEILING TILES ARE REPLACED AND/OR NEW.

1 REFLECTED CEILING PLAN - SECTOR "C"
SCALE: 1/8" = 1'-0"

Order Plans @ www.LDILine.com

www.LDILine.com