



REVISIONS/ISSUANCES		
NO.	DATE	DESCRIPTION

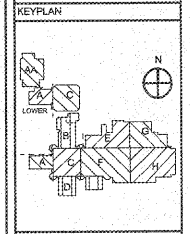

AH&P
CONSULTING ENGINEERS
ANDREWS, HAMMOCK & POWELL, INC.
250 Charter Lane
Suite 100
Macon, Georgia 31210
Macon (478) 455-3001
FAX (478) 455-8210
WWW.AHPENR.COM

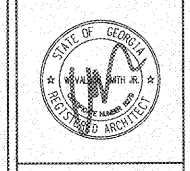

Manley Spangler Smith Architects
A Professional Corporation

525 East Taylor St.
P.O. Box 880
Griffin, Georgia 30224
Office 770.227.5473
Fax 770.228.3442


PROJECT:
RENOVATIONS,
MODIFICATIONS, &
ADDITIONS TO HENRY
COUNTY SCHOOLS -
GROUP 10
WOODLAND HIGH SCHOOL
(ITEM C)

CLIENT:
HENRY COUNTY
BOARD OF EDUCATION

SHEET TITLE:
FIRE PROTECTION
OVERALL FLOOR PLAN
AND DETAILS

LSJ : 88
F.Y.E. : 1.087
FACILITY CODE: 675-0408
© 2018 Manley Spangler Smith Architects, PC
PROJECT NUMBER: 201731C
DATE: 06.07.18
SCALE: AS SHOWN
DRAWN BY: JAC
CHECKED BY: JAC

SHEET NO.: FP101

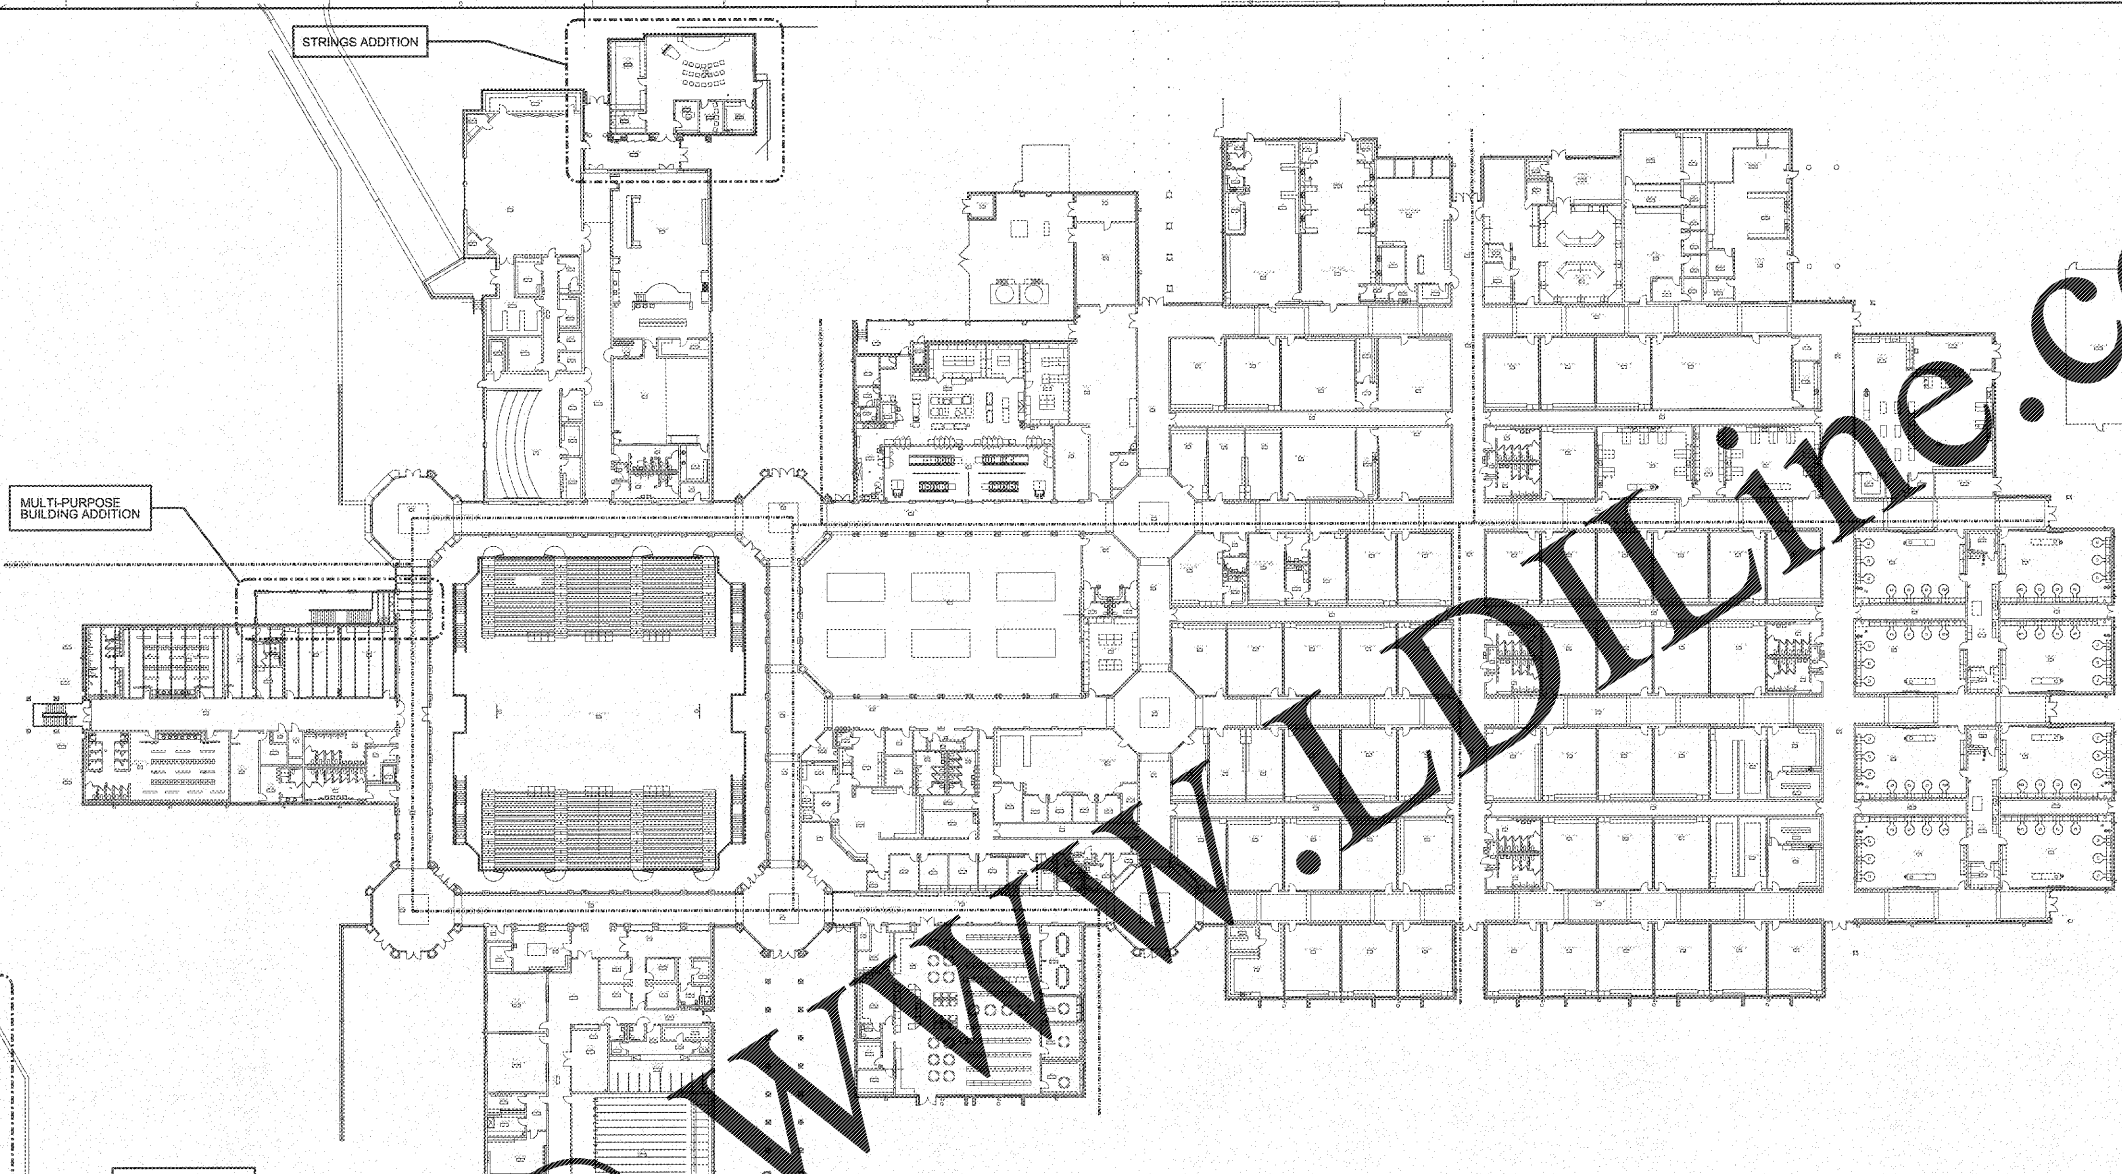


OVERALL FIRE PROTECTION FLOOR PLAN - MAIN LEVEL
SCALE: 1" = 30'-0"


CONTRACTOR SHALL REFER TO ARCHITECTURAL DRAWINGS FOR ALL DETAILS RELATED TO SPACE NAMES AND FUNCTIONS, CEILING HEIGHTS AND TYPES, WALL RATINGS AND TYPES, ETC.

NOTES: (THIS SHEET ONLY)


- 1 FIRE PROTECTION ENTRANCE RISER LOCATION FOR THE MULTI-PURPOSE BUILDING AND STRINGS ADDITION. SEE SHEET FP101 FOR 1/4" SCALE LOCATION. SEE NEW SPRINKLER ENTRANCE RISER DETAIL ON THIS SHEET.
- 2 4" FIRE MAIN PIPING OUT TO FREE STANDING FIRE DEPARTMENT CONNECTION. SEE CIVIL DRAWINGS FOR PIPING CONTINUATION. SEE FIRE DEPARTMENT CONNECTION DETAIL ON THIS SHEET.
- 3 SUGGESTED ROUTING FOR SPRINKLER MAIN PIPING. CONTRACTOR SHALL COORDINATE EXACT ROUTING WITH ALL OTHER TRADES.
- 4 CONTRACTOR SHALL LIMIT THE AMOUNT OF EXPOSED SPRINKLER PIPING IN THIS CORNER.
- 5 SPRINKLER PIPING SHALL RISE IN THIS CORNER TO HIGH ROOF STRUCTURE ABOVE.
- 6 COORDINATE ROUTING OF SPRINKLER PIPING THROUGH THIS AREA WITH ARCHITECTURAL SKYLIGHT. SEE ARCHITECTURAL DRAWINGS.

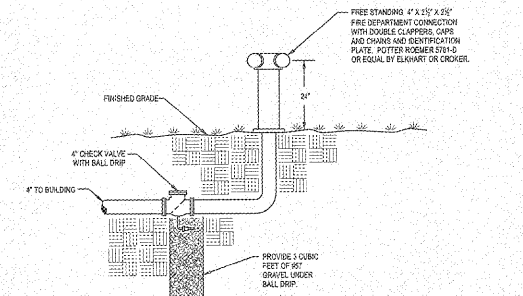


FIRE DEPARTMENT CONNECTION DETAIL
SCALE: NONE

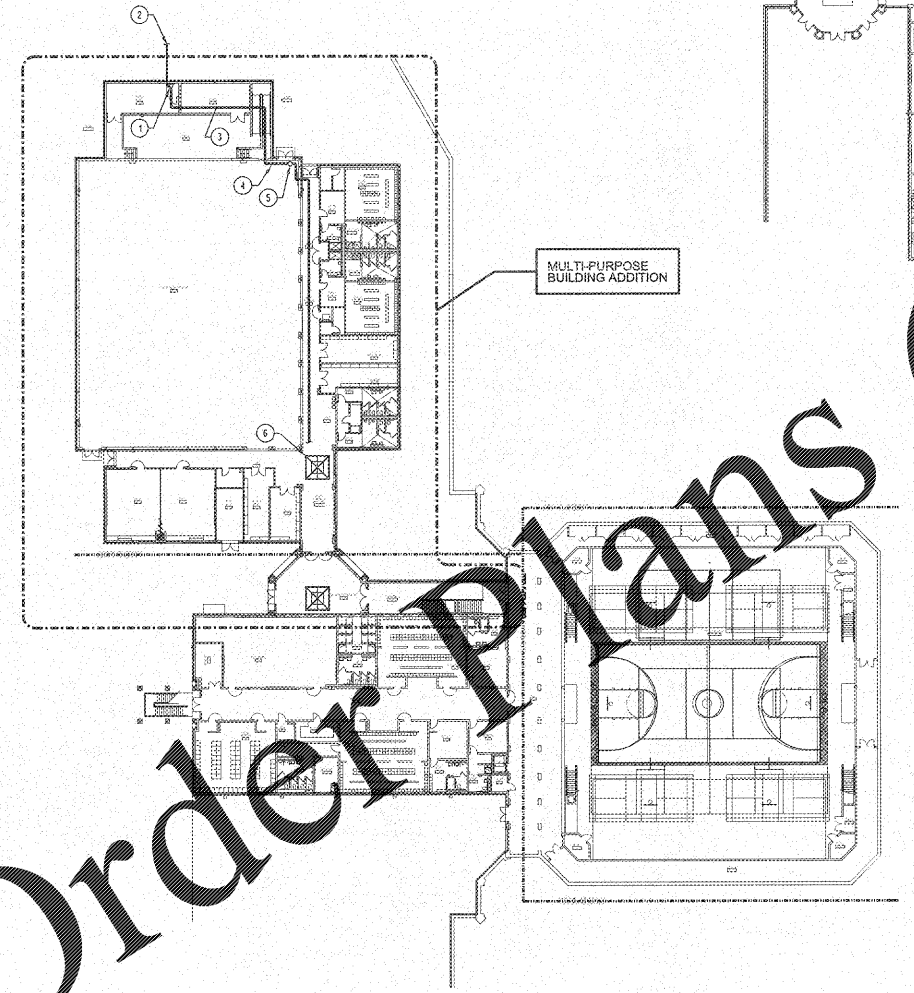


OVERALL FIRE PROTECTION FLOOR PLAN - LOWER LEVEL
SCALE: 1" = 30'-0"

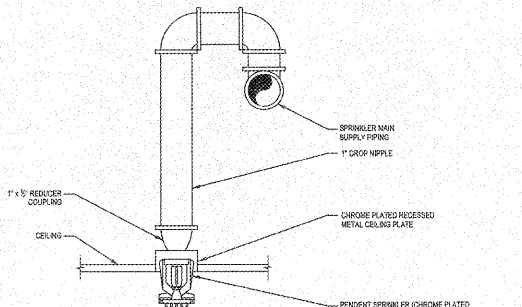

TYPICAL DROP TO PENDENT SPRINKLER
SCALE: NONE

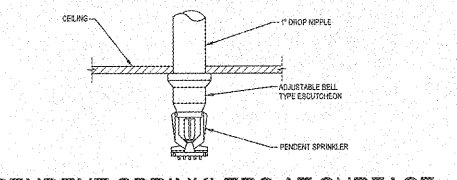

PENDENT SPRINKLERS AT SURFACE MOUNTED LIGHT FIXTURES
SCALE: NONE

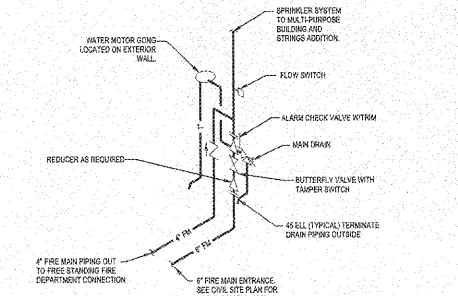

NEW SPRINKLER ENTRANCE RISER
SCALE: NONE

Order Plans

@ WWW.WLDLINE.COM