


NOTES: (THIS SHEET ONLY)

- 1 EXISTING SERVICE SWITCHBOARD SHALL REMAIN. SEE NEW WORK PLANS.
- 2 EXISTING TRANSFORMER(S) SHALL REMAIN.
- 3 EXISTING 120/208V, 3 PH. 4W PANELBOARD SHALL REMAIN IN ITS ENTIRETY.
- 4 EXISTING 277/480V, 3 PH. 4W PANELBOARD SHALL REMAIN IN ITS ENTIRETY.
- 5 REMOVE EXISTING PULVERIZED FUEL SYSTEM IN ITS ENTIRETY.
- 6 EXISTING INTERCOM SYSTEM CONSOLE SHALL REMAIN IN ITS ENTIRETY. CONTRACTOR SHALL PROTECT, SECURE, AND MAINTAIN EXISTING INTERCOM SYSTEM AND ALL COMPONENTS.
- 7 DEMOLISH TWO PORT DATA OUTLET DESIGNATED FOR EXISTING TEACHERS DESK IN ITS ENTIRETY. DEMOLISH DATA CABLES BACK TO THE SOURCE. PATCH AND PAINT WALLS TO MATCH EXISTING. PROVIDE BLANK COVER PLATE FOR ABANDONED IN WALL DATA OUTLET BOX.
- 8 REMOVE EXISTING WALL MOUNTED TV SET AND ASSOCIATED WALL BRACKET IN ITS ENTIRETY. PATCH AND PAINT WALL.
- 9 EXISTING VIDEO SURVEILLANCE SYSTEM AND ASSOCIATED EQUIPMENT SHALL REMAIN. PROTECT AND SECURE EQUIPMENT DURING RECONSTRUCTION.
- 10 EXISTING FIRE ALARM PANEL TO REMAIN IN ITS ENTIRETY. SECURE ALL ASSOCIATED CABINETS IN THEIR ENTIRETY. SYSTEM SHALL REMAIN OPERATIONAL DURING RECONSTRUCTION.
- 11 EXISTING TELEPHONE BACKBONE TO REMAIN IN ITS ENTIRETY.
- 12 COMPUTER NETWORK MAIN DISTRIBUTION FRAME (MDF) SHALL REMAIN. SECURE EQUIPMENT. COORDINATE WITH THE OWNER BEFORE COMMENCEMENT OF WORK IN THIS AREA.
- 13 EXISTING TV DISTRIBUTION HEAD- END EQUIPMENT SHALL REMAIN. CONTRACTOR SHALL PROTECT AND SECURE ALL EQUIPMENT.
- 14 EXISTING COMPUTER NETWORK DISTRIBUTION FRAME (CDF) SHALL REMAIN. SECURE AND PROTECT ELECTRONIC DEVICES.
- 15 GENERAL: IF ANY LIGHTING, OUTLET, OR DEVICE TO BE REMOVED POWER CIRCUITS ARE UPSTREAM OF OTHER LIGHTING, OUTLET, AND DEVICE TO REMAIN, CONTRACTOR SHALL REMOVE THE EXISTING CIRCUIT TO MAINTAIN THE CONTINUITY TO THE DOWNSTREAM DEVICES.
- 16 REMOVE EXISTING STEP-UP FROM FLOOR OUTLETS IN THEIR ENTIRETY FROM THIS SPACE INCLUDING CIRCUIT CONDUITS, CABLE RACEWAYS, AND ETC. BACK TO THEIR SOURCE. PATCH BLAS WITH MATCHING FILL.
- 17 REMOVE EXISTING EXTERIOR LIGHT FIXTURES, OUTLETS, DEVICES, COMPONENTS, AND RACEWAYS IN THEIR ENTIRETY FROM THIS LOCATION. PREPARE FOR NEW ADDITION CONSTRUCTION. EXTEND EXISTING CIRCUITS FOR CONTINUITY TO OTHER LIGHT FIXTURES AND OUTLETS TO REMAIN.
- 18 GENERAL: DISCONNECT EXISTING WIRING SYSTEMS ELECTRICAL CIRCUITS AND PREPARE EXISTING CIRCUITS FOR RECONSTRUCTION TO THE NEW EQUIPMENT WHERE NEW HAND DRYERS ARE SHOWN AND NOTED ON ARCHITECTURAL DRAWINGS.
- 19 REMOVE, SECURE, PROTECT, AND REINSTALL THIS VIDEO SURVEILLANCE SYSTEM CAMERA TO ACCOMMODATE NEW ADDITION CONSTRUCTION.
- 20 RELOCATE THIS FIRE ALARM SYSTEM DEVICE TO ACCOMMODATE NEW CONSTRUCTION.
- 21 EXISTING PA SYSTEM AND ASSOCIATED SPEAKERS SHALL REMAIN IN THIS GYMNASIUM.

GENERAL DEMOLITION NOTES

- A. ALL EXISTING INTERIOR AND EXTERIOR LIGHT FIXTURES AND EXIT SIGNS SHALL REMAIN IN THE BUILDING IN THEIR ENTIRETY. LIGHTING CIRCUIT CONDUITS, CONDUIT AND WIRING SHALL REMAIN UNLESS NOTED OTHERWISE OR INDICATED TO BE CONNECTED TO EXISTING.
- B. REMOVE ALL EXISTING WALL MOUNTED OUTLET DEVICES WHERE NEW DEVICES ARE SHOWN TO BE CONNECTED TO EXISTING CIRCUITS. PREPARE EXISTING CIRCUIT CONDUITS FOR CONNECTION TO NEW DEVICES SHOWN ON THE NEW WORK PLANS OR AS NOTED OTHERWISE. PROVIDE BLANK COVER PLATES FOR ALL ABANDONED IN WALL OUTLET BOXES.
- C. REMOVE ALL ELECTRICAL CIRCUITS IN THEIR ENTIRETY FROM ALL MECHANICAL EQUIPMENT ROOMS TO BE DEMOLISHED OR MECHANICAL DEMOLITION PLANS INCLUDING ROOF TOP UNITS, EQUIPMENT FANS, WALL HEATERS, WATER SOURCE UPS, AND PUMPS ETC. MECHANICAL EQUIPMENT SHOWN TO BE REMOVED AND IDENTIFIED DURING CONSTRUCTION OR MECHANICAL PLANS SHALL BE DISCONNECTED AND RECONNECTED TO THE EXISTING ELECTRICAL CIRCUITS.
- D. ALL EXISTING COMPUTER DATA AND TELEPHONE OUTLETS, CABLES, AND RACEWAYS SHALL REMAIN UNLESS NOTED OTHERWISE OR NEW WORK. CONTRACTOR SHALL BE RESPONSIBLE FOR THE PROTECTION OF EXISTING DATA OUTLETS AND ALL ASSOCIATED NETWORKING ELECTRONIC EQUIPMENT DURING DEMOLITION AND RENOVATIONS OF ALL AREAS.
- E. ALL EXISTING FIRE ALARM SYSTEM DEVICES INCLUDING CONTROL PANELS, SMOKE DETECTORS, HORNS, STRIPES AND ETC. SHALL REMAIN IN THEIR ENTIRETY UNLESS NOTED OTHERWISE.
- F. ALL EXISTING TV DISTRIBUTION SYSTEM CABLES INCLUDING ALL TV HEAD-END EQUIPMENT ETC. SHALL REMAIN. SECURE TV DISTRIBUTION CABLES DURING CONSTRUCTION. PREPARE EXISTING HEAD- END EQUIPMENT FOR CONNECTION TO ANY NEW TV DISTRIBUTION CABLE UNLESS NOTED OTHERWISE. REMOVE ALL WALL MOUNTED TV OUTLETS FROM ALL SPACES. PREPARE EXISTING TV DISTRIBUTION CABLES TO BE EXTENDED TO THE NEW TV OUTLET LOCATIONS AT THE LOCUS MOUNTED PROJECTORS. PROVIDE BLANK COVER PLATES FOR UNUSED WALL BOXES.
- G. ALL EXISTING INTERCOM SYSTEM COMPONENTS INCLUDING SPEAKERS, CLOCKS, HANDSETS, PUSHBUTTONS, CABLES AND RACKS ETC. SHALL REMAIN IN THEIR ENTIRETY UNLESS NOTED OTHERWISE. CONTRACTOR SHALL PROTECT AND SECURE ALL EQUIPMENT.
- H. ALL EXISTING CCTV VIDEO SURVEILLANCE SYSTEM CAMERAS AND REORDER HEAD- END EQUIPMENT INCLUDING TV MONITORS AND CABLES SHALL REMAIN. SECURE, PROTECT, AND RE-MOUNT EXISTING VIDEO SURVEILLANCE CAMERAS IN NEW CEILING TILES.
- I. ALL EXISTING WALL MOUNTED CRT TV SETS INCLUDING TV BRACKETS AND ASSOCIATED S-VIDEO OUTLETS WITH CABLES SHALL BE REMOVED IN THEIR ENTIRETY FROM THE BUILDING. PATCH AND PAINT WALLS TO MATCH EXISTING. TV SETS ARE LOCATED IN ALL CLASSROOMS, MAIN OFFICES, COMMONS, AND ETC.
- J. REMOVE ALL EXISTING GLOOM HANGER OUTLETS FROM ALL CLASSROOMS. PROVIDE BLANK COVER PLATES FOR ALL UNUSED WALL BOXES. MAINTAIN CIRCUIT CONTINUITY.
- K. ALL EXISTING ELECTRICAL CIRCUITS FOR TELEPHONE, INTERCOM, TV, SECURITY, FIRE ALARM AND CCTV SHALL BE SHUT DOWN IN THE OCCUPIED AREAS DURING DEMOLITION UNLESS NOTED OTHERWISE. CONTRACTOR IS CAUTIONED THAT ALL OF THE EXISTING LOW VOLTAGE SYSTEM CABLES IS NOT RUN IN CONDUIT.
- L. ALL EXISTING NEWLY INSTALLED WIRELESS DATA NETWORK ACCESS POINTS AND ASSOCIATED CABLES SHALL REMAIN. THE CONTRACTOR SHALL SECURE, PROTECT, AND REPAIR AS NECESSARY ALL EXISTING ACCESS POINTS AND CABLES.
- M. ALL EXISTING PROJECTORS MOUNTED IN CLASSROOM CEILING SHALL BE REMOVED IN THEIR ENTIRETY. HANG PROJECTORS AND ASSOCIATED COMPONENTS WITH CABLES TO THE DOWNER. PROVIDE NEW CEILING TILE IN THE LOCATION OF EXISTING PROJECTOR.

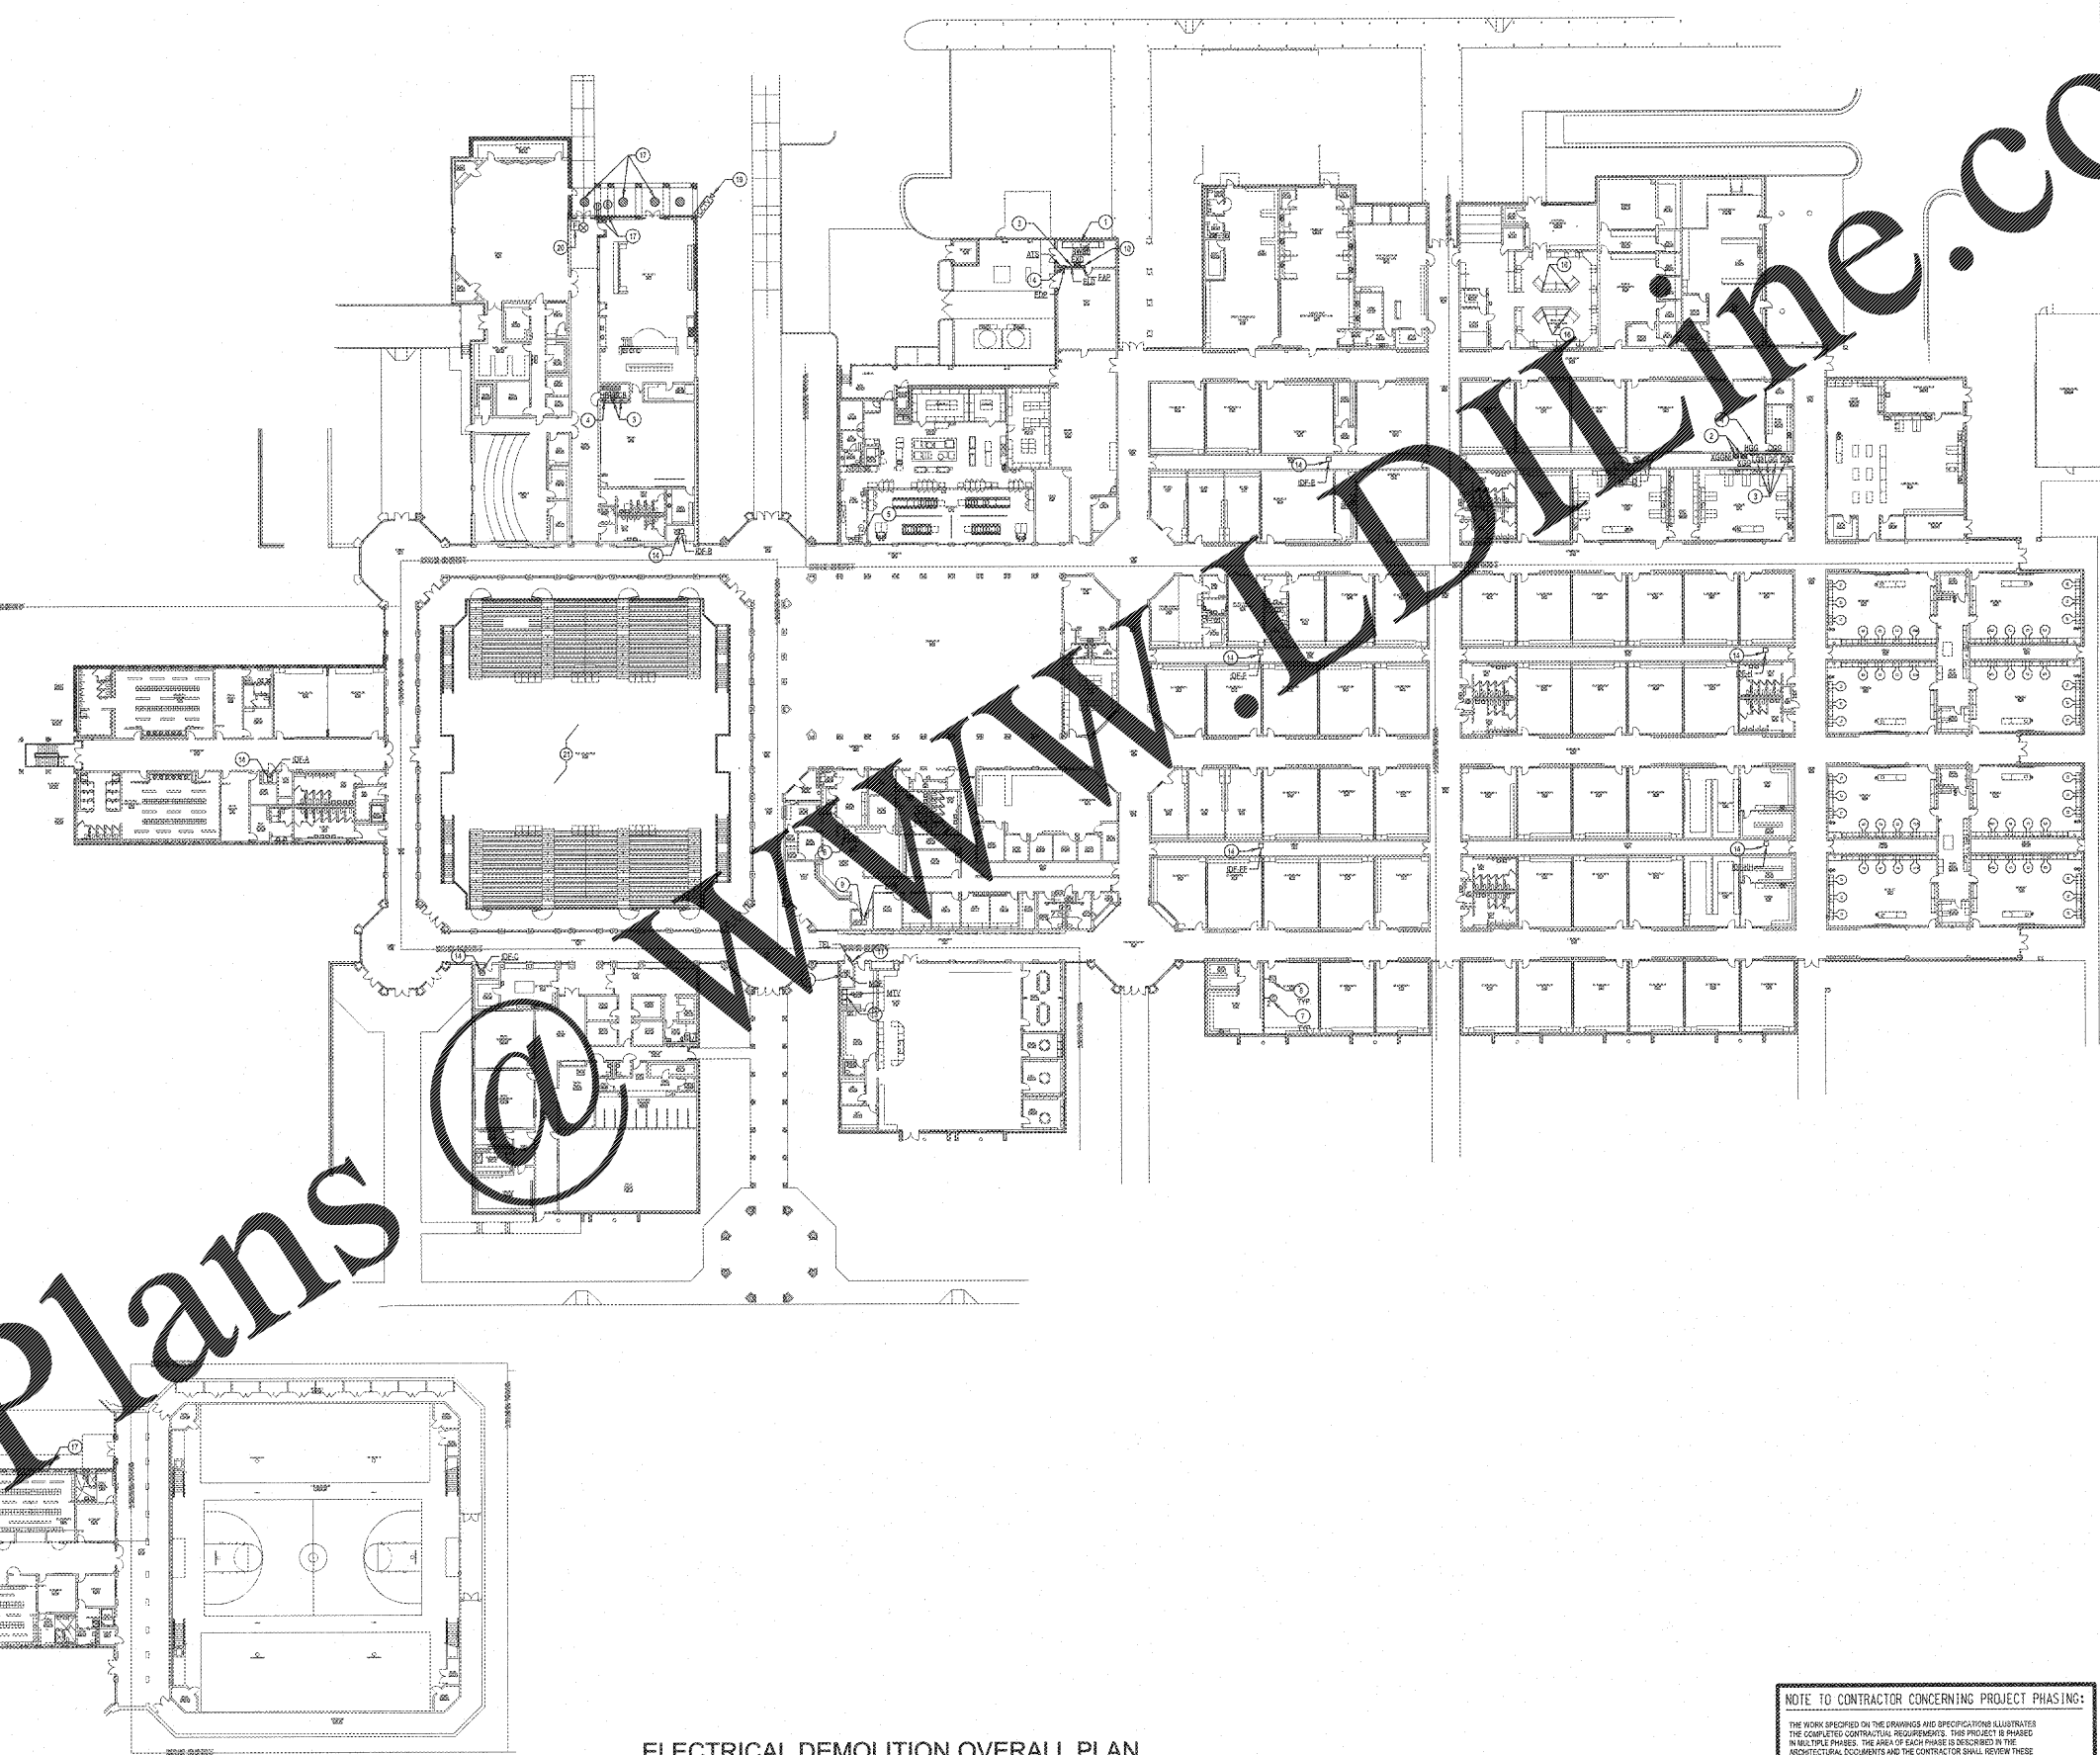

REVISIONS/ISSUANCES		
NO.	DATE	DESCRIPTION

KEYPLAN

AH&P
CONSULTING ENGINEERS
ANDREWS, HAMMOCK & POWELL, INC.
250 Olin Lane
Suite 100
Macon, Georgia 31210
Macon (478) 405-8301
FAX (478) 405-8210
WWW.AHPENR.COM

GEORGIA REGISTERED PROFESSIONAL ENGINEER

STATE OF GEORGIA REGISTERED ARCHITECT

Manley Spangler Smith Architects
A Professional Corporation

525 East Taylor St.
P.O. Box 1840
Griffin, Georgia 30224
Office 770.227.5473
Fax 770.228.3442

PROJECT: RENOVATIONS, MODIFICATIONS, & ADDITIONS TO HENRY COUNTY SCHOOLS - GROUP 49 WOODLAND HIGH SCHOOL (ITEM C)

CLIENT: HENRY COUNTY BOARD OF EDUCATION

SHEET TITLE: ELECTRICAL DEMOLITION OVERALL PLAN

1/4" = 8'
P.T.E.: 1,687
FACILITY CODE: 076-0408
© 2018 Manley Spangler Smith Architects, PC
PROJECT NUMBER: 201731C
DATE: 06.07.18
SCALE: AS SHOWN
DRAWN BY: AJS
CHECKED BY: RHC
SHEET NO. ED001

NOTE TO CONTRACTOR CONCERNING PROJECT PHASING:

THE WORK SPECIFIED ON THE DRAWINGS AND SPECIFICATIONS ILLUSTRATES THE COMPLETE CONTRACTOR REQUIREMENTS. THIS PROJECT IS PHASED IN MULTIPLE PHASES. THE AREA OF EACH PHASE IS DESCRIBED IN THE ARCHITECTURAL DOCUMENTS AND THE CONTRACTOR SHALL REVIEW THESE PHASING REQUIREMENTS. CONTRACTOR SHALL INCLUDE IN HIS BID ALL COSTS REQUIRED TO ACCOMPLISH THE CONTRACT BY PHASE. THE CONTRACT DOCUMENTS DO NOT RESOLVE THE SPECIFIC WORK REQUIRED BY THE CONTRACTOR TO PERFORM THE PROJECT IN PHASES, BUT CONTRACTOR SHALL PREPARE PHASING PLAN AND SUBMIT TO ARCHITECT FOR REVIEW AND HENRY COUNTY MAINTENANCE DEPARTMENT PRIOR TO BEGINNING WORK.

ELECTRICAL DEMOLITION OVERALL PLAN
SCALE: 1"=30'

Order Plans