


Order Plans @ www.LDLine.com

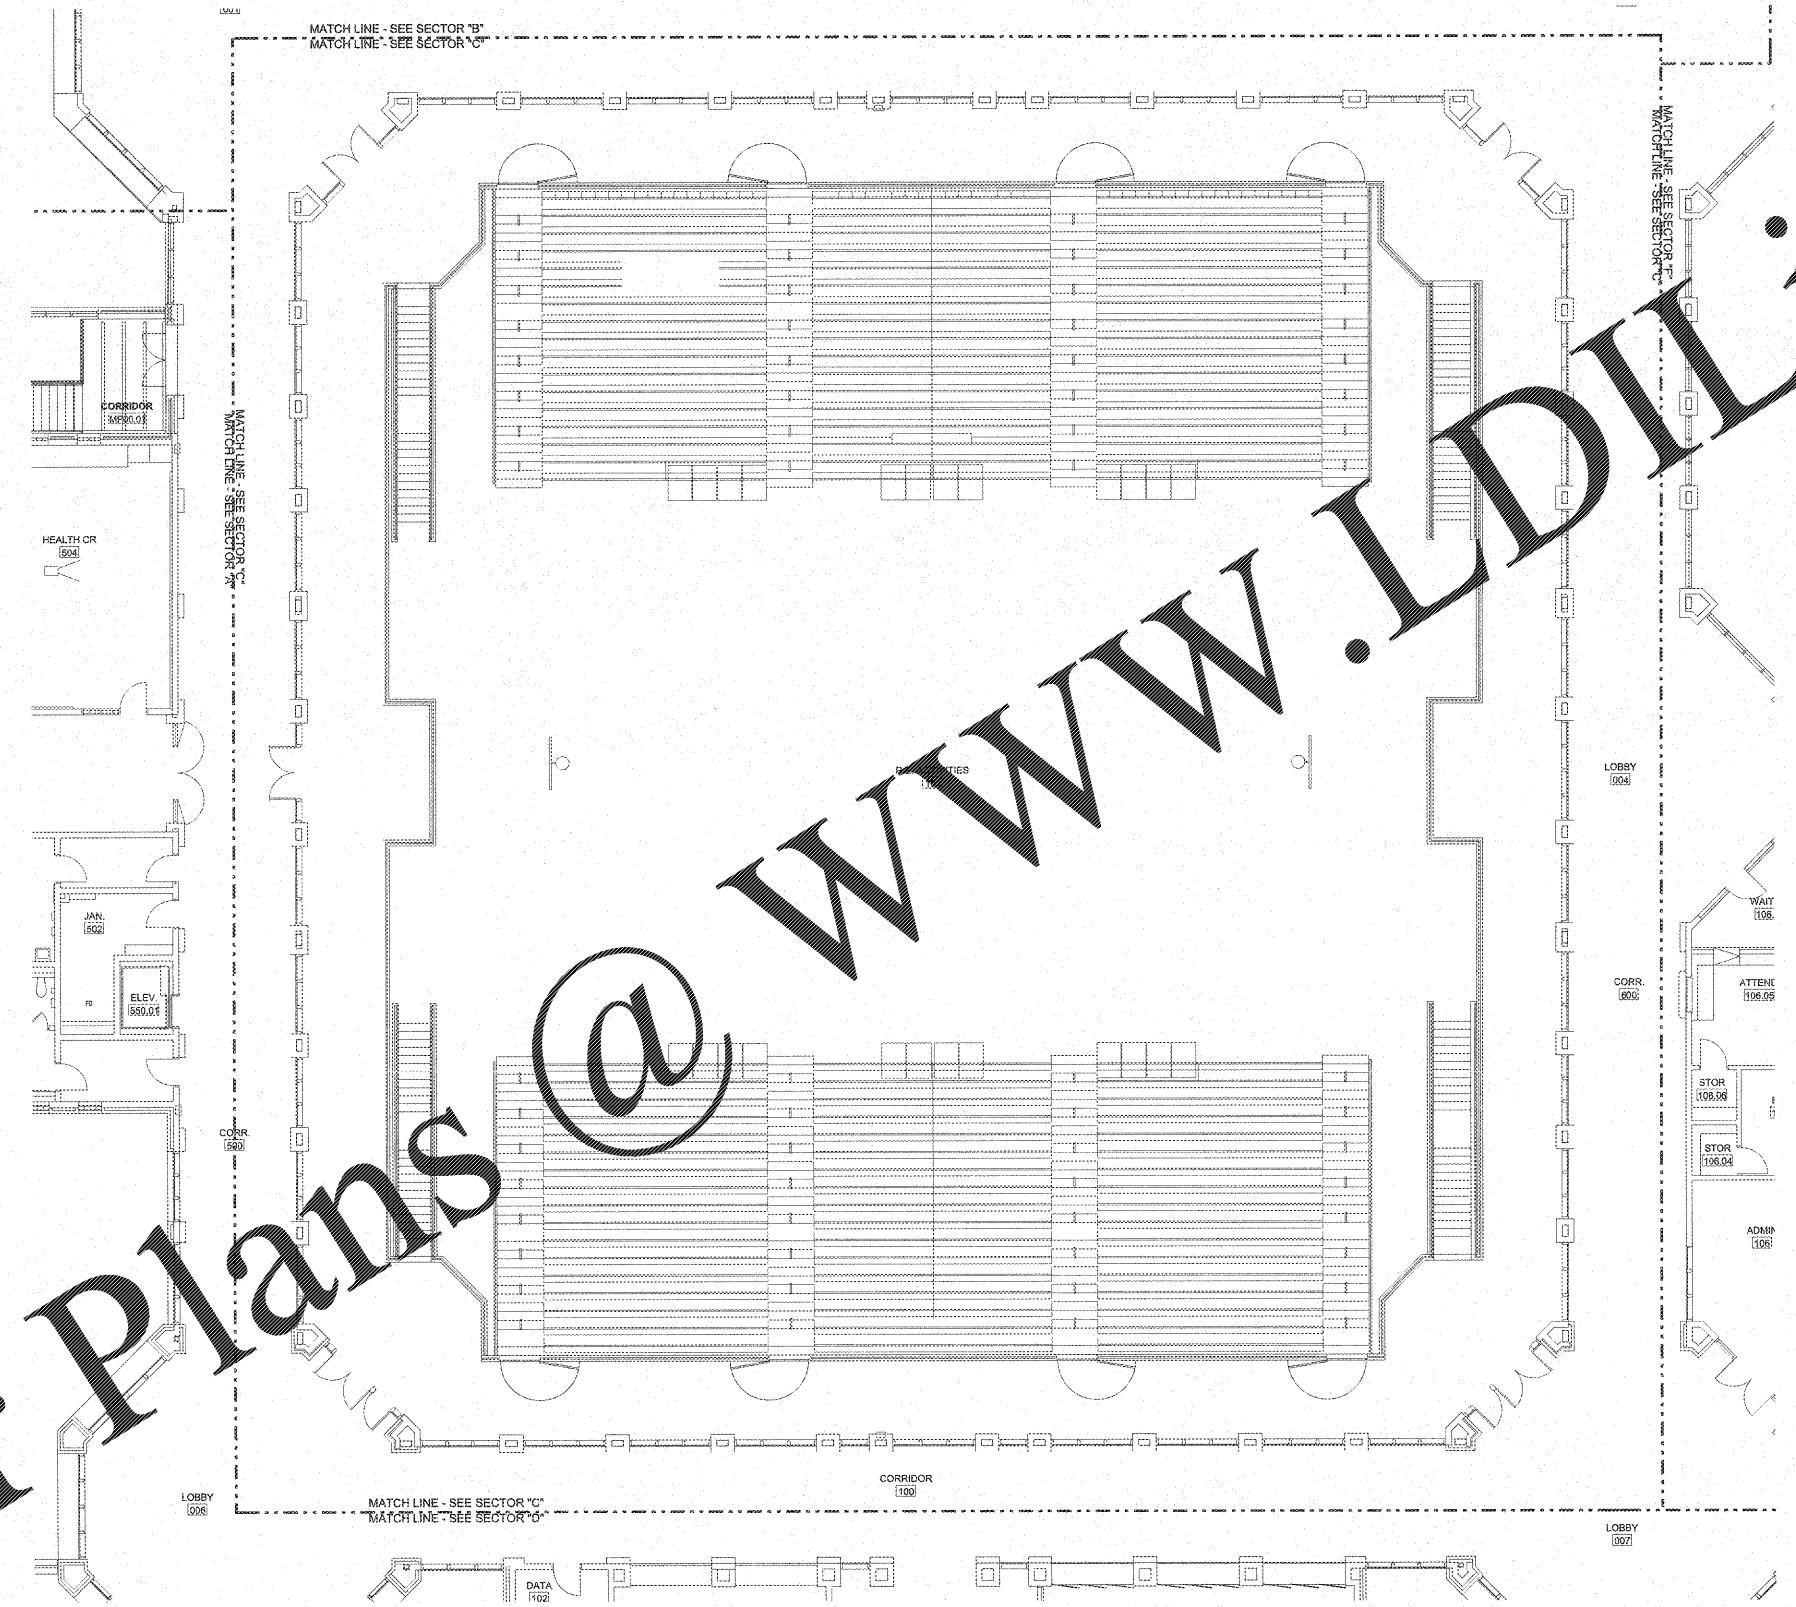

ELECTRICAL NEW WORK LIGHTING PLAN - SECTOR "C" UPPER LEVEL
SCALE: 1/8"=1'-0"

NOTE TO CONTRACTOR CONCERNING PROJECT PHASING:
THE WORK SPECIFIED ON THE DRAWINGS AND SPECIFICATIONS ILLUSTRATES THE COMPLETED CONTRACTUAL REQUIREMENTS. THIS PROJECT IS PHASED IN MULTIPLE PHASES. THE AREA OF EACH PHASE IS DESCRIBED IN THE ARCHITECTURAL DOCUMENTS AND THE CONTRACTOR SHALL REVIEW THESE PHASING REQUIREMENTS. CONTRACTOR SHALL INCURE IN HIS OR HER ALL COSTS REQUIRED TO ACCOMPLISH THE CONTRACT IN PHASES. THE CONTRACTOR'S OBLIGATION DOES NOT ENDORSE THE PROJECT WORK REQUIRED BY THE CONTRACTOR TO PERFORM THE PROJECT IN PHASES, BUT CONTRACTOR SHALL PREPARE PHASING PLAN AND SUBMIT TO ARCHITECT/ENGINEER AND HENRY COUNTY MAINTENANCE DEPARTMENT PRIOR TO BEGINNING WORK.

GENERAL LIGHTING NOTE
UNDER THIS PROJECT OCCUPANCY SENSORS SHALL BE INSTALLED. EXISTING 277V LIGHTING CIRCUITS WITHIN BUILDING SHALL BE UTILIZED TO POWER EXISTING LIGHTING. SOME AREAS REQUIRE REWIRING OF LIGHTING CIRCUIT WITHIN SPACES WHILE OTHERS MAY CONNECT DIRECTLY TO EXISTING SWITCHES. EXISTING CONDUIT AND WIRING MAY BE UTILIZED WHERE IT MEETS THIS SPECIFICATION.

REVISIONS/ISSUANCES		
NO.	DATE	DESCRIPTION

KEYPLAN

AH&P CONSULTING ENGINEERS
ANDREWS, HAMBROCK & POWELL, INC.
250 Oliver Lane
Suite 100
Macon, Georgia 31210
Macon (478) 405-8310
Fax (478) 405-8210
WWW.AHPENGR.COM

STATE OF GEORGIA REGISTERED ARCHITECT
MANLEY SPANGLER SMITH

Manley Spangler Smith Architects
A Professional Corporation

525 East Taylor St.
P.O. Box 180
Cuthbert, Georgia 30224
Office 770.227.5473
Fax 770.228.3442

PROJECT: REMOVATIONS, MODIFICATIONS, & ADDITIONS TO HENRY COUNTY SCHOOLS - GROUP 10 WOODLAND HIGH SCHOOL (ITEM C)

CLIENT: HENRY COUNTY BOARD OF EDUCATION

SHEET TITLE: ELECTRICAL NEW WORK LIGHTING PLAN - SECTOR "C" UPPER LEVEL

LU: 88
F.T.E.: 1.88P
FACILITY CODE: 175-0408
© 2018 Manley Spangler Smith Architects, P.C.
PROJECT NUMBER: 201701C
DATE: 08.07.18
SCALE: 1/8"=1'-0"
DRAWN BY: AJS
CHECKED BY: NHO

SHEET NO. **E105**