


NOTES: (THIS SHEET ONLY)
 ① GENERAL ROUTE ALL DATA CABLES ON THIS SHEET TO DF-4

REVISIONS/ISSUANCES		
NO.	DATE	DESCRIPTION

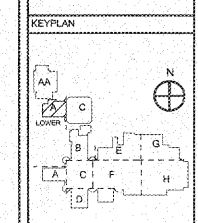

AH&P
 CONSULTING ENGINEERS
 ANDREWS, HARMON & POWELL, INC.
 250 Charter Lane
 Suite 100
 MACON, GEORGIA 31210
 MACON (478) 405-8301
 FAX (478) 405-8210
 WWW.AHPENGR.COM



Manley Spangler Smith Architects
 A Professional Corporation

525 East Taylor St.
 P.O. Box 890
 Griffin, Georgia 30224
 Office 770.227.5473
 Fax 770.228.3442

PROJECT:
 RENOVATIONS,
 MODIFICATIONS, &
 ADDITIONS TO HENRY
 COUNTY SCHOOLS -
 GROUP 10
 WOODLAND HIGH SCHOOL
 (ITEM C)


CLIENT:
 HENRY COUNTY
 BOARD OF EDUCATION

SHEET TITLE:
 ELECTRICAL NEW WORK
 LOW VOLTAGE PLAN -
 SECTOR "A" LOWER
 LEVEL

LU - 88
 P.T.E. : 1,887
 FACILITY CODE: 016-0408
 © 2018 Manley Spangler Smith Architects, PC

PROJECT NUMBER: 201731C
 DATE: 08.07.18
 SCALE: 1/8"=1'-0"
 DRAWN BY: AJS
 CHECKED BY: NHO

SHEET NO.: E302

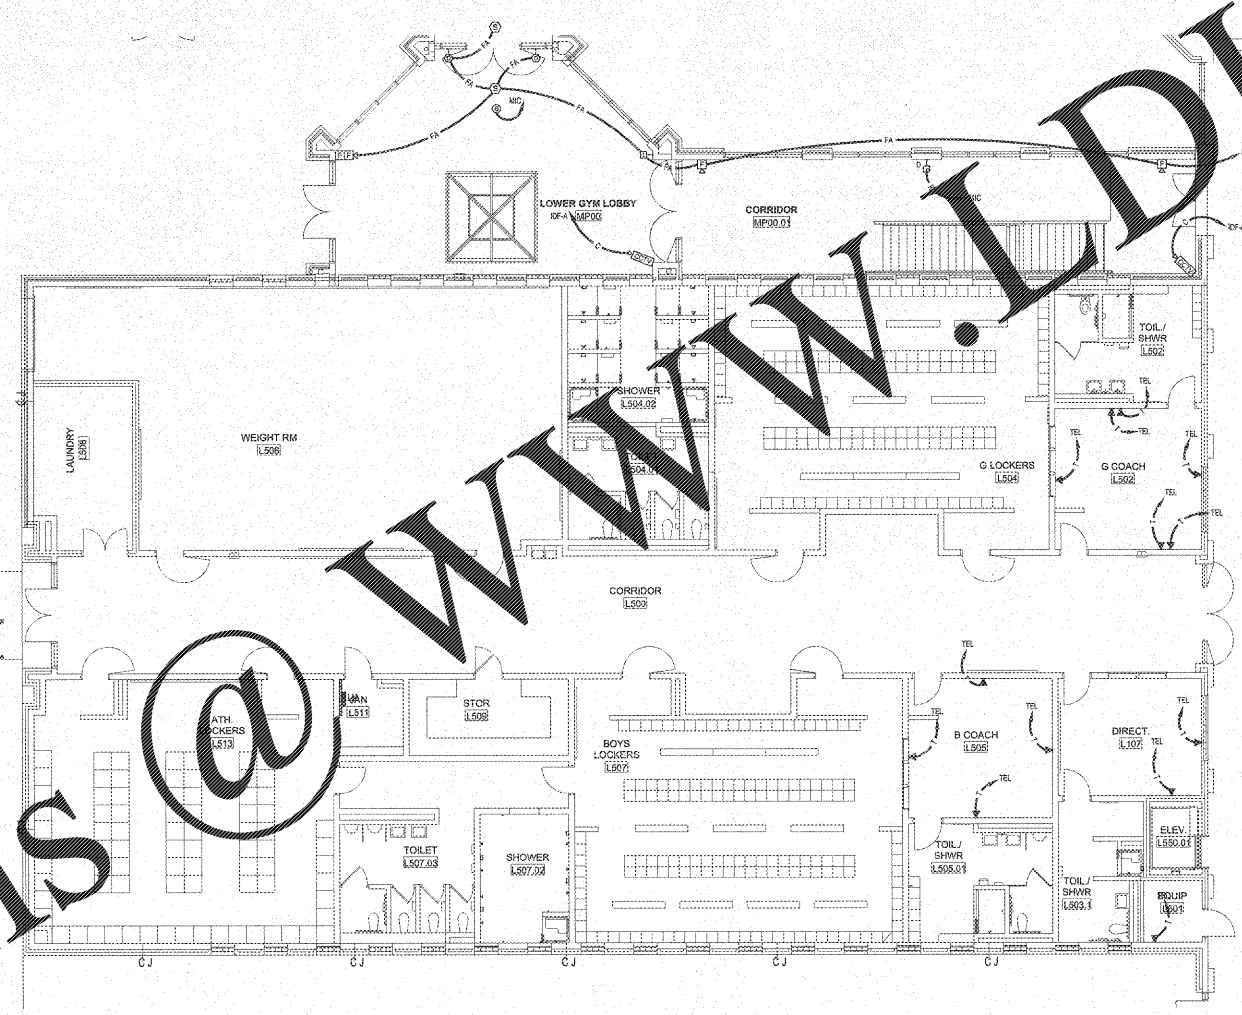

ELECTRICAL NEW WORK LOW VOLTAGE PLAN - SECTOR "A" LOWER LEVEL
 SCALE: 1/8"=1'-0"

GENERAL NOTES

- CONTRACTOR SHALL ROUTE VOICE, DATA AND OTHER SYSTEMS IN CONDUIT FROM WALL OUTLET TO ABOVE CORRIDOR CEILING. CABLES SHALL THEN BE ROUTED VIA JUNCTION AND EXISTING CABLE TRAY SYSTEM TO DESTINATION. JUNCTIONS SHALL BE INSTALLED ON BOTH SIDES OF CORRIDORS ON 4' CENTER TO ACCESS EXISTING CABLE TRAY SYSTEM ABOVE CORRIDOR CEILING.
- ALL LOW VOLTAGE SYSTEMS ROUTED OUTSIDE OF BUILDING SHALL HAVE LIGHTNING PROTECTION AND TO COVER CABLES AS IT ENTERS THE BUILDING.
- ELECTRICAL INSTALLATIONS ON EXISTING WALLS SHALL HAVE CIRCUITS REROUTED CONCEALED WITHIN MASONRY. CONTRACTOR SHALL NOT, UNDER ANY CIRCUMSTANCES, UTILIZE EXISTING METAL RINGWAYS TO INSTALL NEW CIRCUITS. RINGS SHALL BE CUT INTO EXISTING MASONRY WITH FLEX CONDUIT FINISHED IN EXISTING WALL FROM ABOVE ACCESSIBLE CEILING.

NOTE TO CONTRACTOR CONCERNING PROJECT PHASING:

THE WORK SHOWN ON THE DRAWINGS AND SPECIFICATIONS ILLUSTRATES THE COMPLETED CONTRACTUAL REQUIREMENTS. THIS PROJECT IS PHASED IN MULTIPLE PHASES. THE AREA OF EACH PHASE IS DESCRIBED IN THE ARCHITECTURAL DOCUMENTS AND THE CONTRACTOR SHALL REVIEW THESE PHASING REQUIREMENTS. CONTRACTOR SHALL INCLUDE IN HIS BID ALL COSTS REQUIRED TO ACCOMPLISH THE PROJECT IN PHASES. THE CONTRACT DOCUMENTS DO NOT DESCRIBE THE SPECIFIC WORK REQUIRED BY THE CONTRACTOR TO PERFORM THE PROJECT IN PHASES, BUT CONTRACTOR SHALL PREPARE PHASING PLAN AND SUBMIT TO ARCHITECT/ENGINEER AND HENRY COUNTY MAINTENANCE DEPARTMENT PRIOR TO BEGINNING WORK.

Order Plans @ WWW.LDILine.com