

In association with:

**LAWSON
 ELECTRIC
 WAREHOUSE**

for
 Lawson Electric
 at
 409 Spring Street, Chattanooga TN 37405

This drawing is the property of
 Franklin Associates Architects Inc.
 Any use, reuse, reproduction, display
 or sale of this drawing without the
 express written consent of the Architect
 is strictly prohibited.

Copyright © 2018 | franklin architects

Schematic
 Design


Revisions		
No.	Issue	Date

Sheet Information	
Date	06 July 2018
Job No.	6904
Title	


ARCHITECTURAL
 REFLECTED CEILING
 PLANS

Sheet

A700

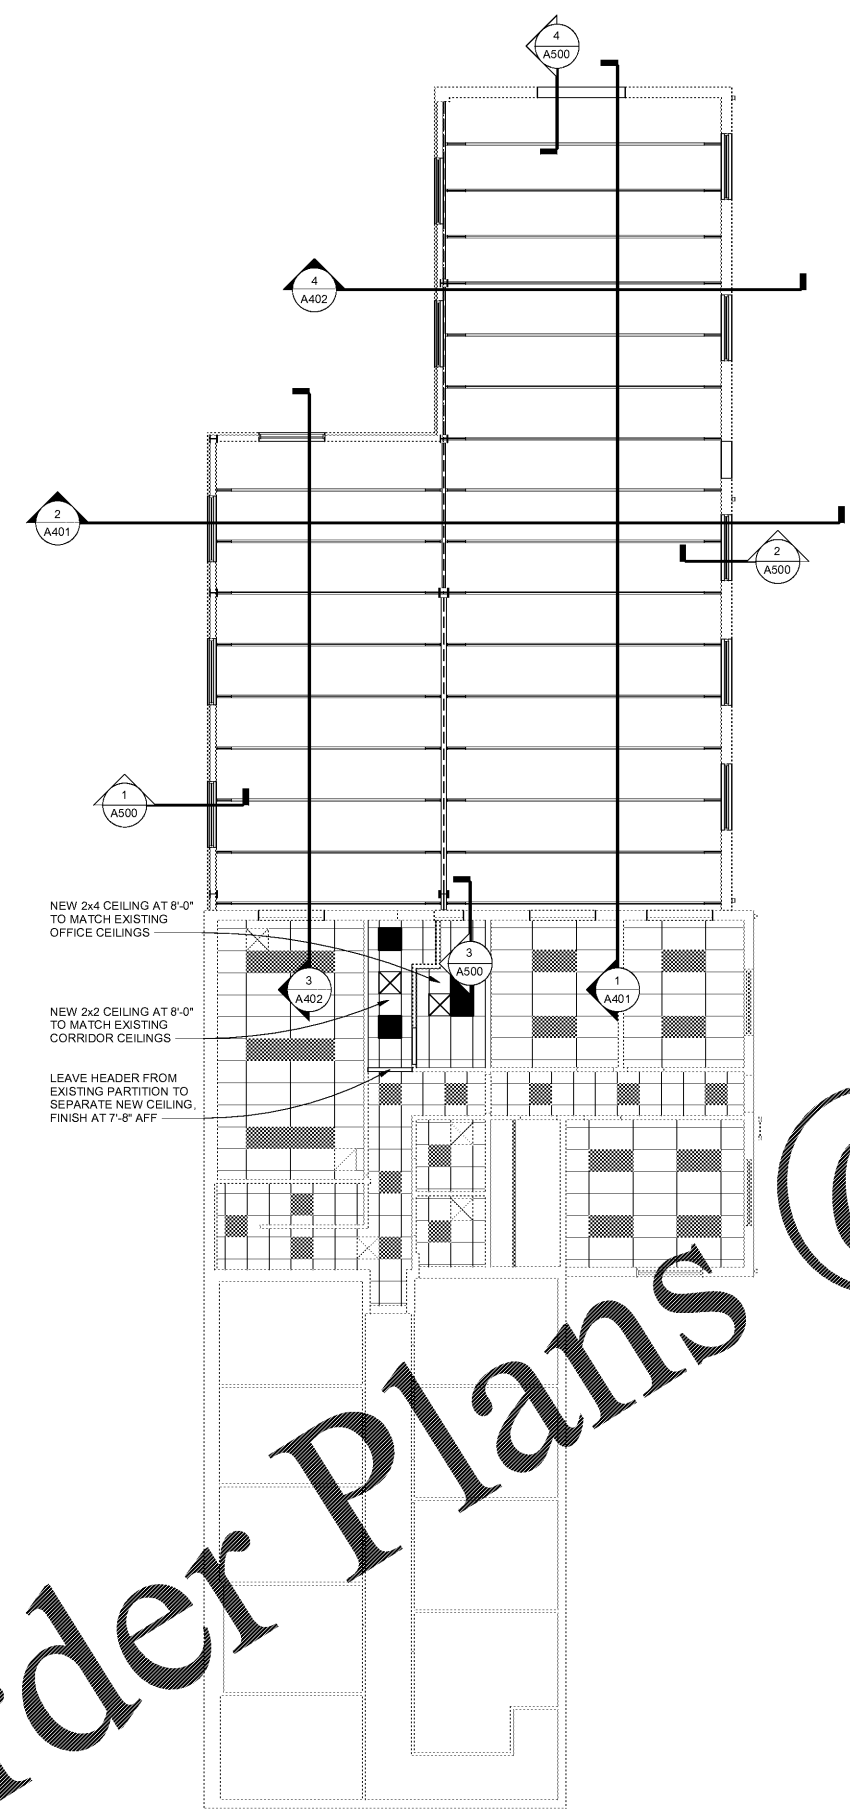

2 LEVEL 2 REFLECTED CEILING PLAN
 SCALE: 1/8" = 1'-0"

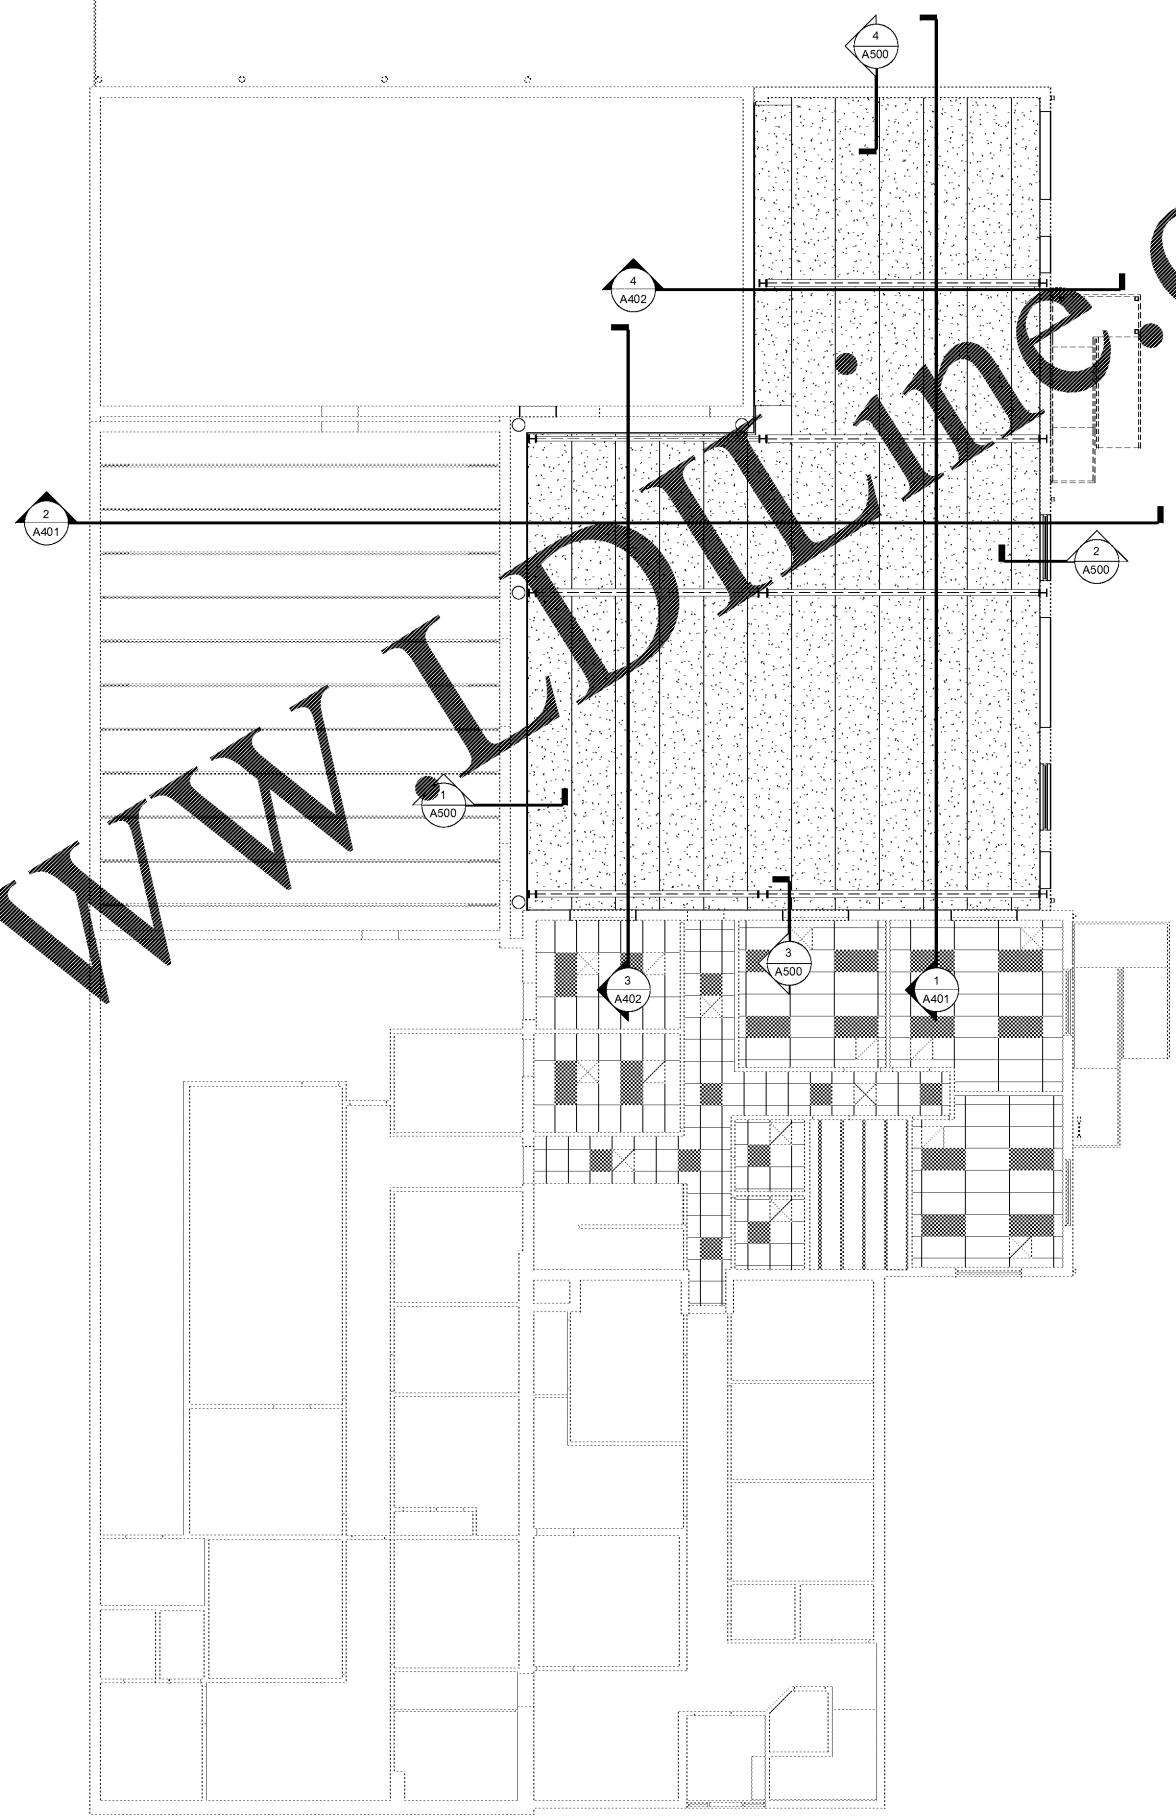

1 LEVEL 1 REFLECTED CEILING PLAN
 SCALE: 1/8" = 1'-0"

Last Plotted: 7/6/2018 11:27:43 AM

Order Plans @

WWW.LDLINE.COM