



Construct Second Floor Addition / Repair Interior

FGWB 08-0027, BUILDING 747
DOBBINS AIR RESERVE BASE, GA

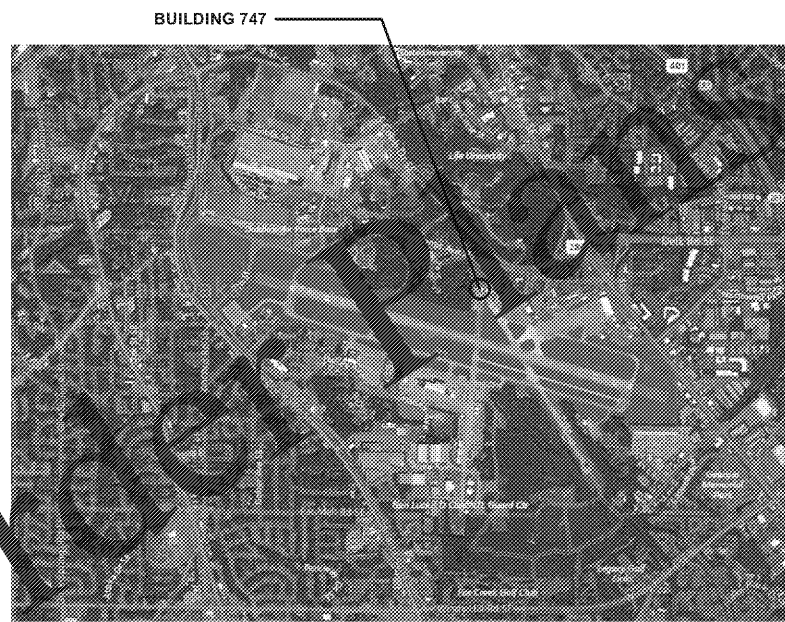

PLAN NORTH
1
G-001
PROJECT LOCATION
NTS

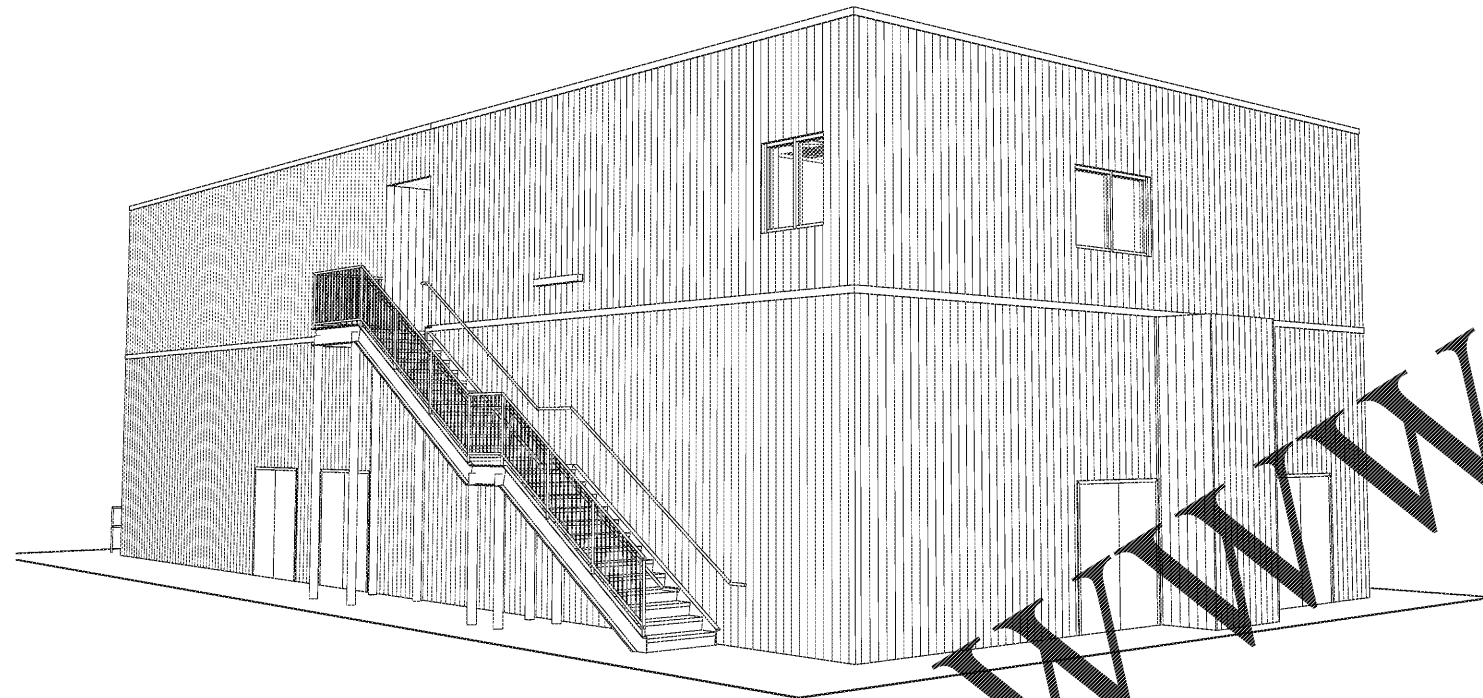


PLAN NORTH
2
G-001
VICINITY MAP
NTS

DRAWING INDEX		ISS A - 2017-11-03 - 10% CONCEPT DESIGN	ISS B - 2017-12-22 - 66% SUBMITTAL	ISS C - 2018-02-23 - 95% SUBMITTAL	ISS D - 2018-04-13 - FOR CONSTRUCTION	ISS E - 2018-06-01 - FOR CONSTRUCTION
NUMBER	SHEET # OF 45 SHEETS	SHEET NAME				
GENERAL						
G-001	1	COVER SHEET	X	X	X	X
G-002	2	GENERAL INFORMATION	X	X	X	X
LS-101	3	LIFE SAFETY PLANS	X	X	X	X
STRUCTURAL						
S-001	4	GENERAL NOTES	X	X	X	X
S-002	5	GENERAL SCHEDULES	X	X	X	X
S-101	6	ROOF FRAMING PLAN	X	X	X	X
S-201	7	BRACED FRAME ELEVATIONS	X	X	X	X
S-301	8	SECTIONS & DETAILS	X	X	X	X
S-401	9	STAIR PLAN & DETAILS	X	X	X	X
S-601	10	DIAGRAMS	X	X	X	X
DEMOLITION						
AD101	11	DEMO PLAN - FIRST FLOOR	X	X	X	X
AD102	12	DEMO PLAN - SECOND FLOOR	X	X	X	X
ARCHITECTURAL						
A-001	13	PARTITION TYPES & HEAD CONDITIONS	X	X	X	X
A-101	14	OVERALL FLOOR PLAN - FIRST FLOOR	X	X	X	X
A-102	15	OVERALL FLOOR PLAN - SECOND FLOOR	X	X	X	X
A-103	16	FLOOR PLAN - SECOND FLOOR - CLASSROOM ADDITION	X	X	X	X
A-104	17	FLOOR PLAN - CLASSROOM ADDITION DECK LEVEL	X	X	X	X
A-131	18	REFLECTED CEILING PLAN - SECOND FLOOR - CLASSROOM ADDITION	X	X	X	X
A-201	19	CLASSROOM ADDITION ELEVATIONS	X	X	X	X
A-202	20	CLASSROOM ADDITION ELEVATIONS	X	X	X	X
A-301	21	BUILDING SECTIONS	X	X	X	X
A-302	22	BUILDING SECTIONS	X	X	X	X
A-311	23	WALL SECTIONS	X	X	X	X
A-351	24	SECTION DETAILS	X	X	X	X
A-451	25	PLAN DETAILS	X	X	X	X
A-501	26	STAIR DETAILS	X	X	X	X
A-601	27	DOOR AND WINDOW DETAILS	X	X	X	X
INTERIORS						
IF001	28	ROOM FINISH SCHEDULE & FINISH MATERIAL SPECS	X	X	X	X
IF101	29	FLOOR & WALL FINISH PLAN - FIRST FLOOR	X	X	X	X
IF102	30	FLOOR FINISH PLAN - SECOND FLOOR	X	X	X	X
IE101	31	EQUIPMENT LOCATION PLAN- FIRST FLOOR	X	X	X	X
IE102	32	EQUIPMENT LOCATION PLAN- SECOND FLOOR	X	X	X	X
IS101	33	SIGNAGE LOCATION PLAN- FIRST FLOOR	X	X	X	X
IS102	34	SIGNAGE LOCATION PLAN- SECOND FLOOR	X	X	X	X
FIRE PROTECTION						
FA-201	35	OVERALL FLOOR PLAN - LEVEL 2 FIRE ALARM	X	X	X	X
FA-501	36	DETAILS - FIRE ALARM	X	X	X	X
FX-101	37	OVERALL FLOOR PLAN - LEVEL 2 FIRE PROTECTION	X	X	X	X
MECHANICAL						
M-101	38	MECHANICAL PLAN - SECOND FLOOR	X	X	X	X
M-501	39	MECHANICAL DETAILS	X	X	X	X
M-601	40	MECHANICAL SCHEDULES	X	X	X	X
ELECTRICAL						
E-001	41	ELECTRICAL GENERAL NOTES	X	X	X	X
E-101	42	EXISTING OVERALL FLOOR PLAN - DEMO	X	X	X	X
E-102	43	NEW OVERALL FLOOR PLAN - ELECTRICAL	X	X	X	X
E-401	44	NEW LEVEL TWO FLOOR PLAN - ELECTRICAL	X	X	X	X
E-601	45	ELECTRICAL DETAILS AND SCHEDULES	X	X	X	X
Grand total: 45						

REV.	DATE BY	DESCRIPTION
A	2017-11-03	10% CONCEPT DESIGN
B	2017-12-22	66% SUBMITTAL
C	2018-02-23	95% SUBMITTAL
D	2018-04-13	FOR CONSTRUCTION
E	2018-06-01	FOR CONSTRUCTION



CIVIL ENGINEERING
94th AIRLIFT WING
DOBBINS AIR RESERVE BASE, GEORGIA

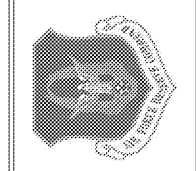

CROFT & Associates
3400 Blue Springs Road,
Suite 200
Kennesaw, GA 30144
770.529.7744 (o)
770.529.7744 (f)
www.croftaa.com



REPAIR FACILITY & ADDITION
BUILDING 747
FGWB 08-0027
DOBBINS AIR RESERVE BASE, GEORGIA

PROJECT	LOCATION	DRAWING	CONTRACT
PROJECT No:	2017-238		
PROJ. OFFICER:	J MORGAN		
DESIGNED:	M. GUNN		
CHECKED:	J MORGAN		
DATE:	2018-06-01		

DRAWING 1 OF 45
G-001