


CONSTRUCTION DOCS.		
REV.	DATE	DESCRIPTION
0	2018-04-13	FOR CONSTRUCTION

**GENERAL NOTES**

1. SEE SHEET FA-501 FOR FIRE ALARM NOTES AND DETAILS.
2. NEW FIRE ALARM DEVICES WILL BE CONNECTED TO THE EXISTING FIRE ALARM SYSTEM.

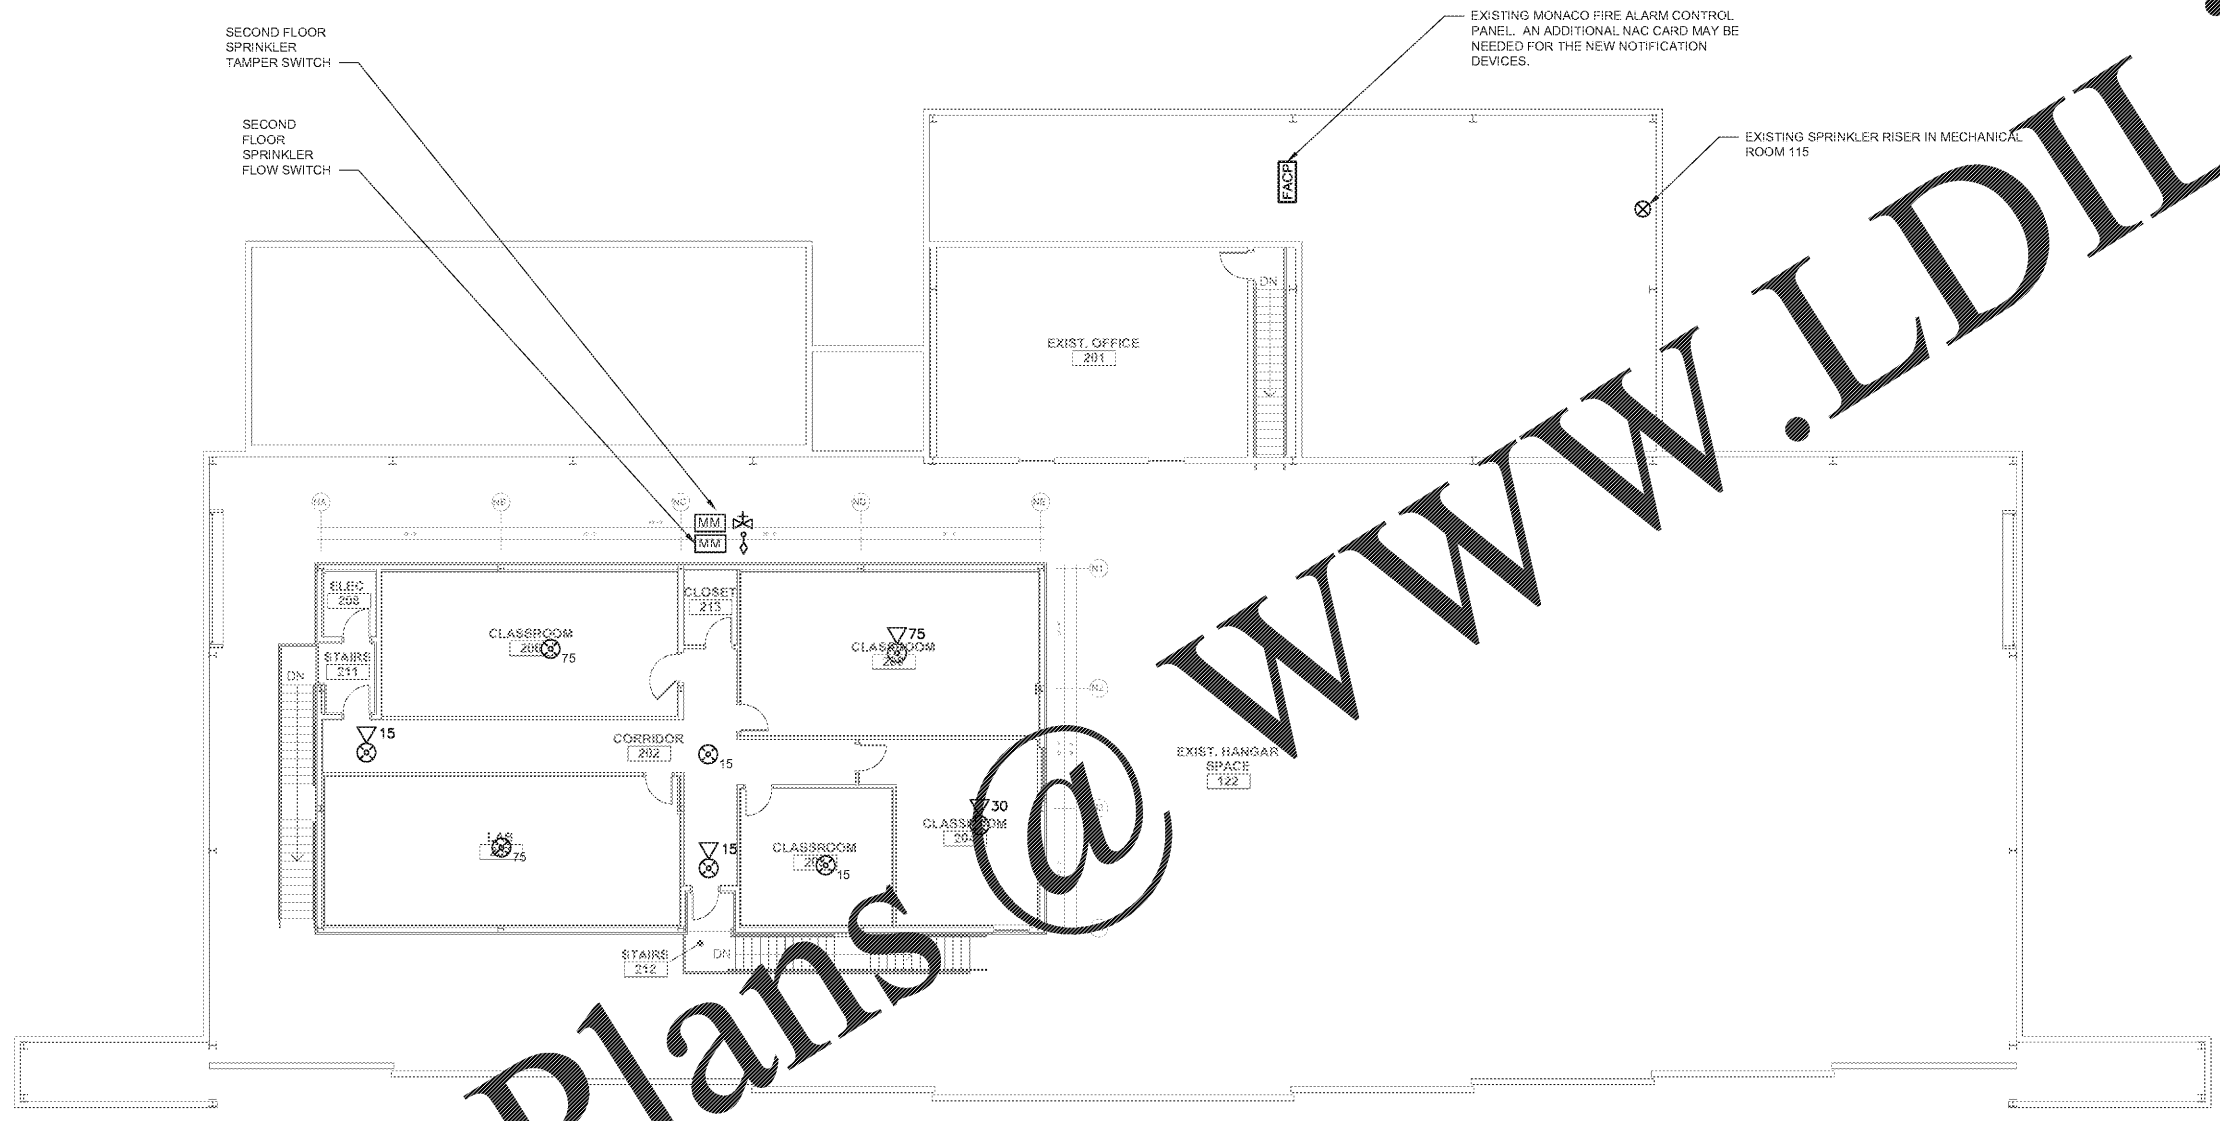

WWW.LDILine.com

 
Order Plans @

**LEGEND**

- FIRE ALARM HORN / STROBE (CEILING-MOUNTED)
- FIRE ALARM STROBE (CEILING-MOUNTED)
- TAMPER SWITCH
- WATERFLOW SWITCH
- MONITOR MODULE
- FIRE ALARM CONTROL PANEL



PLAN NORTH  
1 OVERALL FLOOR PLAN - LEVEL 2 - FIRE ALARM  
FA-201  
3/32" = 1'-0"



CIVIL ENGINEERING  
94th AIRLIFT WING  
DOBBINS AIR RESERVE BASE, GEORGIA

**CROFT**  
Croft & Associates  
6400 Blue Springs Road,  
Suite 200  
Kennesaw, GA 30144  
770.226.7144 (G)  
770.226.7716 (F)  
www.croftco.com

**CONSTRUCT SECOND FLOOR ADDITION**  
**BUILDING 747**  
FGWB 08-0027  
DOBBINS AIR RESERVE BASE, GEORGIA  
**OVERALL FLOOR PLAN - LEVEL 2**  
**OVERALL FIRE ALARM**  
PROJECT CONTACT:  
DORIS STAMPS - 678-956-9618  
DORIS@CROFTCO.COM

PROJECT	LOCATION	DRAWING	CONTACT
PROJECT No.	FGWB 08-0027		
PROJ. OFFICER	J. MORGAN		
DESIGNED	A. POMEROY		
CHECKED	K. POTHIER		
DATE	23 FEB, 2018		
DRAWING	35 OF 45		

FILE NAME: R:\Projects\2017\17144 - Croft Dobbin Base 747\Drawings\17144\_FX.dwg LAYOUT NAME: FA-201 PLOT/DWG: Friday, April 06, 2018 - 10:55am USER: hrcym