



Order Plans @

WWW.IDLINE.COM

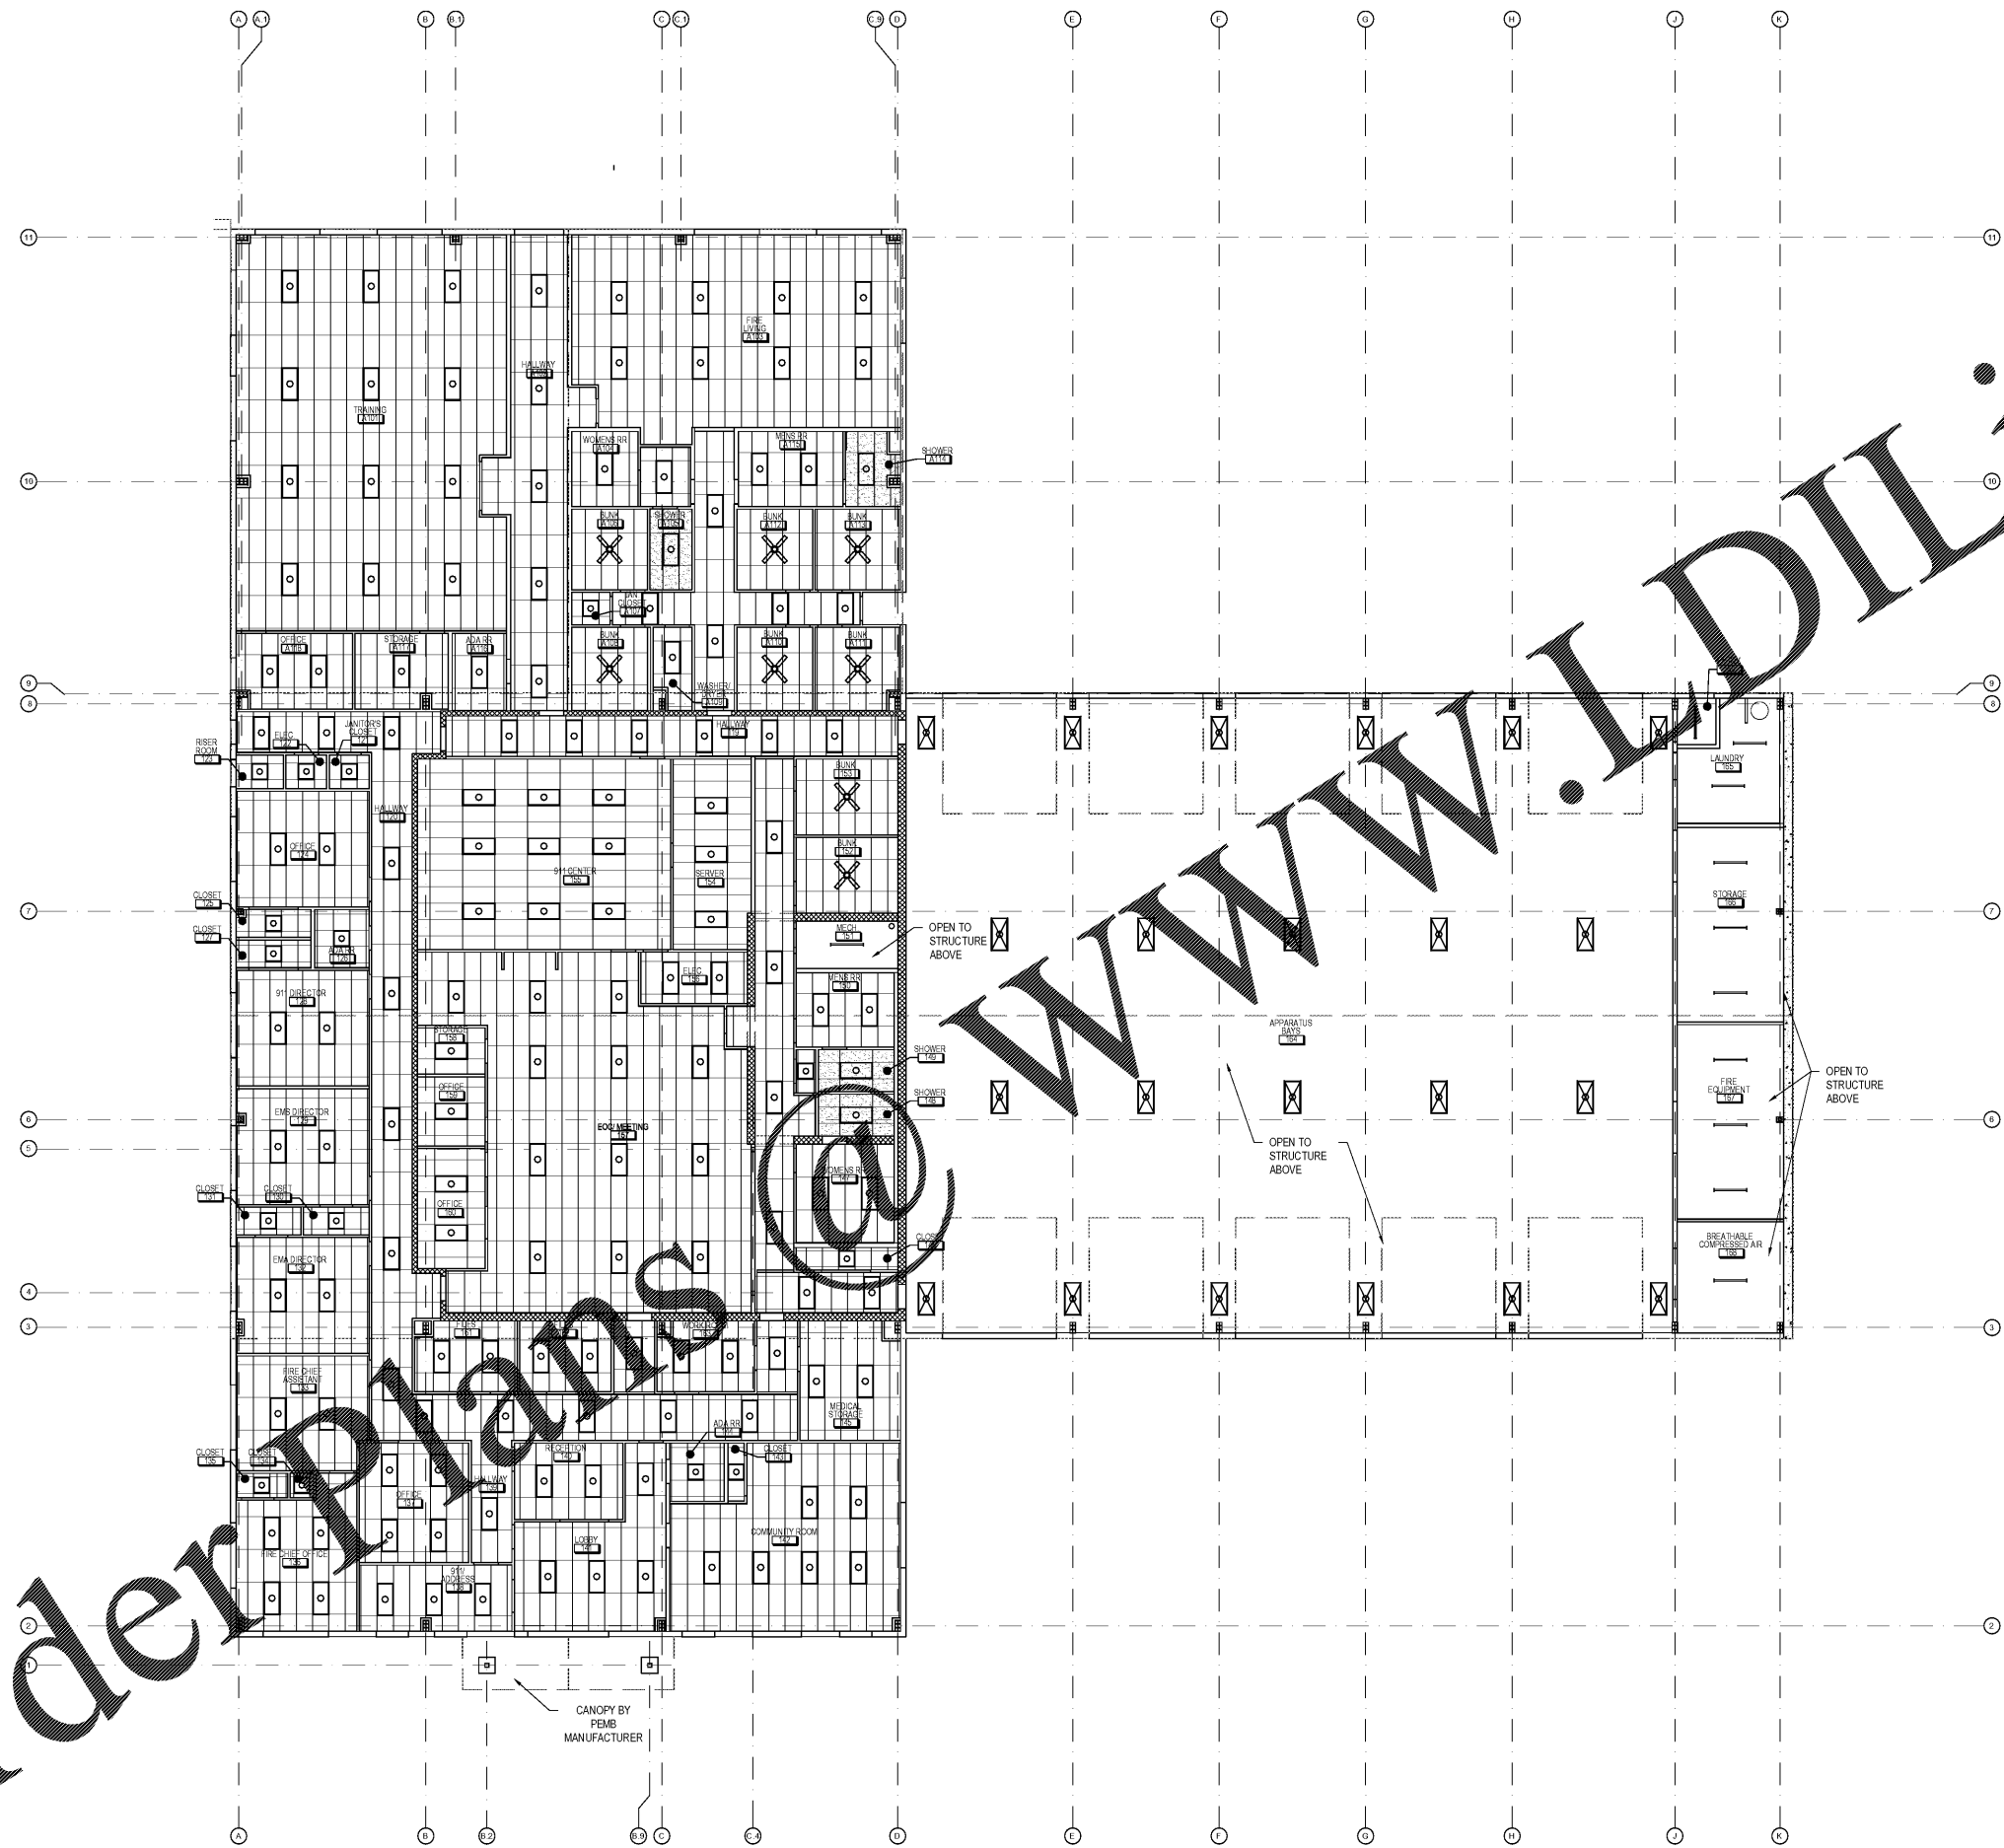

RCP LEGEND	
	2' X 4' X 5/8" ACOUSTICAL CEILING TILE
	USG RADAR CERAMIC FIRECODE 2' X 4' X 5/8" ACOUSTICAL CEILING TILE
	24" X 48" LAY-IN LED LIGHT FIXTURE
	24" X 48" HIGH BAY LED LIGHT FIXTURE
	SURFACE MOUNTED LINEAR LIGHT FIXTURE
	24" X 24" LAY-IN LED LIGHT FIXTURE
	INTEGRAL LIGHT

- GENERAL CEILING NOTES**
1. CEILING TO BE 9'-0" AFF UNLESS NOTED OTHERWISE.
  2. REFER TO ELECTRICAL DRAWINGS FOR ADDITIONAL LIGHTING INFORMATION.

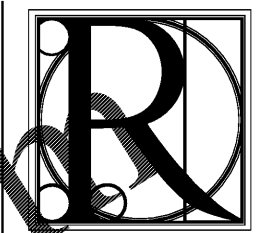

**DESIGN WORKS**

FANNIN COUNTY:  
722 Black Dog Trail  
P.O. Box 639  
Blue Ridge, GA 30513  
Phone 706.374.4304

COBB COUNTY:  
1480 Shiloh Road NW  
Suite #300  
Kennesaw, GA 30144  
Phone 770.790.3655  
Fax 770.790.3650

TITLE: REFLECTED CEILING PLAN

 
PROJECT: FANNIN CO. PUBLIC SAFETY COMPLEX  
964 WINDY RIDGE ROAD  
BLUE RIDGE, GA 30513

ISSUE:	REVISIONS:

SEAL



DRAWN BY:	DATE:
K.W.	4.19.2017
PROJECT NO:	SHEET NO.:
1517	A-2.1



A 3/32" REFLECTED CEILING PLAN  
1'-0"