

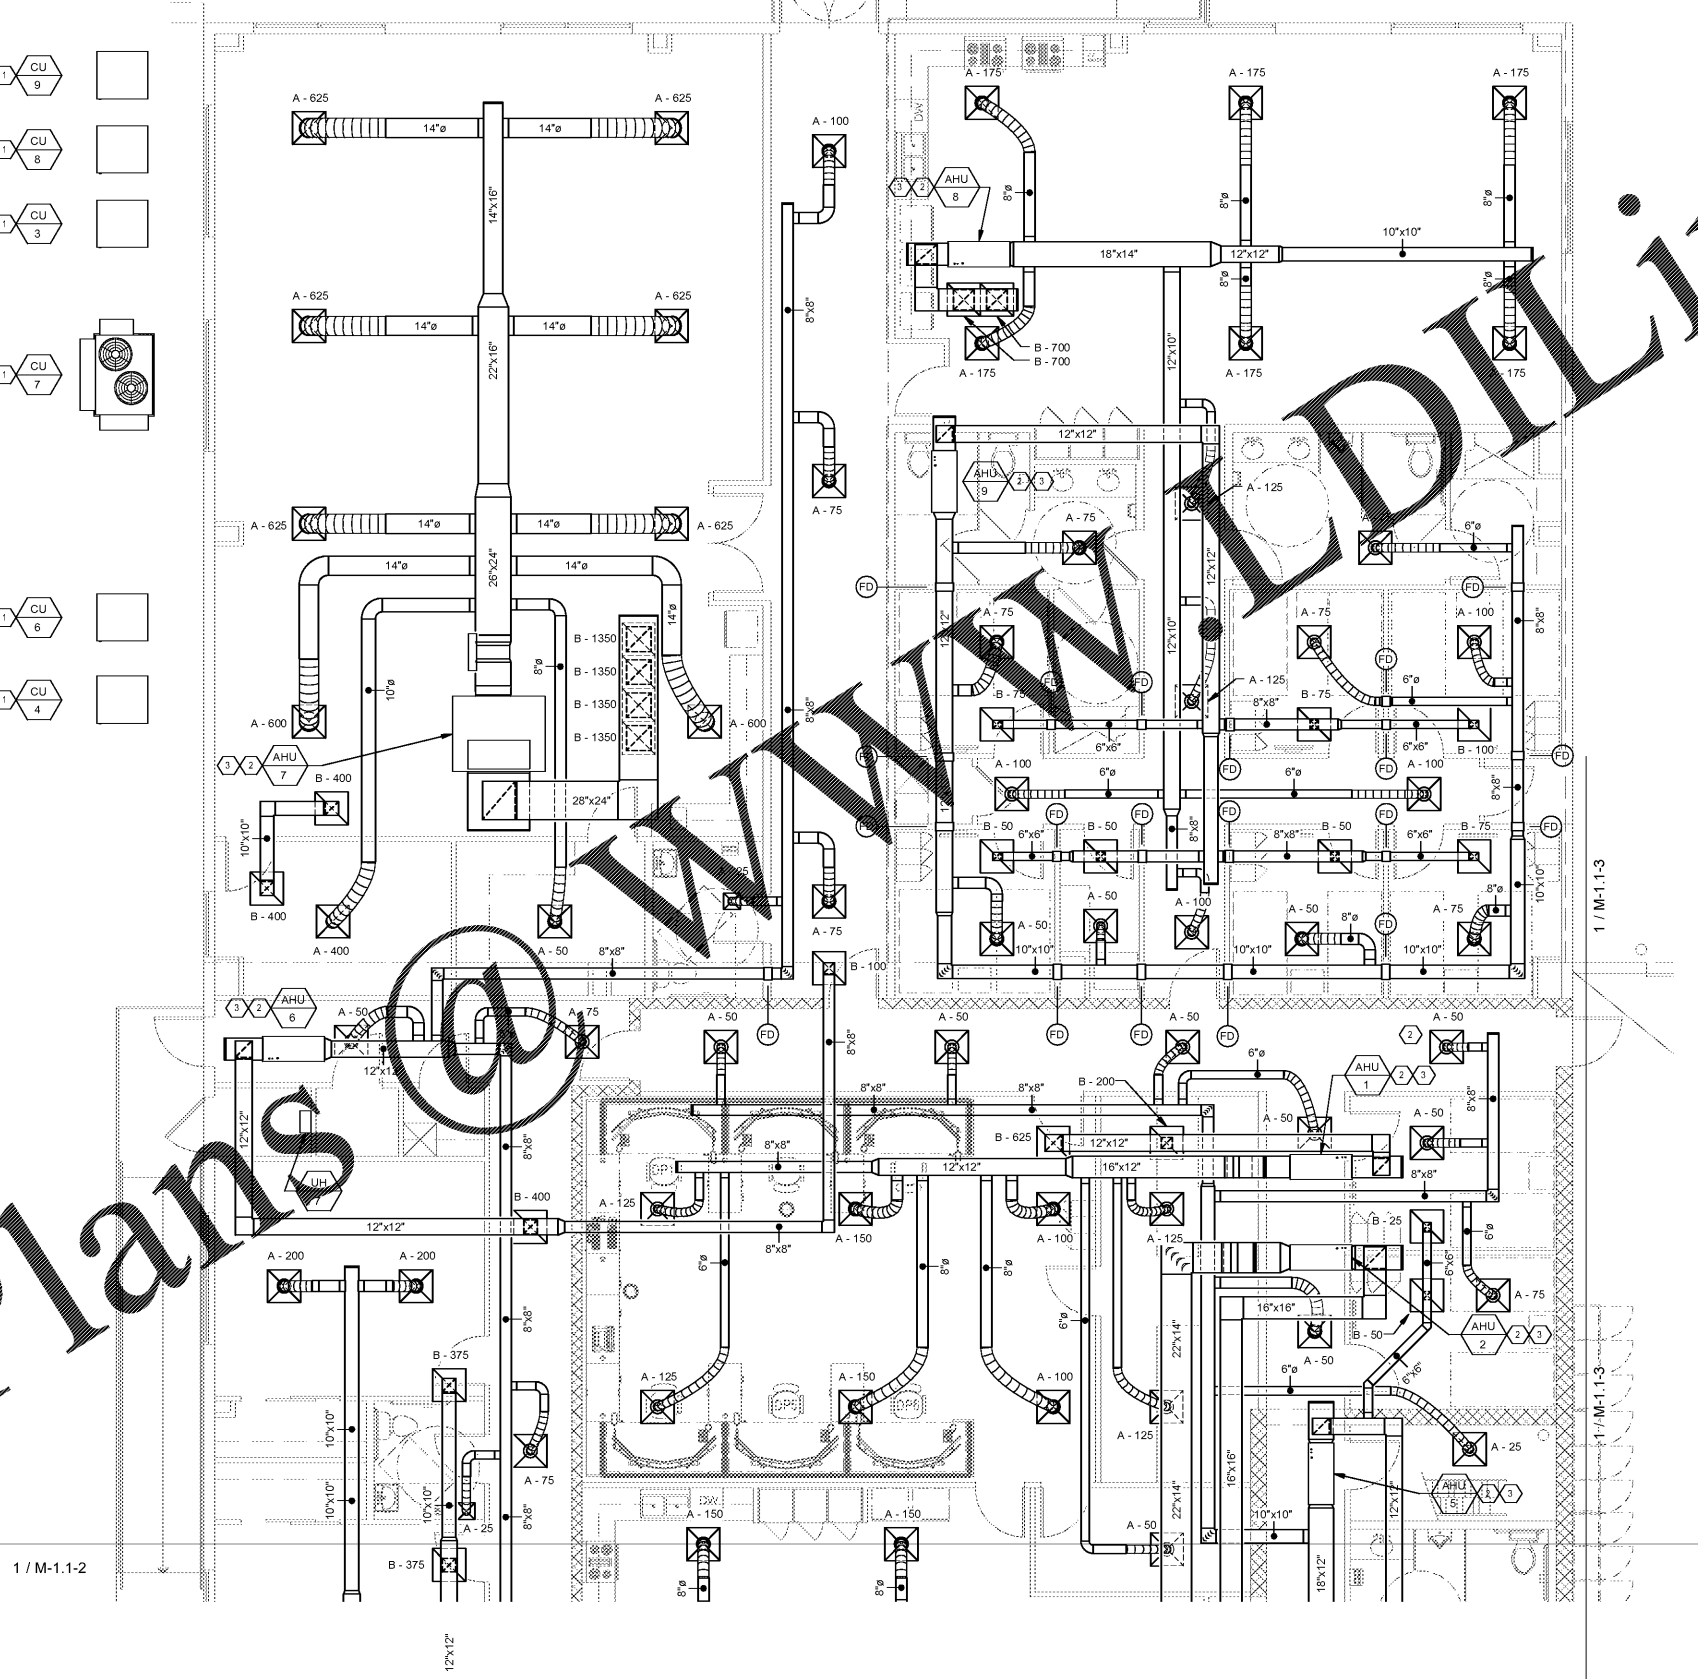


Order Plans

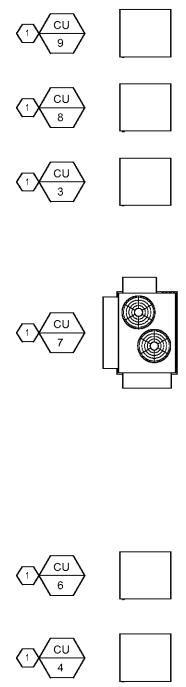

- H.V.A.C. SHEET NOTES**
1. PROVIDE CONCRETE HOUSING FOR CONDENSING UNIT. PAD SHALL EXTEND MINIMUM 6" BEYOND THE EDGE OF CONDENSING UNIT.
 2. ROUTE REFRIGERANT LINES FROM AIR HANDLING UNIT WITHIN ATTIC DOWN IN EXTERIOR WALL AND TERMINATE AT CONDENSING UNIT.
 3. ROUTE FULL SIZE PVC CONDENSATE DRAIN LINE FROM AHU IN ATTIC WITH P-TRAP DOWN IN EXTERIOR WALL AND TERMINATE 8" ABOVE FINISHED GRADE WITH TURNED DOWN ELBOW.

- HVAC LEGEND:**
- SUPPLY DIFFUSER
 - RETURN AIR GRILLE
 - EXHAUST AIR GRILLE
 - RIGID DUCTWORK (WIDTH/DEPTH)
 - FLEX DUCTWORK (DIAMETER)
 - ELBOW WITH TURNING VANES
 - MANUAL VOLUME DAMPER
 - ⊙ DUCT MOUNTED SMOKE DETECTOR
 - ⊙ THERMOSTAT

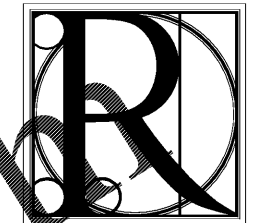

DESIGN WORKS

FANNIN COUNTY:
722 Black Dog Trail
P.O. Box 639
Blue Ridge, GA 30513
Phone 706.374.4304

COBB COUNTY:
1480 Shiloh Road NW
Suite #300
Kennesaw, GA 30144
Phone 770.790.3655
Fax 770.790.3650

SAVANT Engineering, LLC

5064 Roswell Road, Suite D-301
Sandy Springs, GA 30342 770.319.7400
Project 16047 ©2016

TITLE: SUPPLY & RETURN
PROJECT: FANNIN CO. PUBLIC SAFETY COMPLEX
BLUE RIDGE, GA 30513

ISSUE:	REVISIONS:



DRAWN BY: MSC/RGV	DATE: 04.19.2017
----------------------	---------------------

PROJECT NO. 1517	SHEET NO. M-1.1-1
---------------------	----------------------

1 FLOOR PLAN - H.V.A.C. - SUPPLY & RETURN - NORTH
3/16" = 1'-0"