


Order Plans

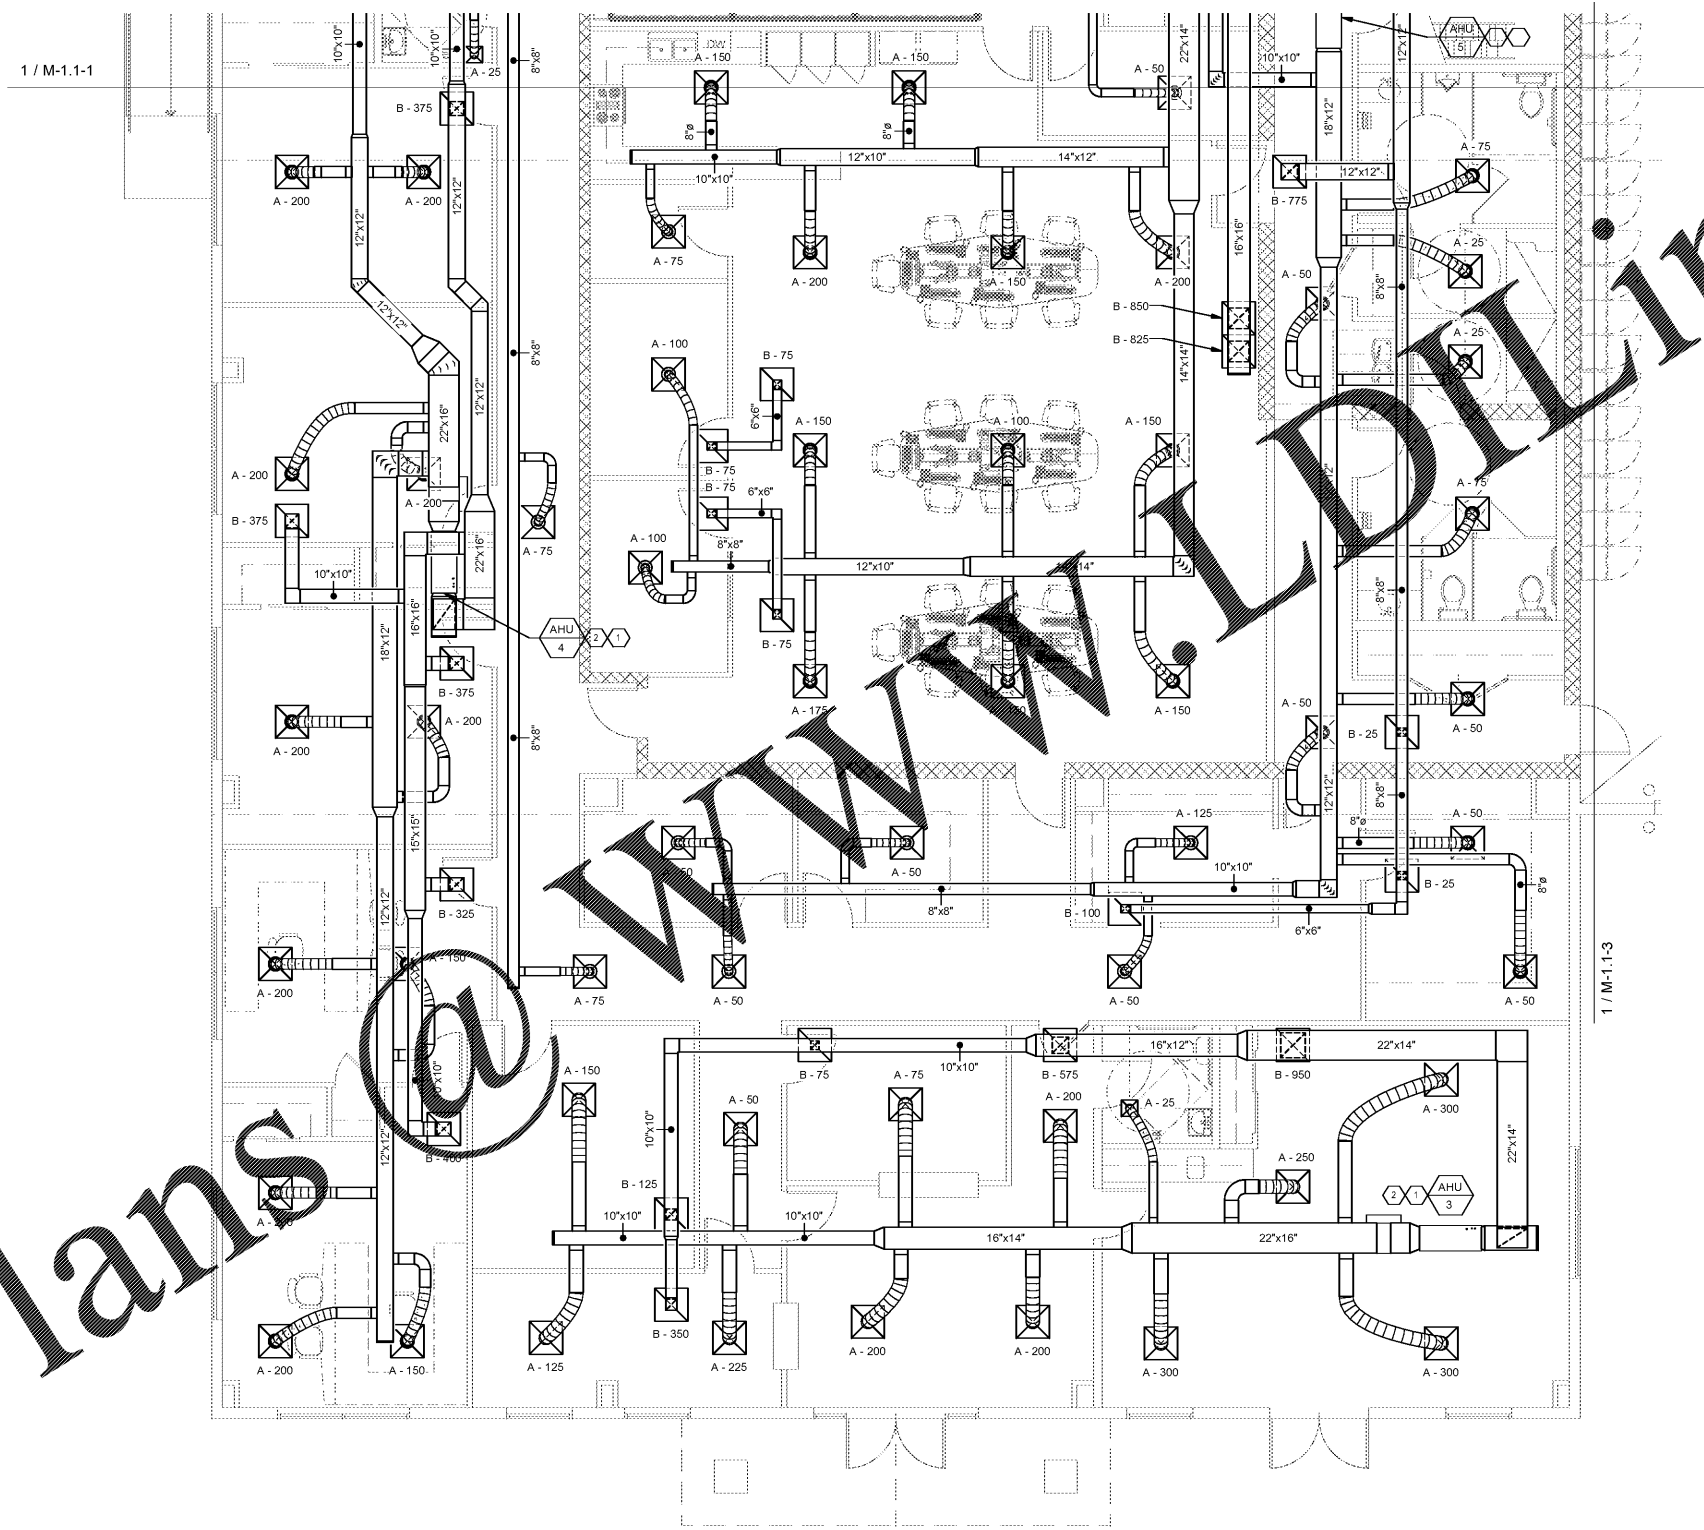


H.V.A.C. SHEET NOTES

1. ROUTE CONDENSATE DRAIN FROM EACH AHU TO AN ATTIC WITH P-TRAP DOWN TO EXTERIOR WALL AND TERMINATE 8" ABOVE FINISHED GRADE WITH TURNED DOWN ELBOW.

2. ROUTE REFRIGERANT LINES FROM AIR HANDLING UNIT WITHIN ATTIC DOWN IN EXTERIOR WALL AND TERMINATE AT CONDENSING UNIT.

1 FLOOR PLAN - H.V.A.C. - SUPPLY & RETURN - SOUTH
 M-1.1-2 3/16" = 1'-0"

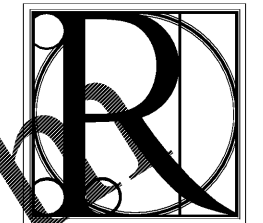

DESIGN WORKS

FANNIN COUNTY:
 722 Black Dog Trail
 P.O. Box 639
 Blue Ridge, GA 30513
 Phone 706.374.4304

COBB COUNTY:
 1480 Shiloh Road NW
 Suite #300
 Kennesaw, GA 30144
 Phone 770.790.3655
 Fax 770.790.3650

SAVANT
 Engineering, LLC

5064 Roswell Road, Suite D-301
 Sandy Springs, GA 30342 770.319.7400
 Project 16047 ©2016

TITLE: SUPPLY & RETURN

PROJECT: FANNIN CO. PUBLIC SAFETY COMPLEX
 BLUE RIDGE, GA 30513

ISSUE:	REVISIONS:

SEAL



DRAWN BY/ CHECKED BY:	DATE:
MSC/RGV	04.19.2017

PROJECT NO.	SHEET NO.:
1517	M-1.1-2