
 



SWITCH BANK 1:

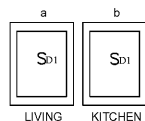


SWITCH BANK 3:




SWITCH BANK 6:

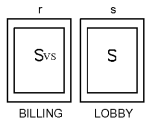


SWITCH BANK 2:

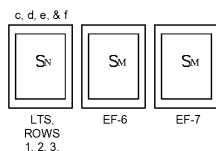


SWITCH BANK 4:

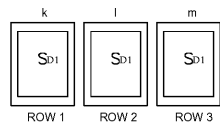


EXAMPLE SWITCH:

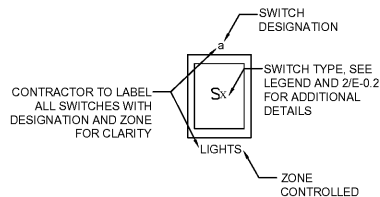

SWITCH BANK 5:

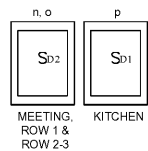


NOT SHOWN: SWITCH 'u'. SEE LIGHTING PLAN AND KEYNOTES.

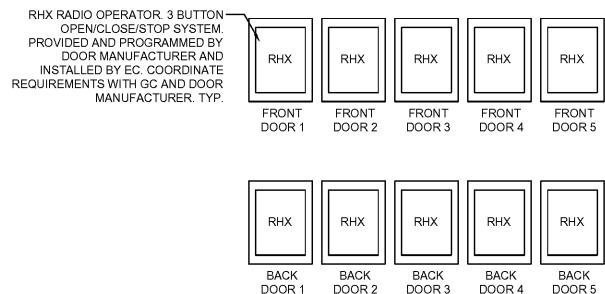

1 SWITCH BANK DETAIL SCALE: NOT TO SCALE

Table with 5 columns: DESIG, CIRCUITS CONTROLLED, TYPE, POLES, SCHEDULE. Rows include C1, C2, and C3.

Table with 3 columns: ZONE, SWITCHES CONTROLLED, SCHEDULE. Rows include 1, 2, and 3.

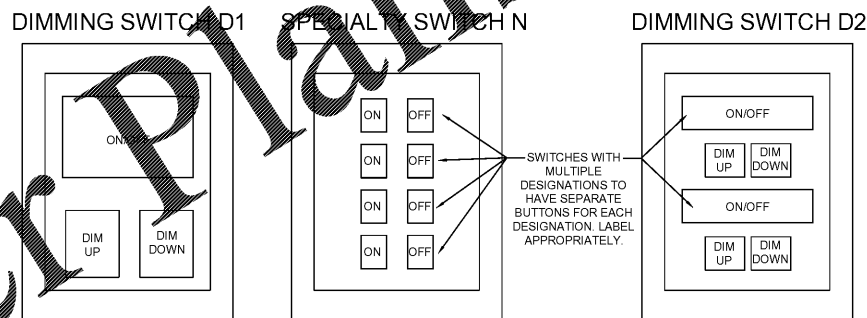

2 NPODM SWITCH DETAIL SCALE: NOT TO SCALE

BUILDING LIGHTING FIXTURE SCHEDULE

Table with 7 columns: TYPE, MANUFACTURER, CATALOG NUMBER, VOLT, LAMP, MOUNTING, COMMENTS. Lists various lighting fixtures like A1, A2, A3, B1, B2, etc.

- LIGHTING SCHEDULE NOTES: 1. FINISH SELECTED BY ARCHITECT. 2. PROVIDE WITH AIRCRAFT CABLE HANGER AS NEEDED... 3. MOUNT DIRECTLY ABOVE APPARATUS BAY ROLL UP DOOR... 4. MOUNTED 6" ABOVE DOOR. 5. SEE ARCHITECTURAL ELEVATIONS FOR MOUNTING HEIGHT. 6. PROVIDE WALL MOUNT ACCESSORY IF REQUIRED.


- NOTES FOR ALL FIXTURES: 1. IF ALTERNATES ARE SUBMITTED FOR ANY FIXTURES SPECIFIED ABOVE, CONTRACTOR MUST DEMONSTRATE THAT ALTERNATES WILL PROVIDE THE SAME FORM AND FUNCTION, AND MEET THE OWNER'S NEEDS...

MECHANICAL SCHEDULE NOTES:

- 1. PROVIDE OVERCURRENT PROTECTION AND BREAKERS PER UL LISTED REQUIREMENTS FOR EQUIPMENT SERVED... 2. SMOKE DETECTORS SHALL BE PROVIDED BY MECHANICAL CONTRACTOR... 3. EXHAUST FAN TO LOCAL LIGHTING CIRCUIT WITHIN THIS ROOM... 4. CONTROLLED BY CONTROL PANEL IN SWITCHBANK 2. 5. COORDINATE CONTROLS REQUIREMENTS WITH HVAC CONTRACTOR. 6. TO BE INSTALLED NEXT TO ASSOCIATED AIR HANDLING UNIT. 7. TO BE CONTROLLED BY TIMER PROVIDED BY HVAC CONTRACTOR. TIE TO LOCAL LIGHTING CIRCUIT. 8. FAN TO RUN CONTINUOUSLY.

MECHANICAL EQUIPMENT CONNECTION SCHEDULE

Table with 6 columns: EQUIPMENT, CIRCUIT DESIGNATION, FEEDER, DISCONNECT, LOAD, NOTES. Lists mechanical equipment like AHU-1, AHU-2, CU-1, etc.

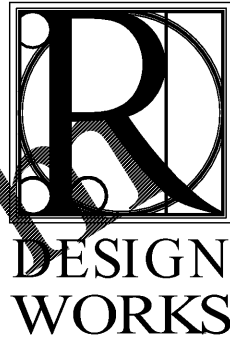

FANNIN COUNTY: 722 Black Dog Trail P.O. Box 639 Blue Ridge, GA 30513 Phone 706.374.4304

COBB COUNTY: 1480 Shiloh Road NW Suite #300 Kennesaw, GA 30144 Phone 770.790.3655 Fax 770.790.3650



SCHEDULES AND DETAILS - ELECTRICAL
PROJECT: FANNIN CO. PUBLIC SAFETY COMPLEX 964 WINDY RIDGE ROAD BLUE RIDGE, GA 30513

Table with 2 columns: ISSUE, REVISIONS.



DRAWN BY / CHECKED BY: IJC/SWL DATE: 4.19.2017 PROJECT NO. SHEET NO.: 1517 E-0.2

Order Plans