



Order Plans @

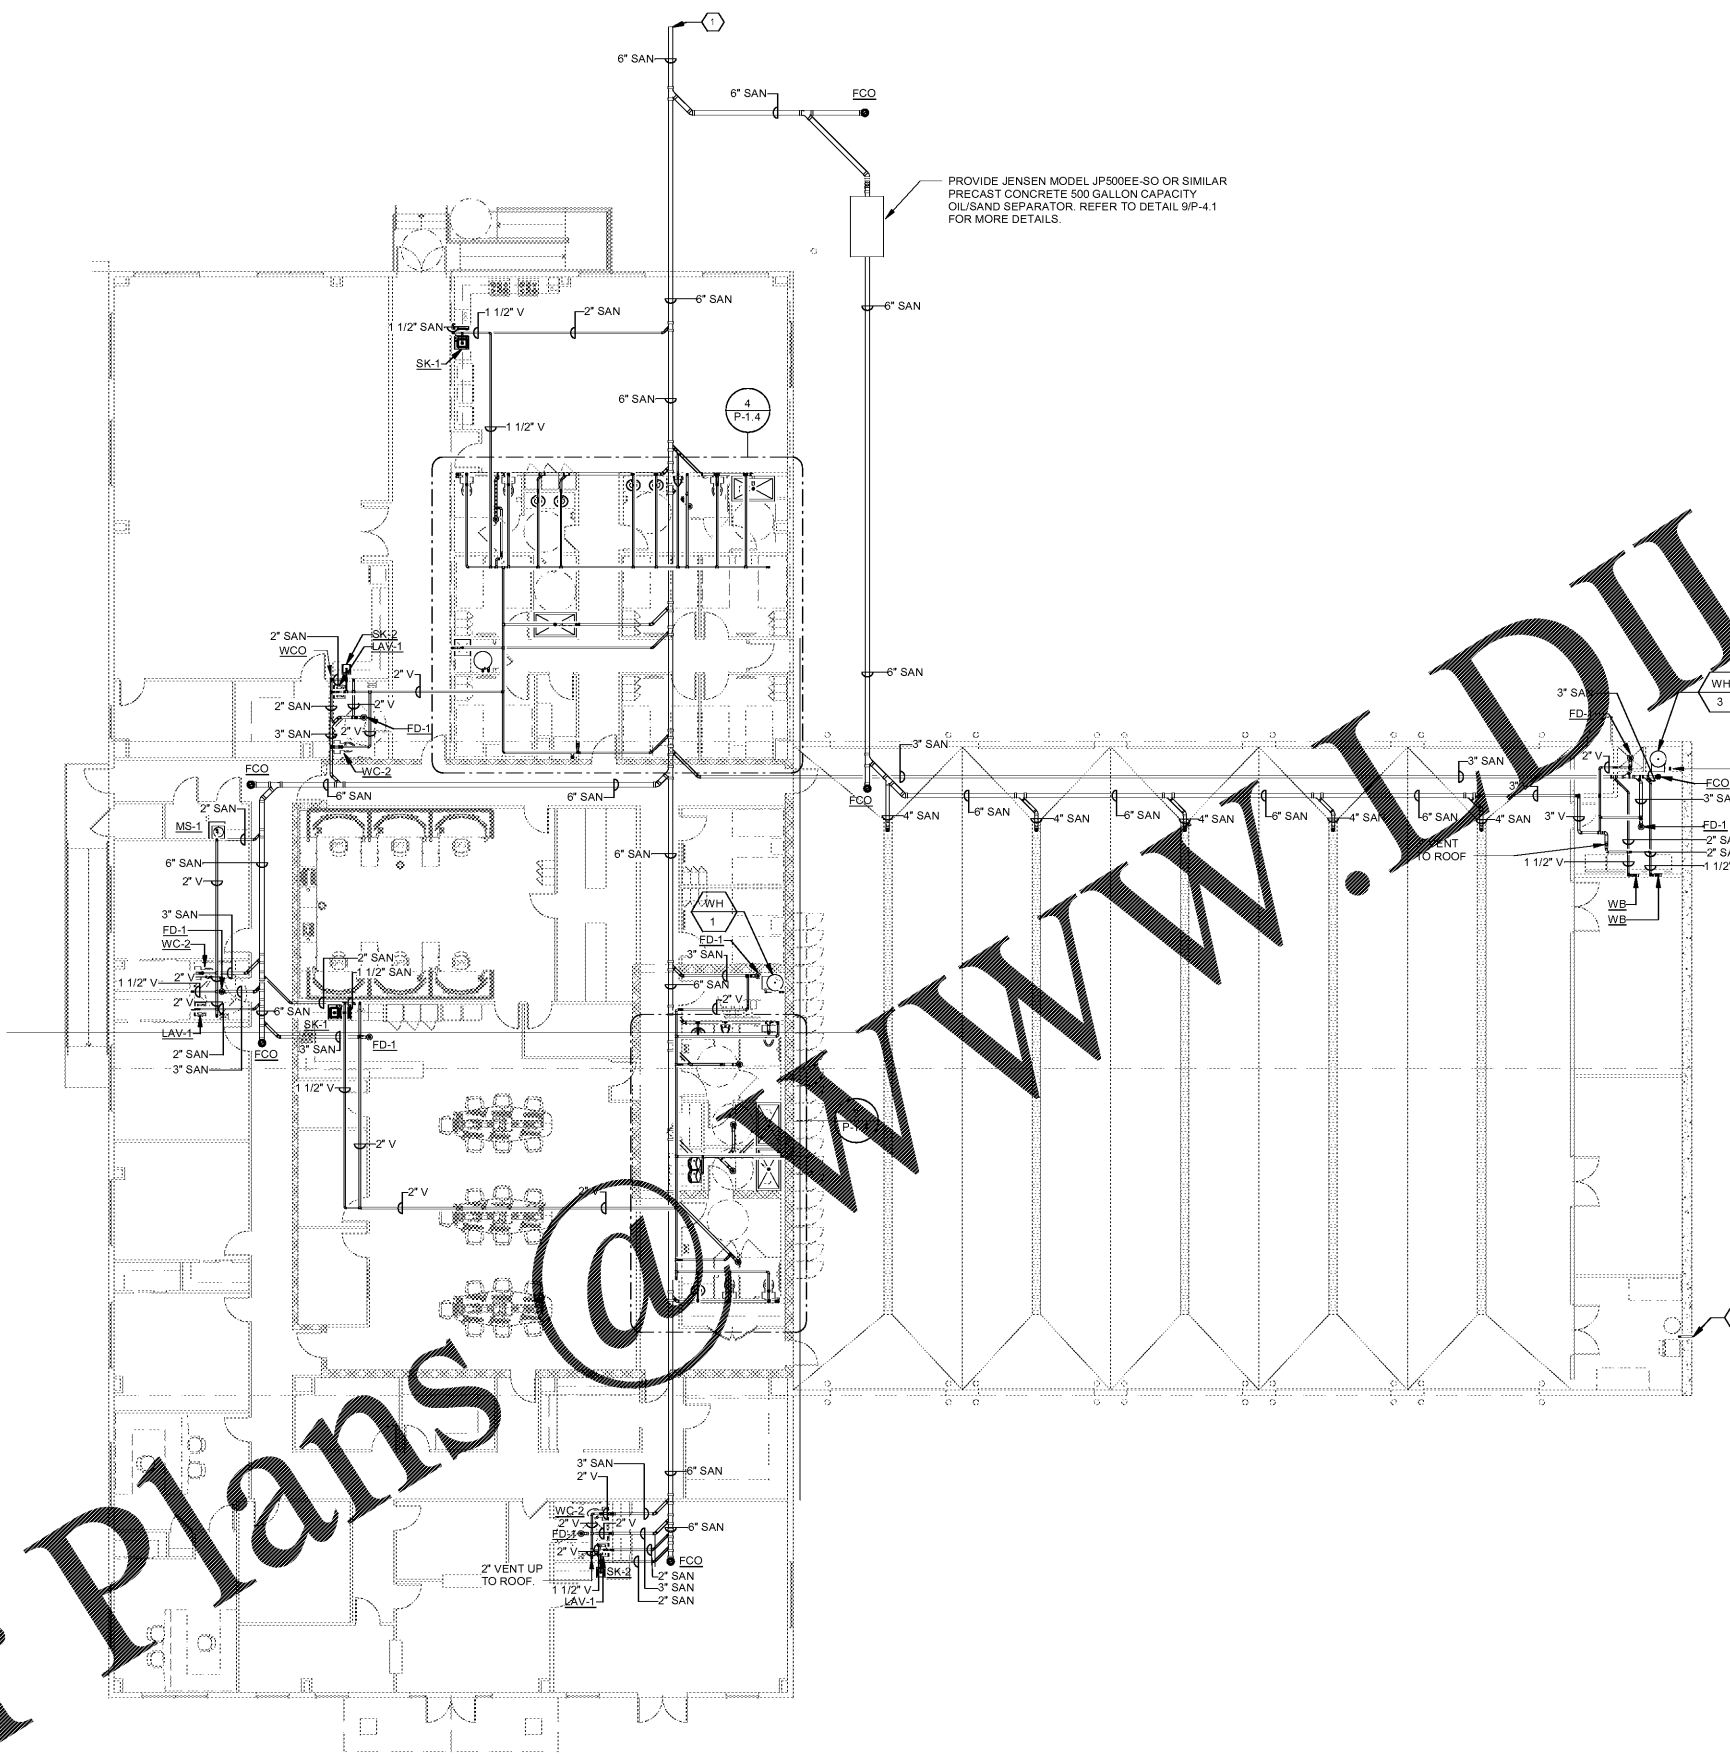

1 SANITARY WASTE AND VENT FLOOR PLAN - PLUMBING
 P-1.1 3/32" = 1'-0"

- KEYED NOTES: (X)
- SANITARY WASTE PIPING BELOW GRADE WITH 2-WAY EXTERNAL CLEANOUT (180 DRAINAGE) WITH MAXIMUM FUTURE 180 DRAINAGE WITH INVERT AT 72" BELOW FINISHED FLOOR LEVEL. REFER TO CIVIL DRAWINGS FOR CONTINUATION.
 - AIR VENT FOR AIR COMPRESSOR.

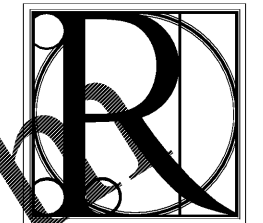

DESIGN WORKS


FANNIN COUNTY:
 722 Black Dog Trail
 P.O. Box 639
 Blue Ridge, GA 30513
 Phone 706.374.4304

COBB COUNTY:
 1480 Shiloh Road NW
 Suite #300
 Kennesaw, GA 30144
 Phone 770.790.3655
 Fax 770.790.3650

SAVANT
 Engineering, LLC
5064 Roswell Road, Suite D-301
 Sandy Springs, GA 30342 770.319.7400
 Project 16047 ©2016

TITLE: SANITARY AND WASTE FLOOR PLAN - PLUMBING
 PROJECT: FANNIN CO. PUBLIC SAFETY COMPLEX
 BLUE RIDGE, GA 30513

ISSUE:	REVISIONS:

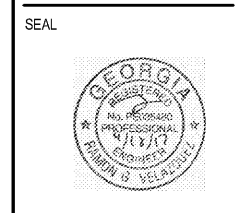

DRAWN BY/ CHECKED BY:	DATE:
RHR/RGB	04.19.2017

PROJECT NO.	SHEET NO.:
1517	P-1.1