



Order Plans @

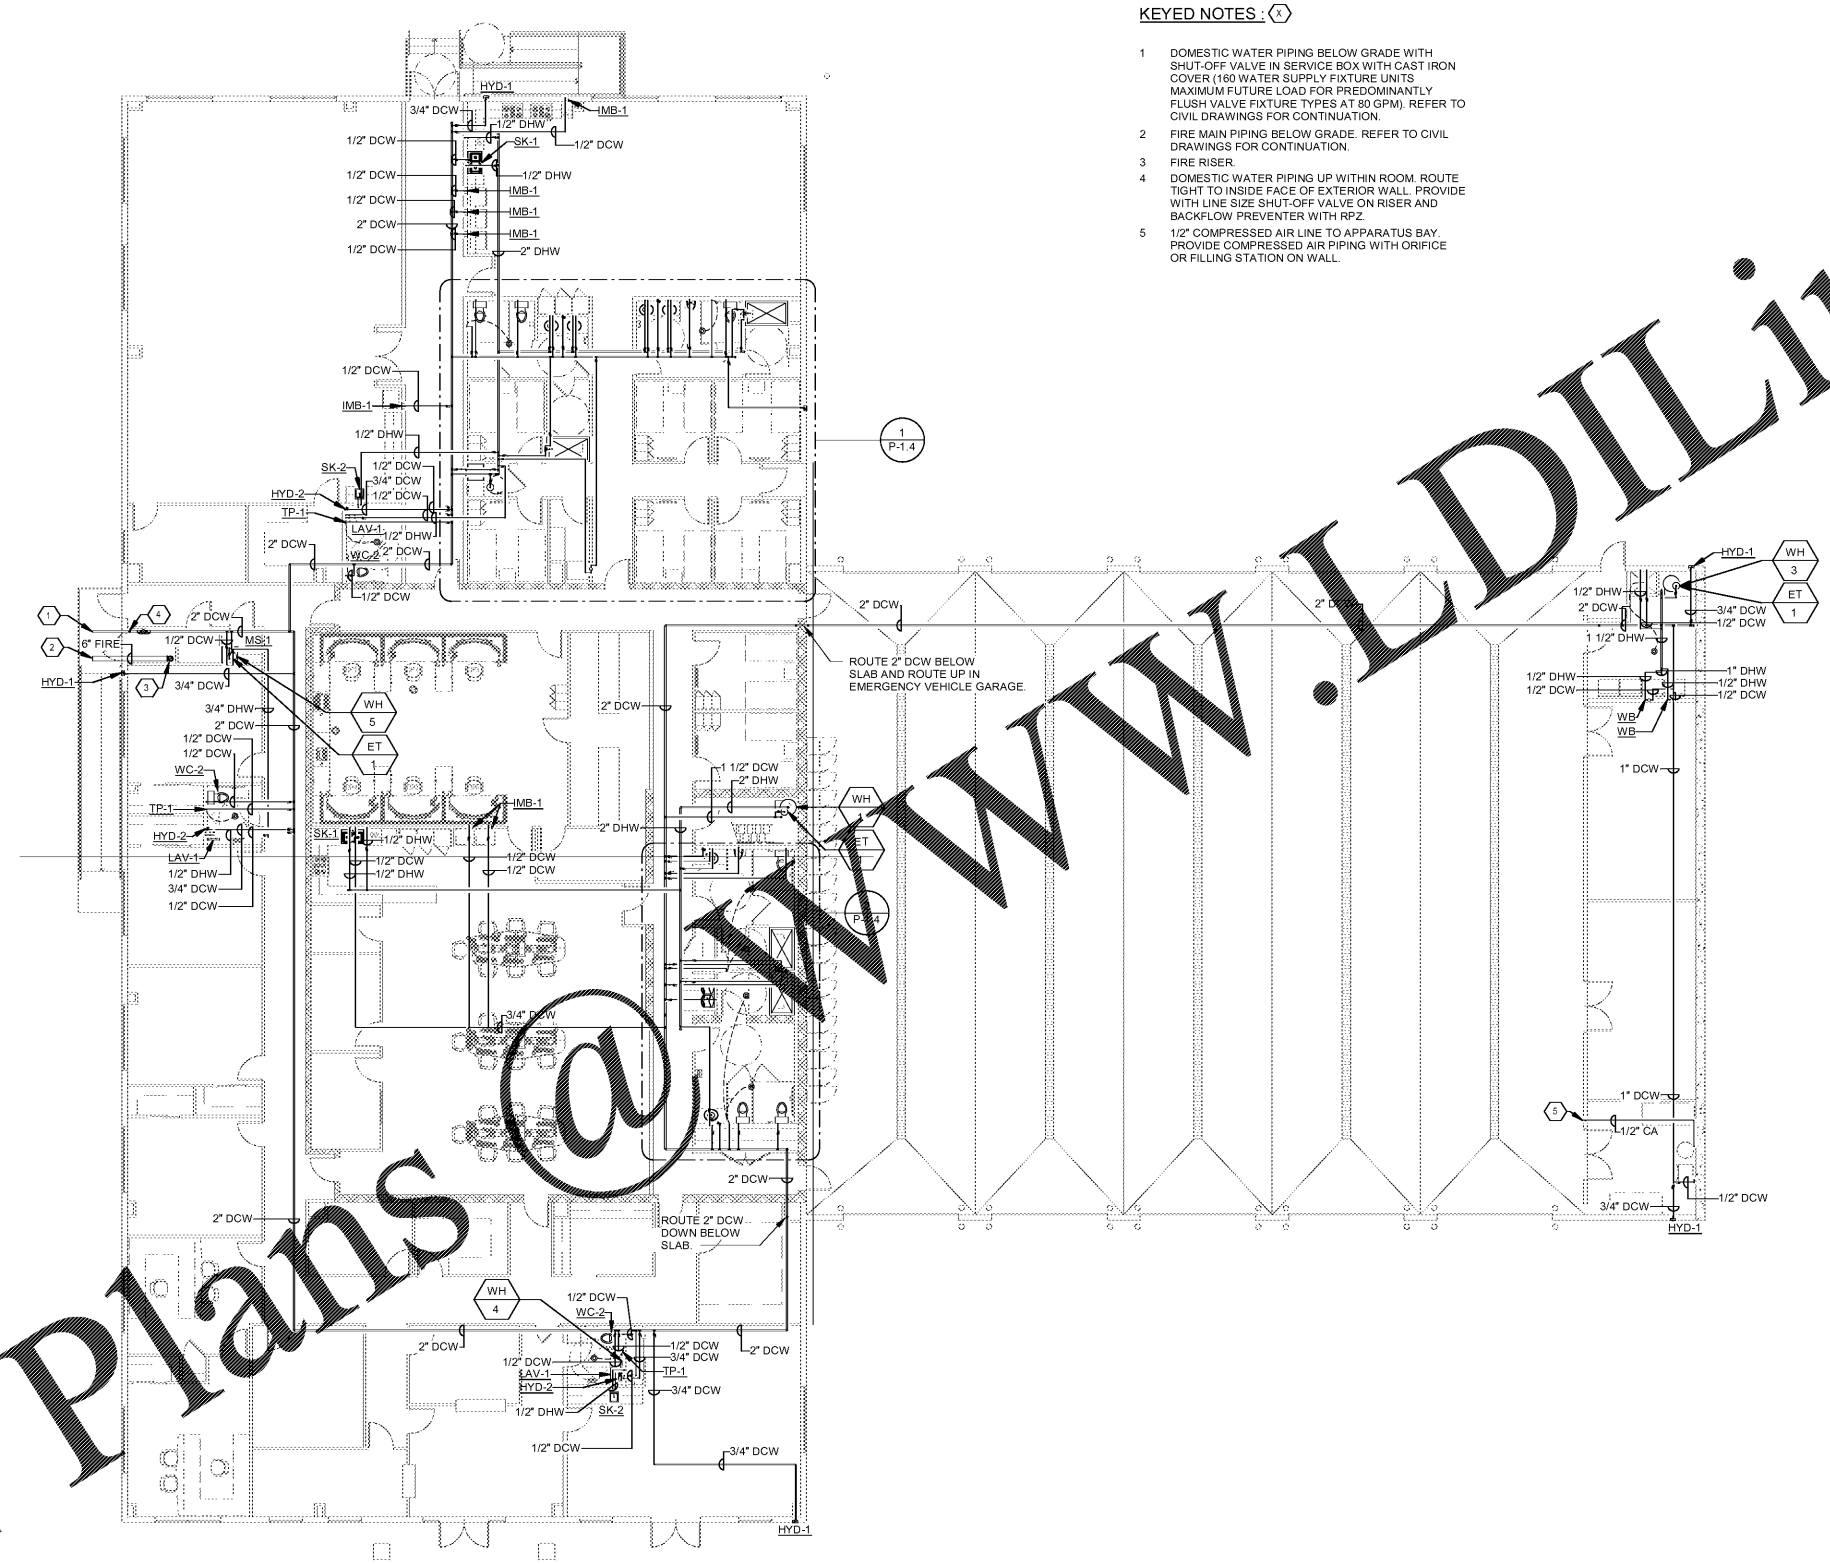

- KEYED NOTES:**
- 1 DOMESTIC WATER PIPING BELOW GRADE WITH SHUT-OFF VALVE IN SERVICE BOX WITH CAST IRON COVER (160 WATER SUPPLY FIXTURE UNITS MAXIMUM FUTURE LOAD FOR PREDOMINANTLY FLUSH VALVE FIXTURE TYPES AT 80 GPM). REFER TO CIVIL DRAWINGS FOR CONTINUATION.
  - 2 FIRE MAIN PIPING BELOW GRADE. REFER TO CIVIL DRAWINGS FOR CONTINUATION.
  - 3 FIRE RISER
  - 4 DOMESTIC WATER PIPING UP WITHIN ROOM. ROUTE TIGHT TO INSIDE FACE OF EXTERIOR WALL. PROVIDE WITH LINE SIZE SHUT-OFF VALVE ON RISER AND BACKFLOW PREVENTER WITH RPZ.
  - 5 1/2" COMPRESSED AIR LINE TO APPARATUS BAY. PROVIDE COMPRESSED AIR PIPING WITH ORIFICE OR FILLING STATION ON WALL.

1 DOMESTIC WATER FLOOR PLAN - PLUMBING  
P-1.2 3/32" = 1'-0"

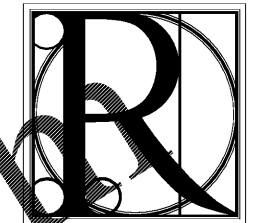

**DESIGN WORKS**

FANNIN COUNTY:  
722 Black Dog Trail  
P.O. Box 639  
Blue Ridge, GA 30513  
Phone 706.374.4304


COBB COUNTY:  
1480 Shiloh Road NW  
Suite #300  
Kennesaw, GA 30144  
Phone 770.790.3655  
Fax 770.790.3650

**SAVANT**  
Engineering, LLC

5064 Roswell Road, Suite D-301  
Sandy Springs, GA 30342 770.319.7400  
Project 16047 ©2016

TITLE: DOMESTIC WATER FLOOR PLAN - PLUMBING  
PROJECT: FANNIN CO. PUBLIC SAFETY COMPLEX  
BLUE RIDGE, GA 30513

ISSUE:	REVISIONS:

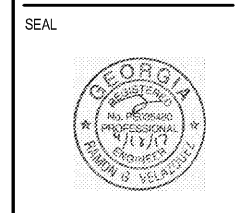

DRAWN BY/ CHECKED BY:	DATE:
RHR/RGV	04.19.2017

PROJECT NO.	SHEET NO.:
1517	P-1.2