


Order Plans

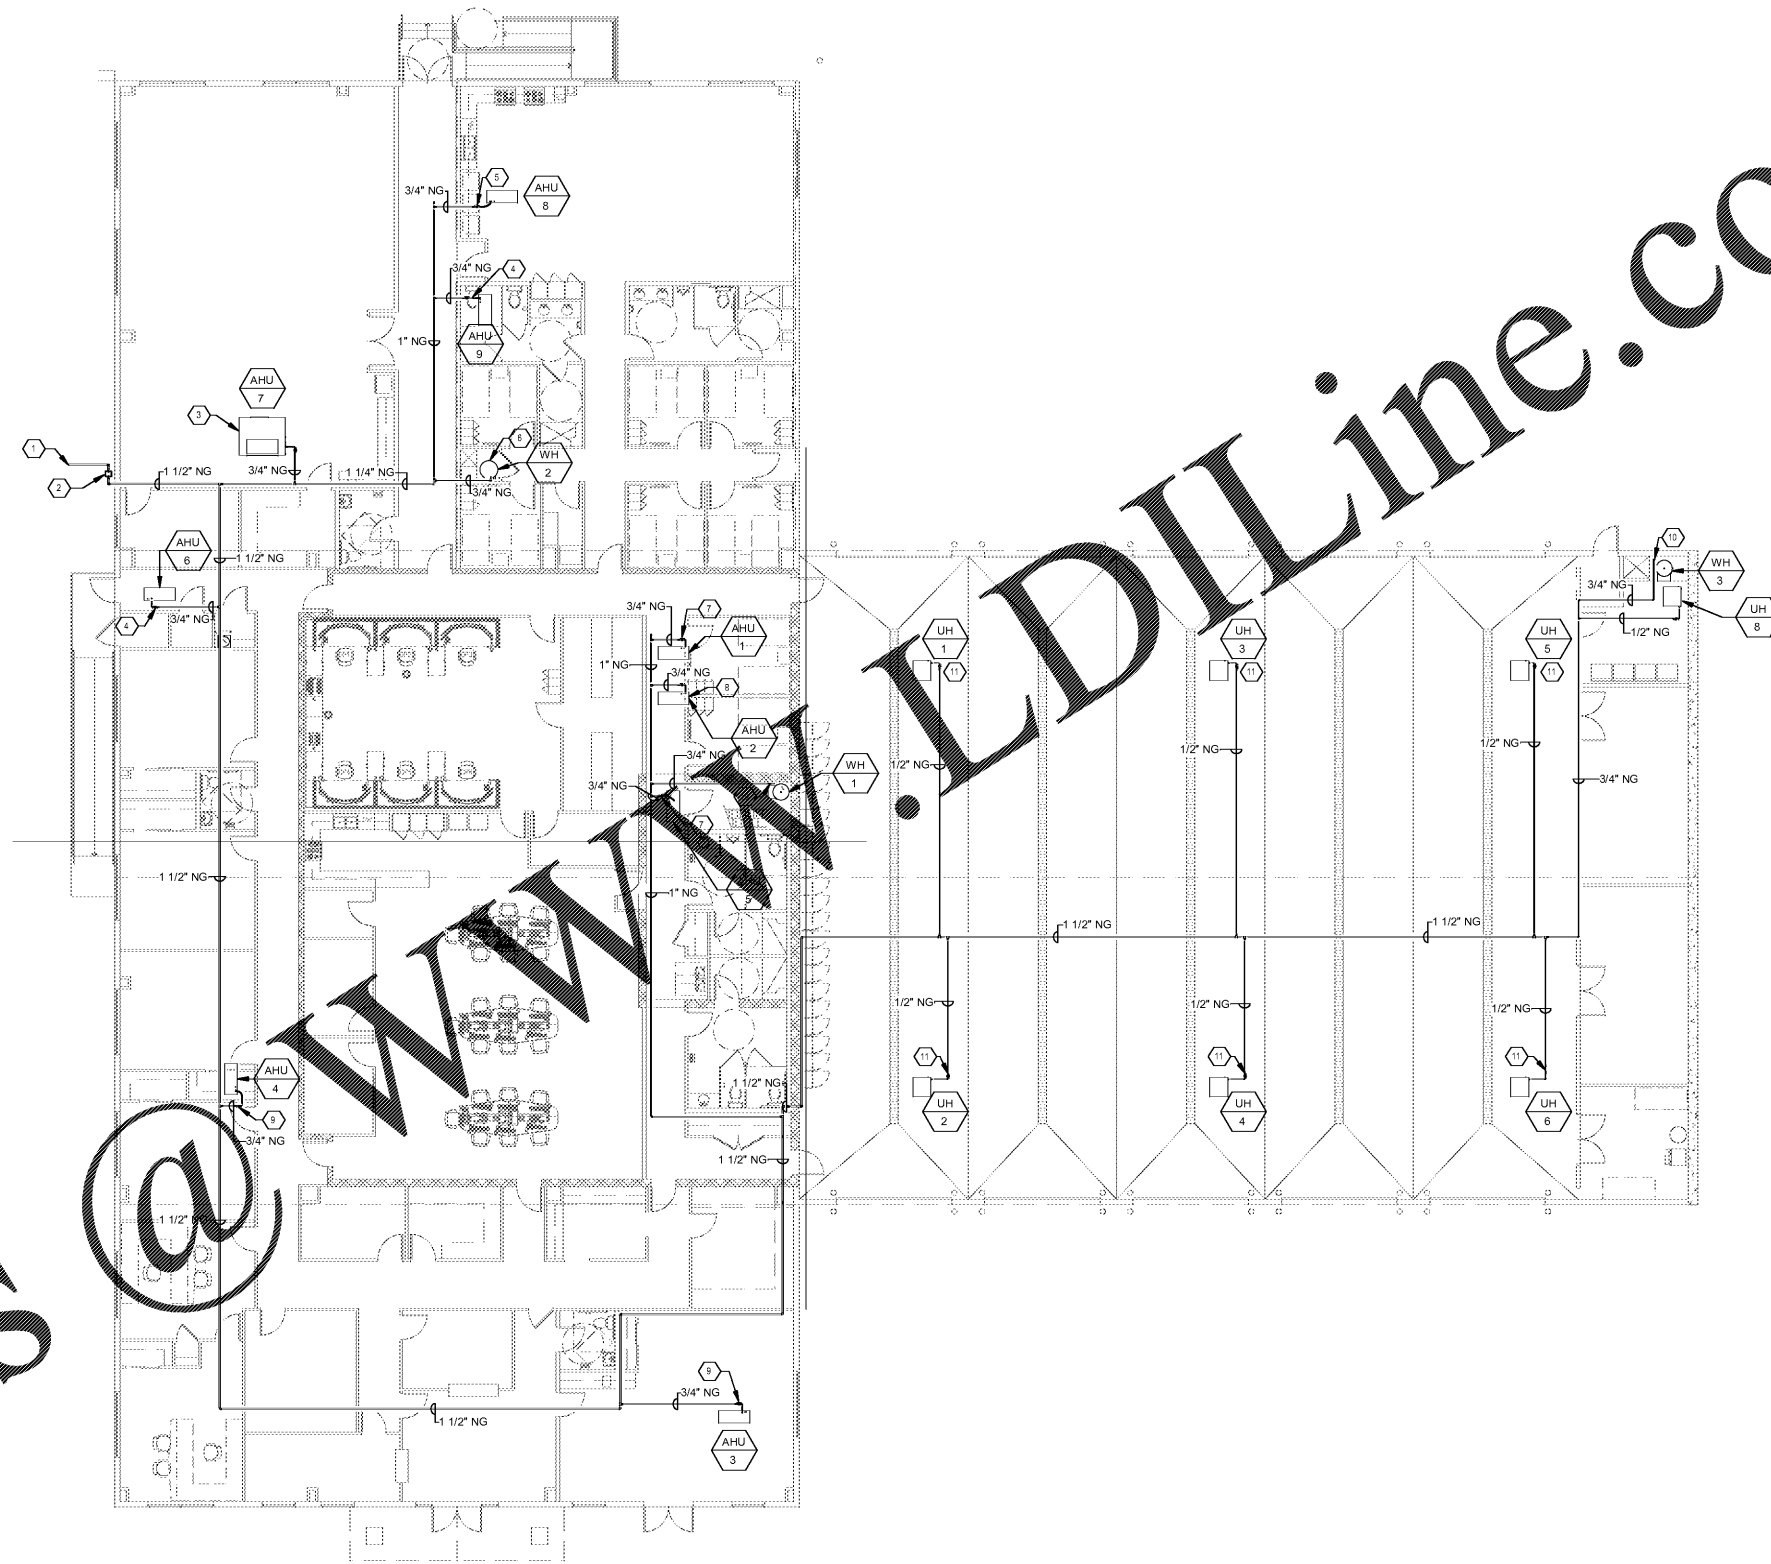

KEYED NOTES: (X)

- 1 NATURAL GAS PIPING BELOW GRADE BY LOCAL UTILITY COMPANY. REFER TO CIVIL DRAWINGS FOR CONTINUATION.
- 2 NATURAL GAS METER BY LOCAL UTILITY COMPANY. PIPE SIZING BASED ON A LOAD OF 1.714 MBH AT 2 PSI AND A DEVELOPED LENGTH OF 750'-0".
- 3 NATURAL GAS PIPING TO AIR HANDLING UNIT DUCT HEATER WITH DIRT LEG, SHUT OFF VALVE AND REGULATOR SET TO MANUFACTURER'S REQUIREMENTS (200 MBH).
- 4 NATURAL GAS PIPING TO AIR HANDLING UNIT WITH DIRT LEG, SHUT OFF VALVE AND REGULATOR SET TO MANUFACTURER'S REQUIREMENTS (40 MBH).
- 5 NATURAL GAS PIPING TO AIR HANDLING UNIT WITH DIRT LEG, SHUT OFF VALVE AND REGULATOR SET TO MANUFACTURER'S REQUIREMENTS (80 MBH).
- 6 NATURAL GAS PIPING TO WATER HEATER (199 MBH).
- 7 NATURAL GAS PIPING TO AIR HANDLING UNIT WITH DIRT LEG, SHUT OFF VALVE AND REGULATOR SET TO MANUFACTURER'S REQUIREMENTS (60 MBH).
- 8 NATURAL GAS PIPING TO AIR HANDLING UNIT WITH DIRT LEG, SHUT OFF VALVE AND REGULATOR SET TO MANUFACTURER'S REQUIREMENTS (75 MBH).
- 9 NATURAL GAS PIPING TO AIR HANDLING UNIT DUCT HEATER WITH DIRT LEG, SHUT OFF VALVE AND REGULATOR SET TO MANUFACTURER'S REQUIREMENTS (75 MBH).
- 10 NATURAL GAS PIPING TO WATER HEATER (130 MBH).
- 11 NATURAL GAS PIPING TO UNIT HEATER WITH SHUT OFF VALVE AND REGULATOR SET TO MANUFACTURER'S REQUIREMENTS (75 MBH).

1 NATURAL GAS FLOOR PLAN - PLUMBING
P-1.3 3/32" = 1'-0"



DESIGN WORKS

FANNIN COUNTY:
722 Black Dog Trail
P.O. Box 639
Blue Ridge, GA 30513
Phone 706.374.4304

COBB COUNTY:
1480 Shiloh Road NW
Suite #300
Kennesaw, GA 30144
Phone 770.790.3655
Fax 770.790.3650

SAVANT Engineering, LLC

5064 Roswell Road, Suite D-301
Sandy Springs, GA 30342 770.319.7400
Project 16047 ©2016

NATURAL GAS FLOOR PLAN - PLUMBING
FANNIN CO. PUBLIC SAFETY COMPLEX
BLUE RIDGE, GA 30513

TITLE:	PROJECT:
ISSUE:	REVISIONS:

SEAL



DRAWN BY/ CHECKED BY:	DATE:
Author	04.19.2017
PROJECT NO.:	SHEET NO.:
1517	P-1.3