




Order Plans @ WWW.DIline.com

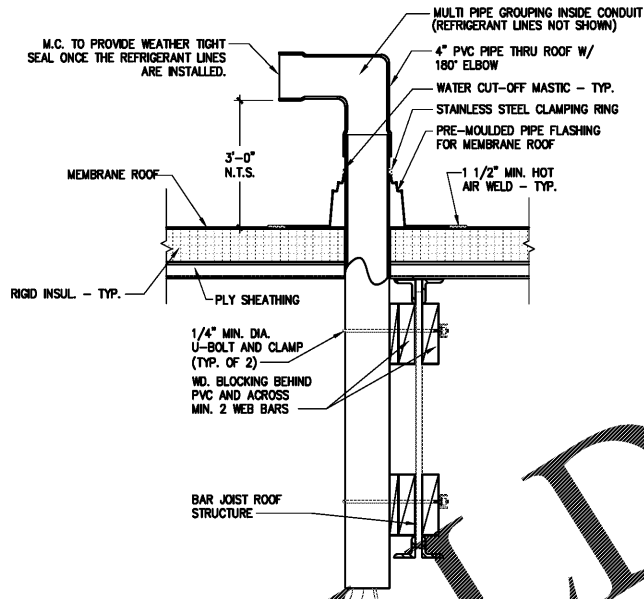

1 REFRIGERANT CONDUIT PENETRATION DETAIL
SCALE: 1 1/2" = 1'-0"

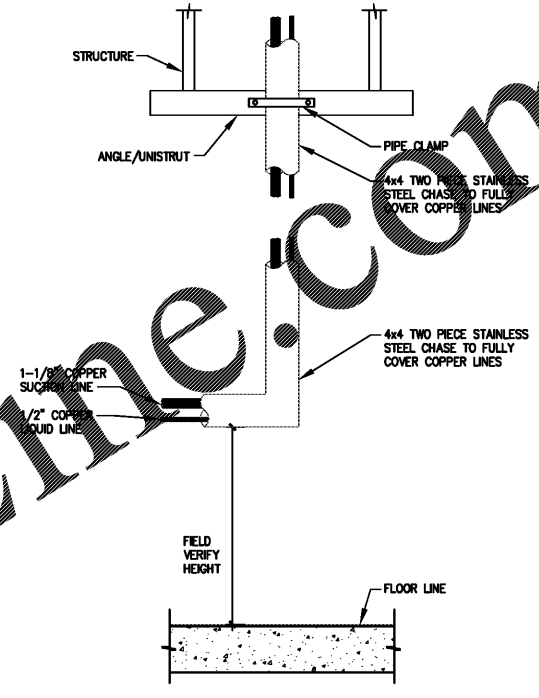

2 REFRIGERANT LINE DETAIL
SCALE: 1 1/2" = 1'-0"

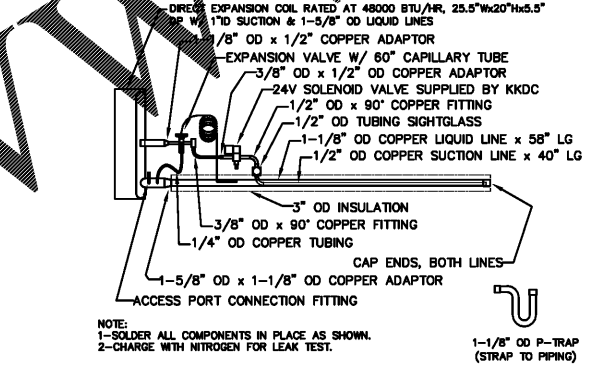

3 COOLING TUNNEL REFRIGERANT PIPING DETAIL
SCALE: 1 1/2" = 1'-0" (PER KK EQUIPMENT DEPT.)

GEORGE SARFATTY, AIA
300 West Street, Suite 410, Pompano Beach, FL 33062
954.781.1100 www.gsa.com Copyright © 2014

KENNETH L. KRAUS
P.E. # 74120
386 Oak Grove Drive
Wausonville, FL 32094
T (847) 719-1708 F (847) 719-1738
Plumbing Mechanical Electrical

KRISPY KREME DOUGHNUTS
1730 E. NINE MILE ROAD
PENSACOLA, FL 32514



DATE: 08/23/18
PROJECT NO.: 18-004
CHECKED BY: KIK
DRAWN BY: STAFF
SHEET TITLE: MECHANICAL DETAILS

SHEET NO.:
M4