
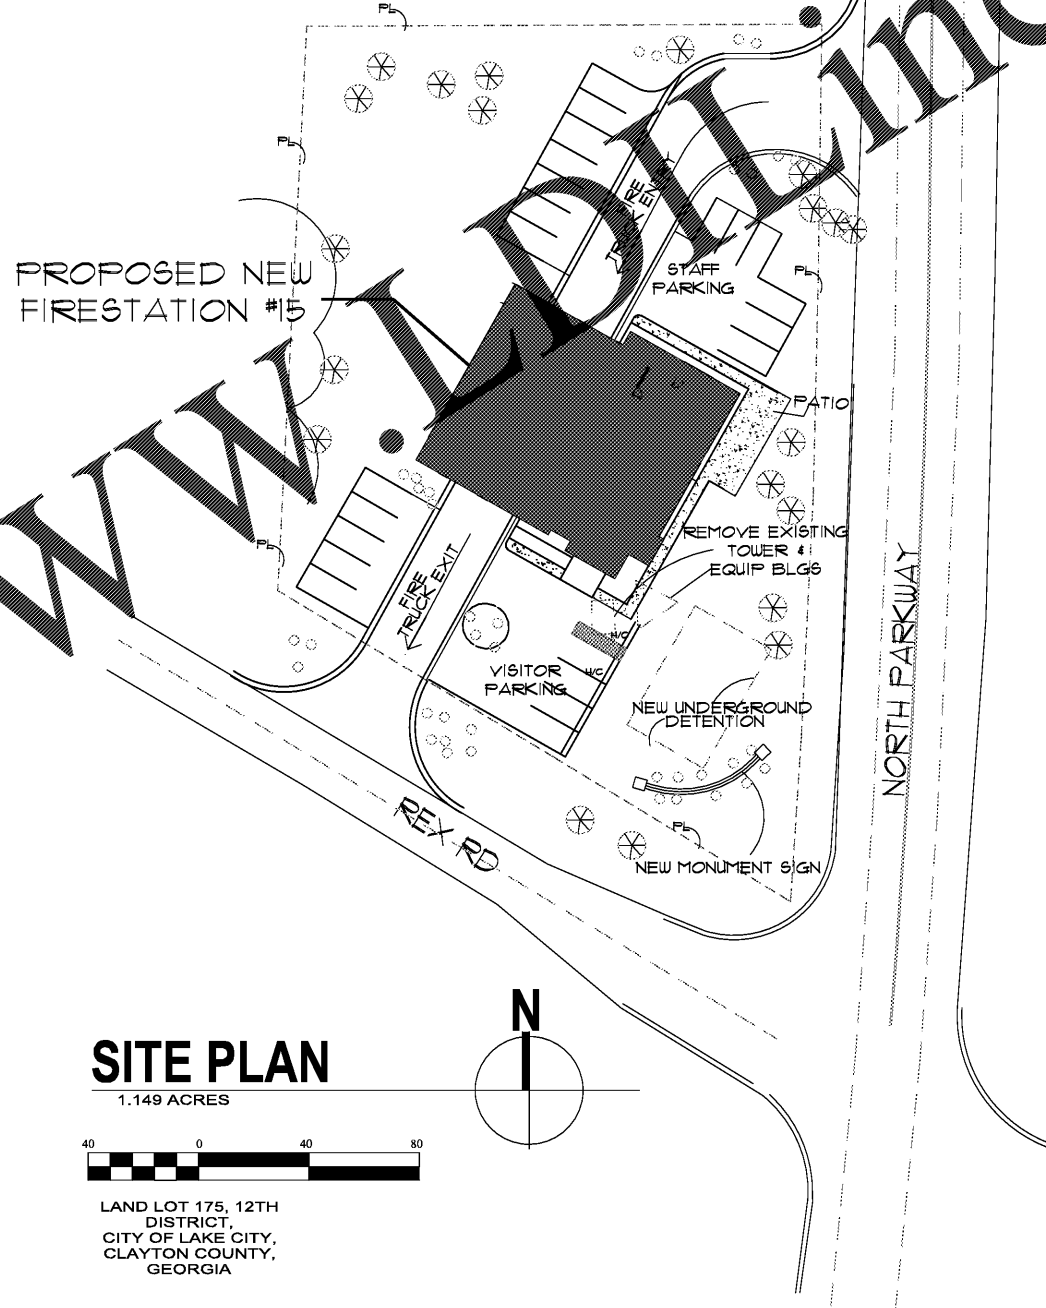


NOTE:

DETAILED SITE DESIGN INFORMATION FOR FIRE STATION No. 15, WHICH WILL BE A COPY OF THE PROTOTYPE DESIGN OF FIRE STATION NO. 9 WILL BE PROVIDED BY ADDENDUM TO THIS BID PACKAGE. SEWER SERVICE TO THE SITE WILL REQUIRE EXTENTION TO THE SITE FROM AN OFFSITE LOCATION TO BE COVERED BY ADDENDUM ALSO. THE EXISTING TOWER WILL BE REMOVED BY OTHER.

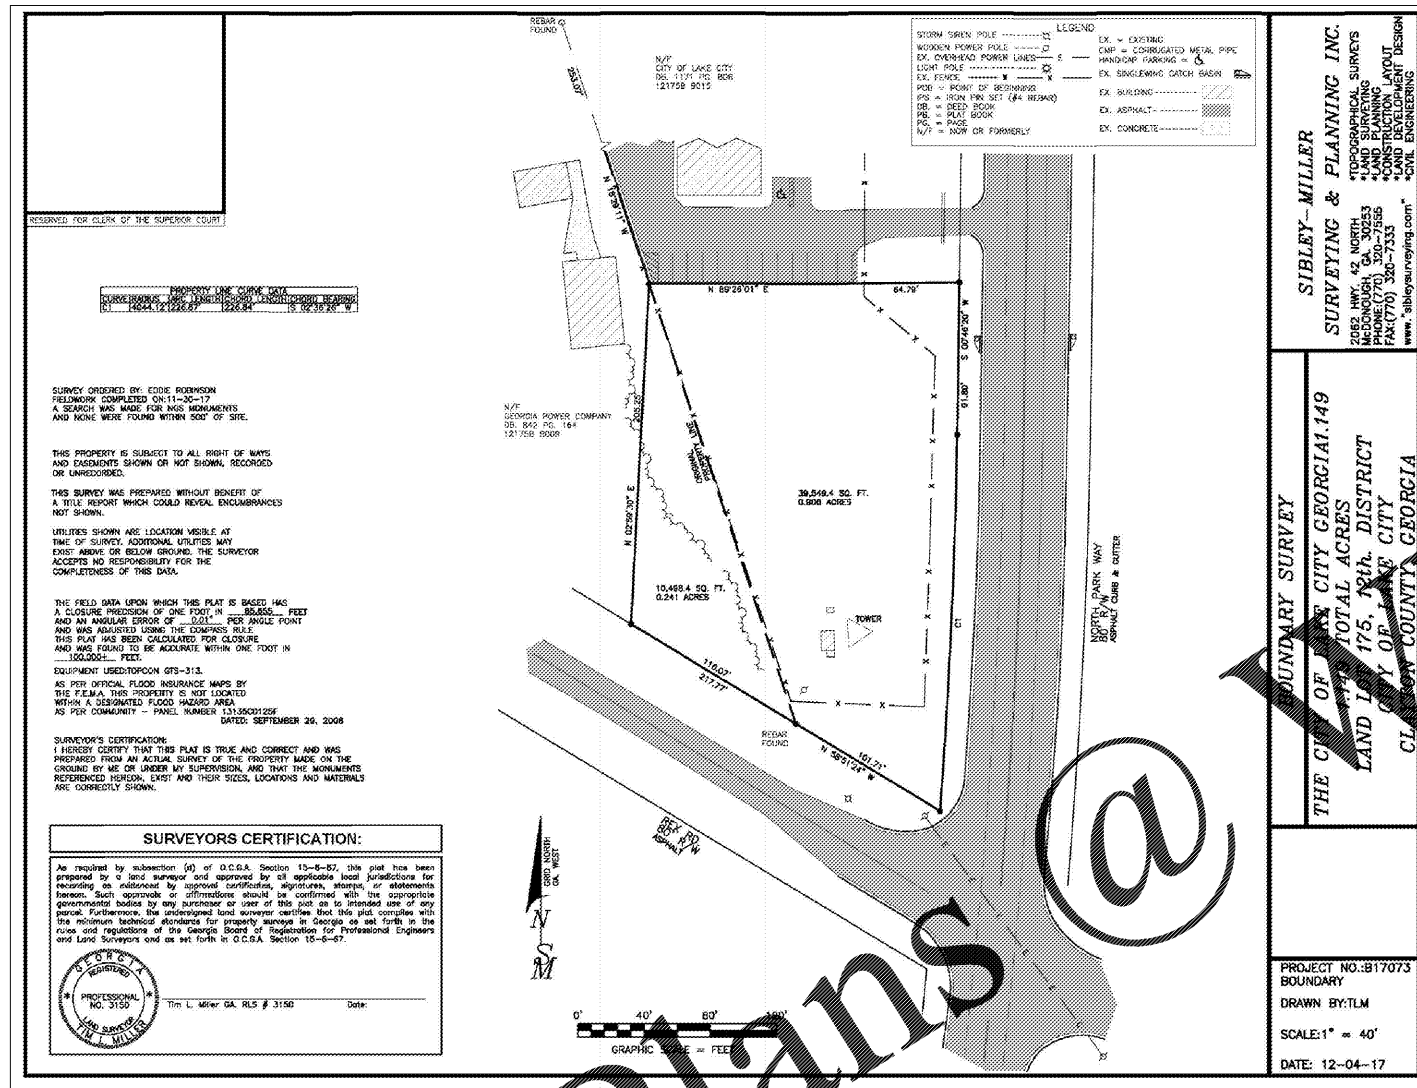

Rev	Date	Description

CLAYTON COUNTY
 NEW FIRE STATION #15
 REX ROAD
 LAKE CITY, GEORGIA

CLAYTON COUNTY
 FIRE DEPARTMENT



ARCHITECTURE
 INTERIOR DESIGN
 LAND PLANNING

160 CLAIREMONT AVE., STE 120
 DECATUR, GEORGIA
 TEL: 470.355.8514

WWW.BOYEARCHITECTURE.COM

CONCEPTUAL SITE PLAN
 NOT RELEASED FOR CONSTRUCTION

DATE: 08/21/18
 PROJECT NO.: 2018-43
 DRAWN BY: BA
 CHECKED BY: BA

SITE PLAN

C-2-F15

Order Plans @