
 


1 PLUMBING - DOMESTIC WATER - SECOND FLOOR PLAN
 P101 SCALE: 1/8" = 1'-0"

- PLUMBING KEY NOTES**
- 1 1-1/4" HW, 2" CW & 1/2" HWR DN TO BELOW BAYS ROOF.
 - 2 1/2" CW & HW TO WASHER VALVE BOX.
 - 3 2" CW & 1-1/4" HW DROPS WITH SHUT-OFF TO LAVATORIES, SHOWERS & WATER CLOSETS
 - 4 1/2" CW & HW TO LAVATORIES, TYP.
 - 5 1-1/2" CW TO WATER CLOSET, TYP.
 - 6 3/4" CW TO URINALS, TYP.
 - 7 1/2" CW & HW TO SINKS, TYP.
 - 8 1/2" CW & HW TO HAND SINK

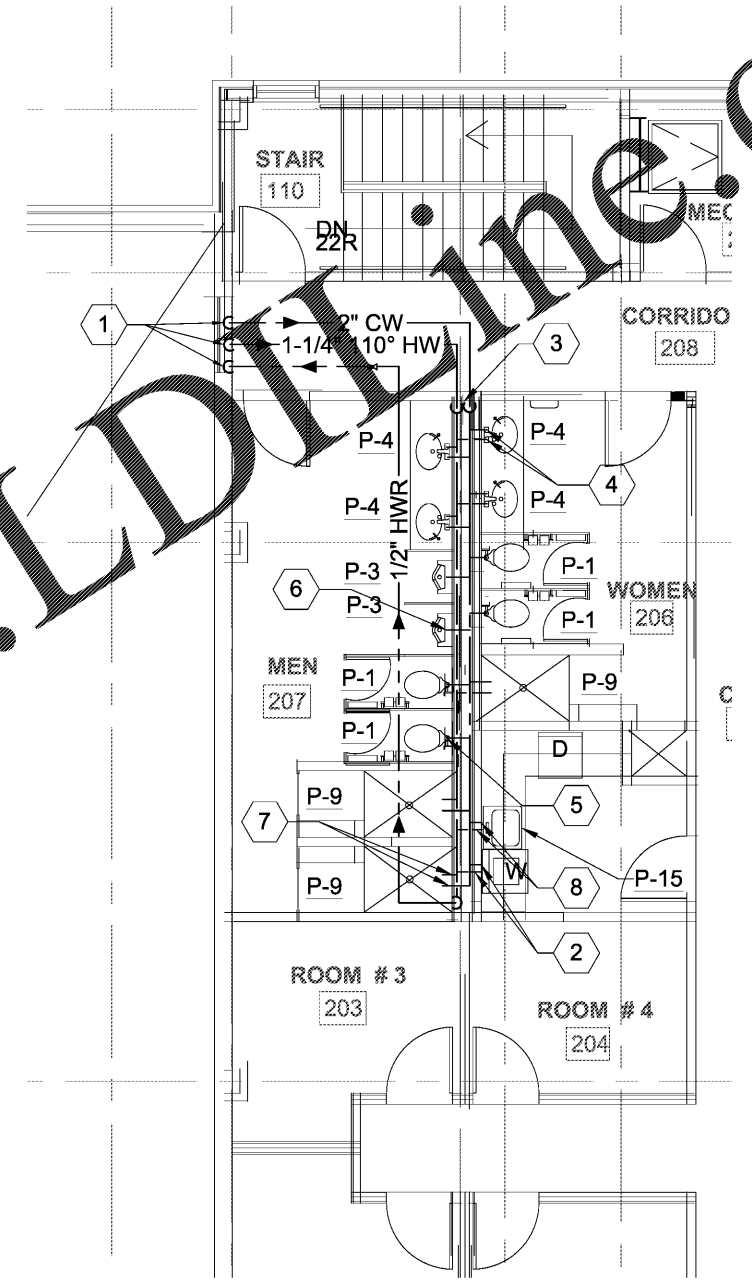

2 PLUMBING - DOMESTIC WATER - ENLARGED SECOND FLOOR PLAN
 P101 SCALE: 1/4" = 1'-0"



CLAYTON COUNTY
 NEW FIRE STATION #9
 4178 OLD DIXIE
 HIGHWAY
 ATLANTA, GEORGIA
 30364

CLAYTON COUNTY
 FIRE DEPARTMENT

SKING
Associates, Inc.
 ENGINEERS • PLANNERS • MANAGERS

270 Peachtree Street, N.W.
 Suite 1600
 Atlanta, GA 30303
 (M) 404.524.5800
 (F) 404.584.1799
 www.sking.com

Boye
BOYE ARCHITECTURE

ARCHITECTURE
 INTERIOR DESIGN
 LAND PLANNING

160 CLARENCE AVE., STE 120
 DECATUR, GEORGIA
 TEL: 478.355.8884

WWW.BOYEARCHITECTURE.COM



RELEASED FOR
 CONSTRUCTION

1:50% (D)

DATE: 07/26/2018
 PROJECT NO: 2017017
 DRAWN BY: AYG
 CHECKED BY: AYG

PLUMBING -
 DOMESTIC WATER -
 SECOND FLOOR PLAN

P101

Order Plans

WWW.LDLINE.COM