


Order Plans

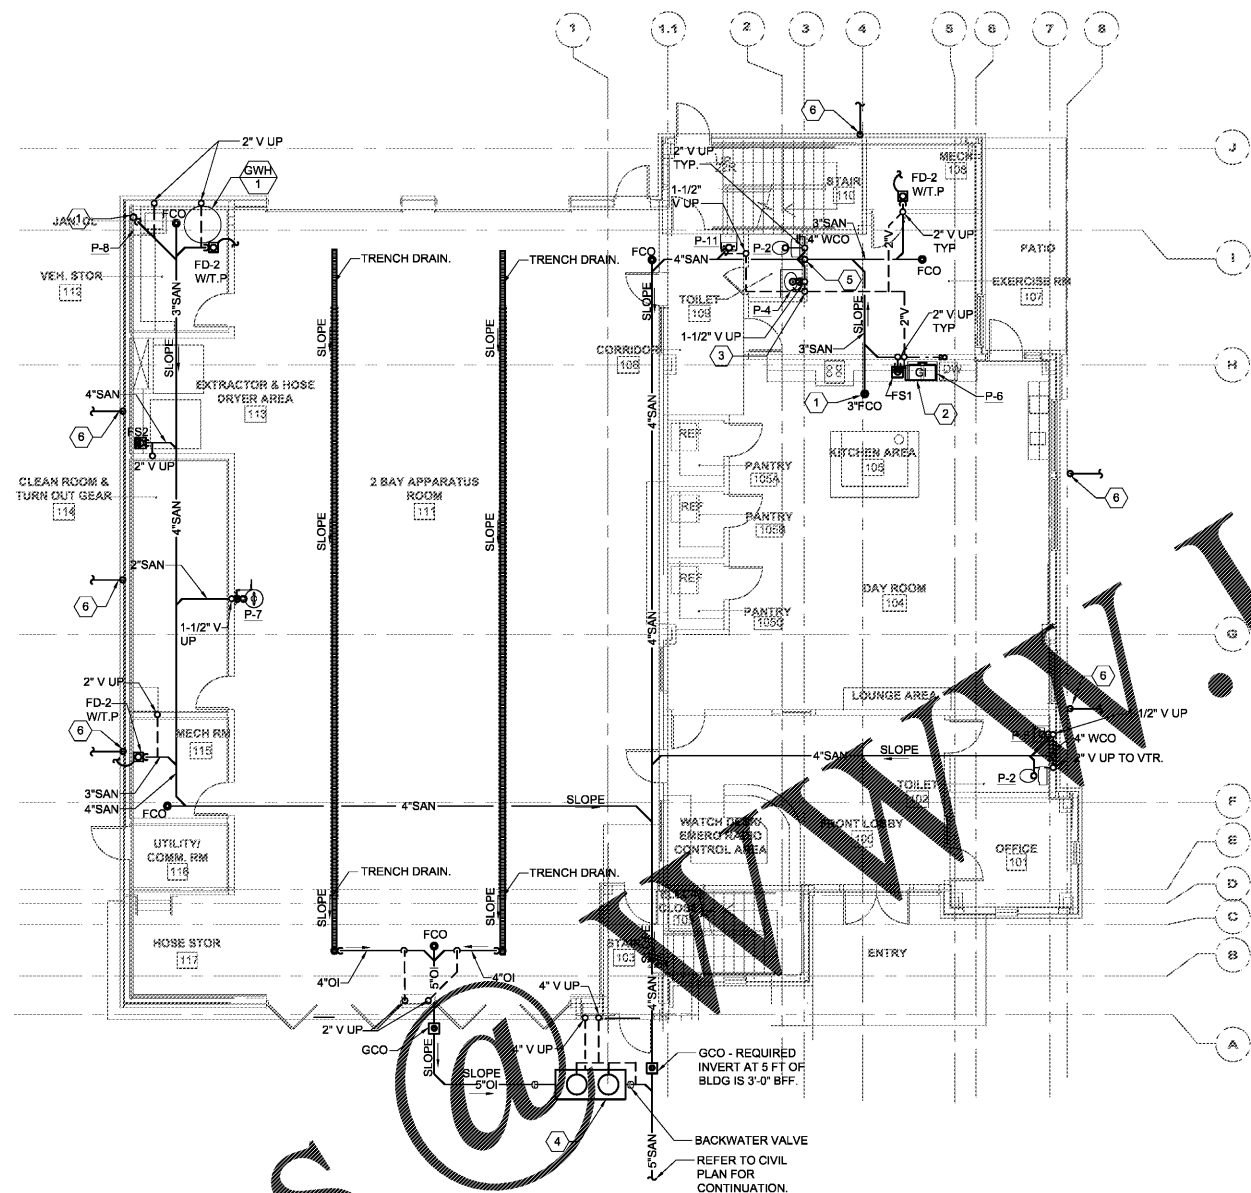

- # PLUMBING KEY NOTES
- 1 STARTING INVERT IS AT 18" BFF
 - 2 MOUNT GREASE INTERCEPTOR BELOW THE SINK/COUNTER AND INSTALL PER MANUFACTURER'S INSTRUCTIONS. REFER TO DETAIL #7 ON SHEET M501.
 - 3 EXTEND 3" VENT UP THRU 2ND FLOOR TO 4" VTR.
 - 4 INSTALL OIL INTERCEPTOR WITH INTEGRAL STORAGE, FLOW CONTROL FITTING/VALVE AND BACKWATER VALVE PER MANUFACTURER'S INSTRUCTIONS. REFER TO DETAIL #8 ON SHEET M501.
 - 5 4" SAN DROP FROM 2ND FLOOR FIXTURES.
 - 6 CONNECT 4" STORM PIPING TO DOWNSPOUT AND EXTEND TO UNDERGROUND STORM PIPING BY CIVIL. REFER TO ARCH PLANS FOR DOWNSPOUT SIZES AND LOCATIONS. REFER TO DETAIL #9 ON SHEET M501 AND CIVIL PLANS FOR CONTINUATION.

1 PLUMBING - SANITARY - FIRST FLOOR PLAN
 P200 SCALE: 1/8" = 1'-0"

CLAYTON COUNTY
 NEW FIRE STATION #9
 4176 OLD DIXIE
 HIGHWAY
 ATLANTA, GEORGIA
 30364
 CLAYTON COUNTY
 FIRE DEPARTMENT

SKING
Associates, Inc.
 ENGINEERS • PLANNERS • MANAGERS
 270 Peachtree Street, N.W.
 Suite 1600
 Atlanta, GA 30303
 (M) 404.524.5800
 (F) 404.584.1799
 www.sking.com



ARCHITECTURE
 INTERIOR DESIGN
 LAND PLANNING
 160 CLAREMONT AVE., STE 120
 DECATUR, GEORGIA
 TEL: 478.355.8884
 WWW.BOYEARCHITECTURE.COM



RELEASED FOR
 CONSTRUCTION
 100% CD
 DATE: 07/26/2018
 PROJECT NO: 2017017
 DRAWN BY: AYG
 CHECKED BY: AYG

PLUMBING -
 SANITARY - FIRST
 FLOOR PLAN

P200

