


1 1ST & 2ND FLOOR DOMESTIC RISER/DIAGRAM
SCALE: NONE

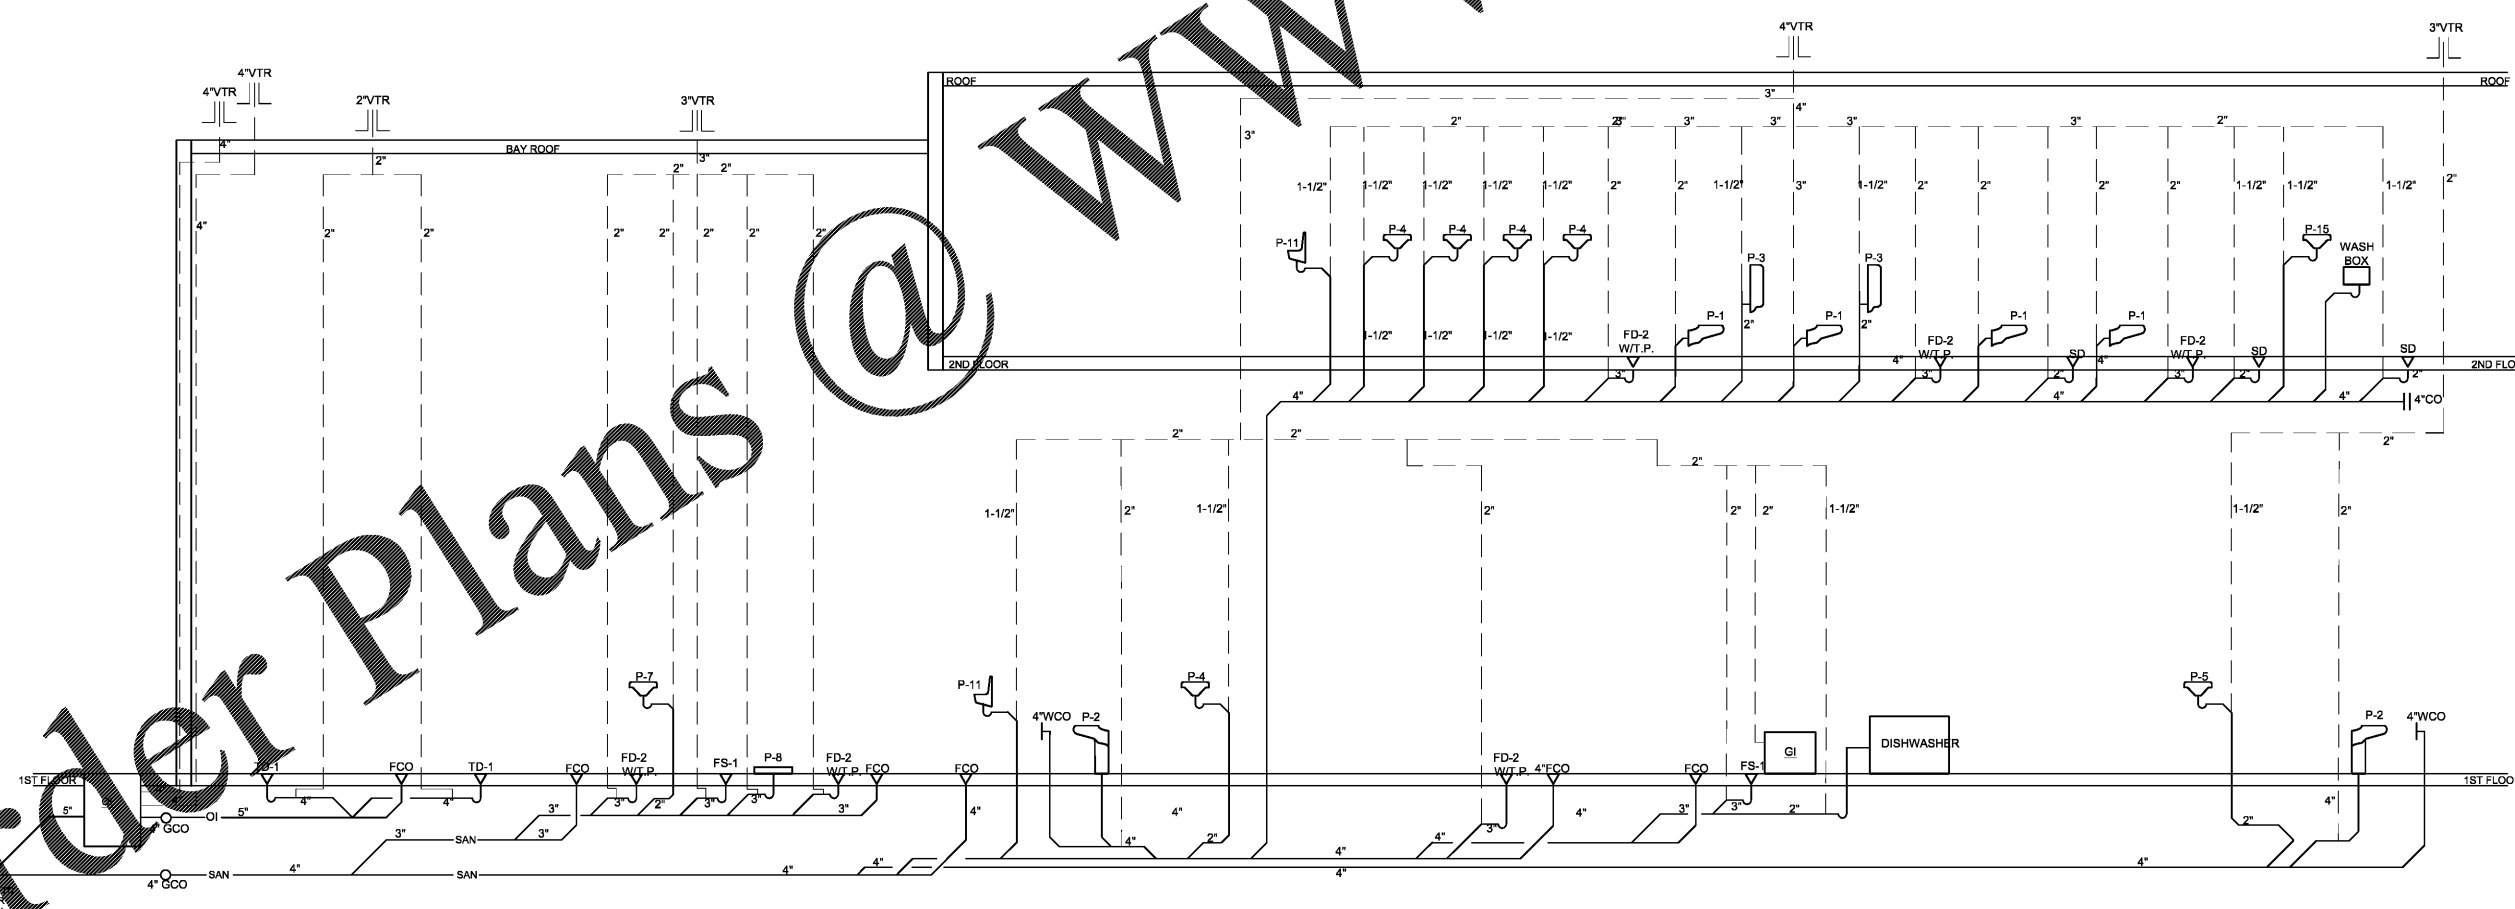

1 CLAYTON COUNTY FIRESTATION #9 - SANITARY RISER
SCALE: NTS

Order Plans @

WWW.LDLine.com

CLAYTON COUNTY
NEW FIRE STATION #9
4178 OLD DIXIE
HIGHWAY
ATLANTA, GEORGIA
30364

CLAYTON COUNTY
FIRE DEPARTMENT

SLIKING
Associates, Inc.
ENGINEERS • PLANNERS • MANAGERS

270 Peachtree Street, N.W.
Suite 1600
Atlanta, GA 30303
(M) 404.524.5800
(F) 404.584.1799
www.sliking.com

BOYE ARCHITECTURE
ARCHITECTURE
INTERIOR DESIGN
LAND PLANNING

160 CLARENCE AVE., STE 120
GECAR, GEORGIA
TEL: 470.355.8814

WWW.BOYEARCHITECTURE.COM



RELEASED FOR
CONSTRUCTION

1/8\"/>

DATE: 07/26/2018
PROJECT NO: 2017017
DRAWN BY: AYG
CHECKED BY: AYG

PLUMBING -
DOMESTIC AND
SANITARY RISERS

P400