



2 ENLARGED DIMENSION PLAN  
E003 SCALE: NTS

GENERAL NOTES:  
 1. PROVIDE 2 PARKING LOT AND DRIVEWAY OPTIONS:  
 OPTION 1 - SITE LIGHTING BY GP.  
 OPTION 2 - CONTRACTOR TO PROVIDE AN ALLOWANCE TO INCLUDE COMPLETE DESIGN AND INSTALLATION FOR PARKING LOT AND DRIVEWAY SITE LIGHTING POLES, FIXTURES, CONDUIT AND WIRING.

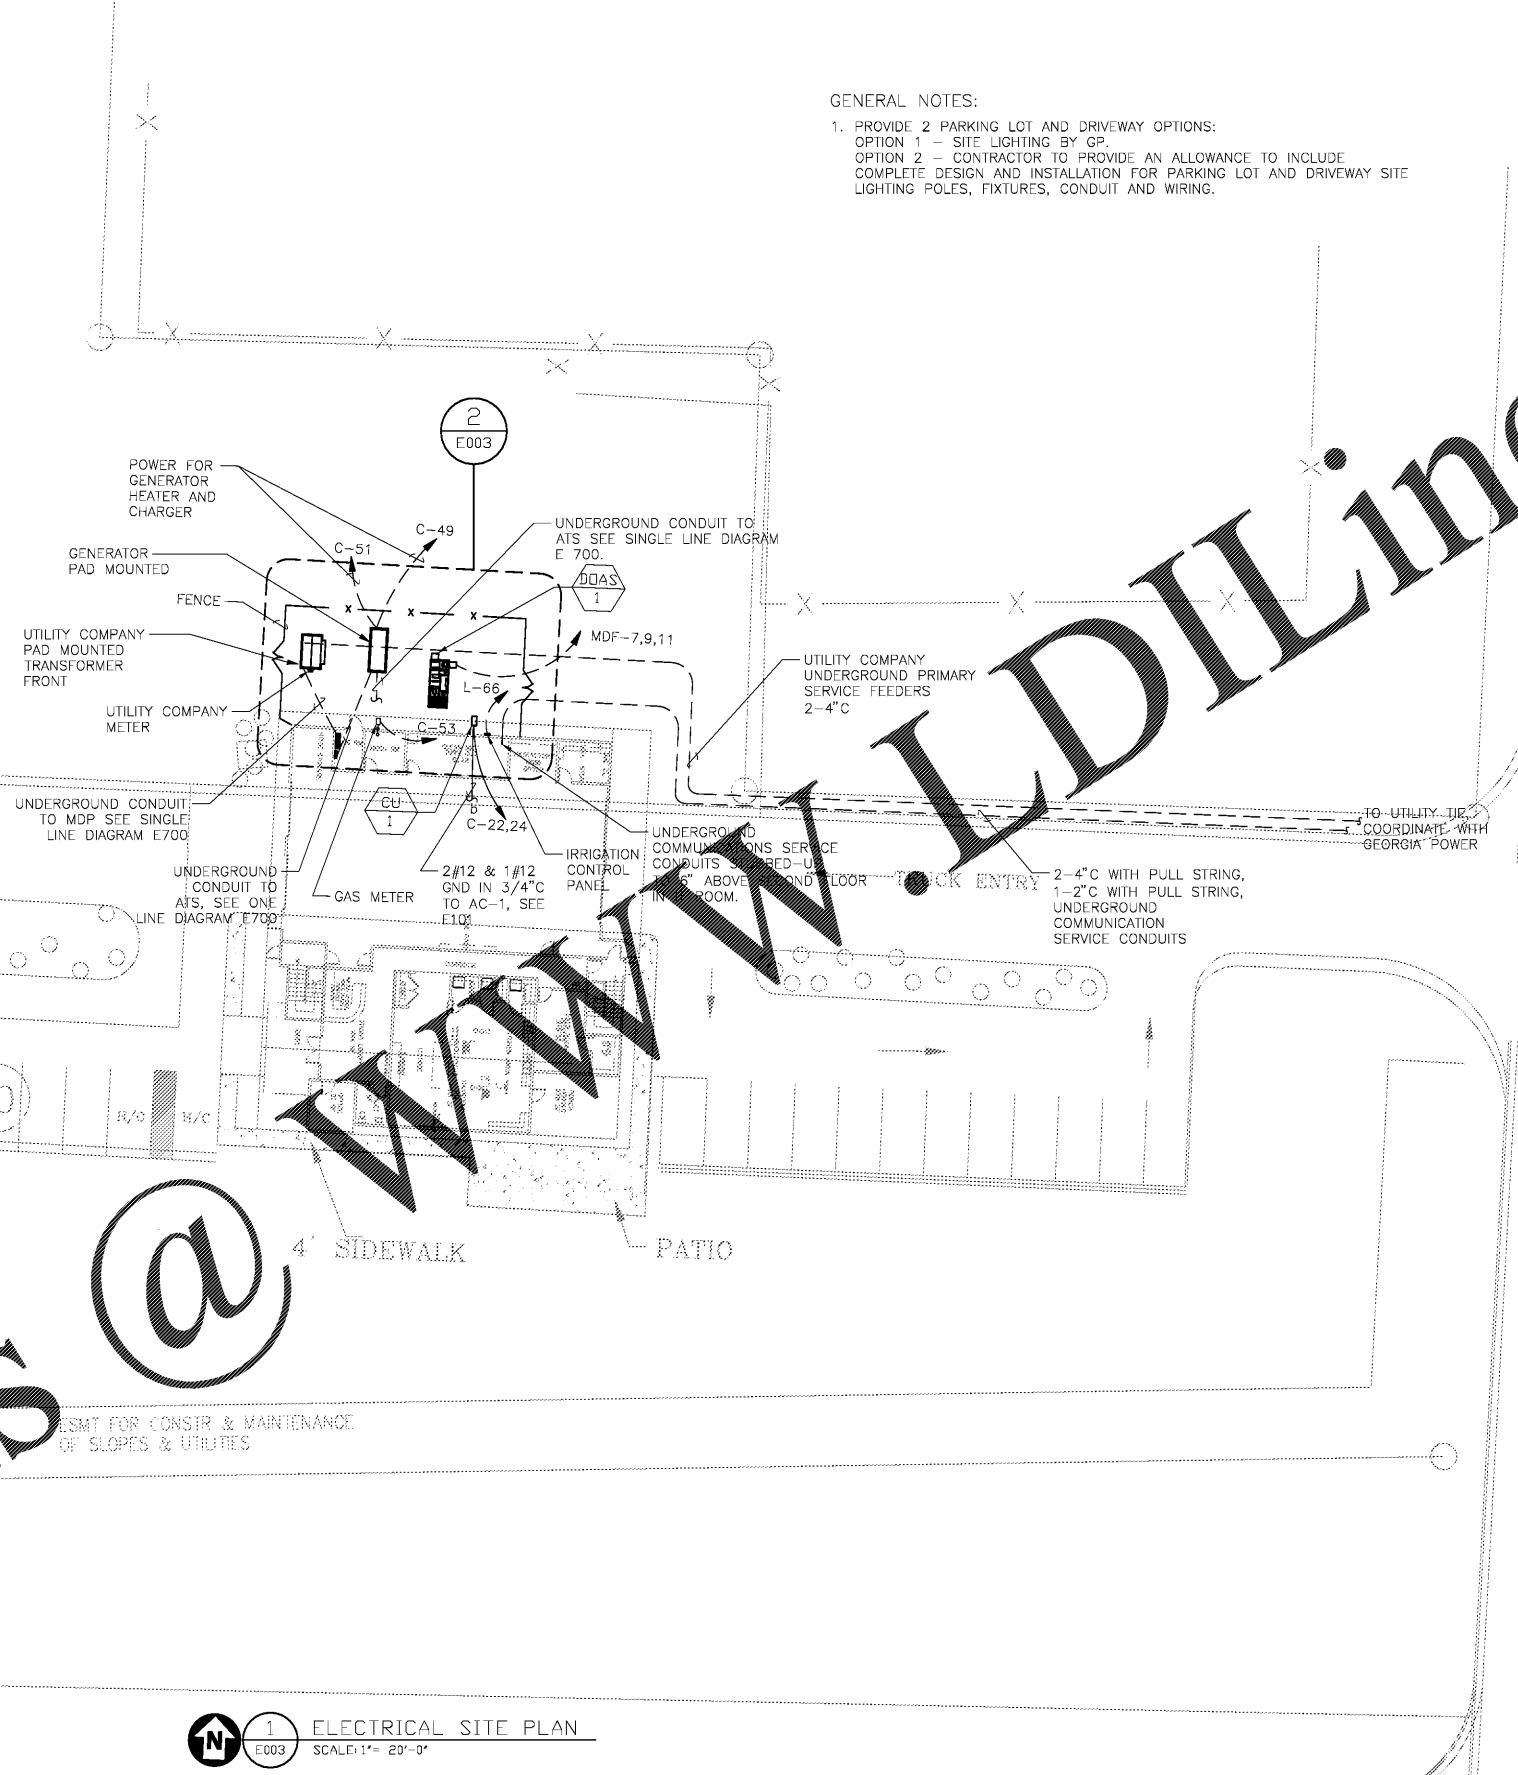

1 ELECTRICAL SITE PLAN  
E003 SCALE: 1" = 20'-0"

 CHARLES W. GRANT PRKWAY (R\W VARIES)



CLAYTON COUNTY  
 NEW FIRE STATION #0  
 4175 OLD DIXIE  
 HIGHWAY  
 ATLANTA, GEORGIA  
 30304


CLAYTON COUNTY  
 FIRE DEPARTMENT

**SKING**  
*Associates, Inc.*  
 ENGINEERS • PLANNERS • MANAGERS

270 Peachtree Street, N.W.  
 Suite 1600  
 Atlanta, GA 30303  
 (M) 404.524.5800  
 (F) 404.584.1799  
 www.skimg.com

*Boyer*  
**BOYER ARCHITECTURE**

ARCHITECTURE  
 INTERIOR DESIGN  
 LAND PLANNING  
 1100 C. C. BARNETT DRIVE, SUITE 100  
 GEORGETOWN, GEORGIA 30428  
 TEL: 478.278.0000  
 WWW.BOYERARCHITECTURE.COM

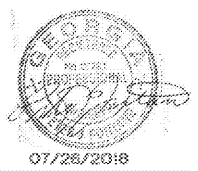

DATE: 07/26/2018  
 PROJECT NO: 2017017  
 DRAWN BY:  
 CHECKED BY:  
 DATE PLOTTED: 8/1/2018

ELECTRICAL SITE PLAN

E003

Order Plans @

WWW.LDILine.com

2#1