


Order Plans @ www.LDinline.com

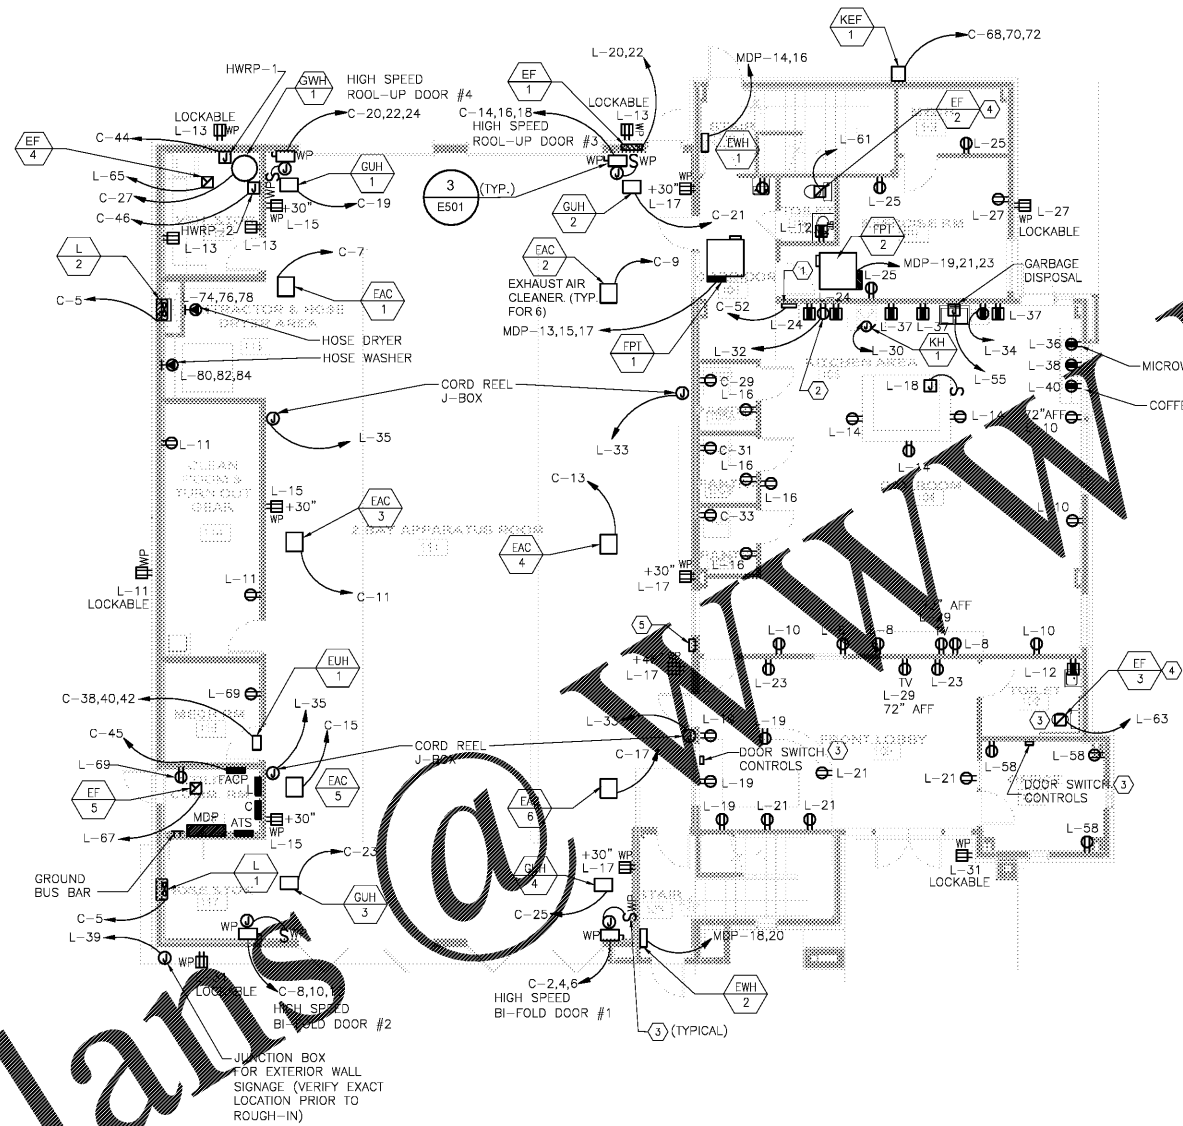

- GENERAL NOTES**
- DO NOT INSTALL DEVICES BACK TO BACK IN ANY FIRE RATED WALL, PROVIDE MINIMUM 24" HORIZONTAL SPACE BETWEEN OUTLETS.
 - PER UL SEAL ALL PENETRATIONS IN EVERY FIRE RATED WALL AND FLOOR TO MAINTAIN WALL AND FLOOR ORIGINAL RATING.
 - PROVIDE #10 CONDUCTORS FOR ANY 120V CIRCUIT OVER 100'. PROVIDE #8 CONDUCTOR FOR ANY CIRCUIT OVER 150'.
 - SEE DRAWINGS E501 THROUGH E502 FOR DETAILS.
 - SEE DRAWINGS E601 FOR ELECTRICAL EQUIPMENT CONSTRUCTION SCHEDULE.
 - SEE DRAWING E700 FOR SINGLE LINE DIAGRAM.

- ELECTRICAL KEY NOTES**
- KITCHEN CONTROL PANEL ON THE WALL MOUNTED AT 60" AFF. REFER TO M602 FOR DETAILS. COORDINATE REQUIREMENTS WITH MECHANICAL CONTRACTOR PRIOR TO ROUGH-IN.
 - MOUNT AT HEIGHT FOR MICROWAVE. COORDINATE WITH MILLWORK CONTRACTOR.
 - COORDINATE DOOR LOCK CONTROLS WITH DOOR MANUFACTURER SO THAT ALL 4 APPARATUS DOORS CAN BE CONTROLLED LOCALLY AT EACH DOOR, AT THE CONTROL DESK, AND THE OFFICE, AS SHOWN.
 - EXHAUST FAN SHALL BE SWITCHED WITH REST ROOM LIGHT.
 - AVG PANEL, COORDINATE EXACT LOCATION AND REQUIREMENTS WITH MECHANICAL CONTRACTOR PRIOR TO ROUGH-IN. SEE M100 FOR MORE DETAIL.

1 ELECTRICAL POWER- FIRST FLOOR PLAN
 E100 SCALE: 1/8" = 1'-0"



CLAYTON COUNTY
 NEW FIRE STATION #0
 4175 OLD DIXIE
 HIGHWAY
 ATLANTA, GEORGIA
 30304

CLAYTON COUNTY
 FIRE DEPARTMENT

SKING
Associates, Inc.
 ENGINEERS • PLANNERS • MANAGERS


270 Peachtree Street, N.W.
 Suite 1600
 Atlanta, GA 30303
 (M) 404.524.5800
 (F) 404.584.1799
 www.skling.com

Boye Architecture

ARCHITECTURE
 INTERIOR DESIGN
 LAND PLANNING

110 CUMBERLAND AVENUE, SUITE 1200
 ATLANTA, GEORGIA 30309
 TEL: 404.753.3500

WORKSHEET AND BLUEPRINT TITLE

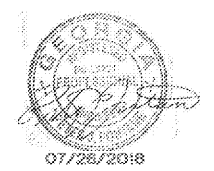

DATE: 07/26/2018
 PROJECT NO: 2017017
 DRAWING NO: RL
 DATE PLOTTED: PF

ELECTRICAL
 POWER- FIRST
 FLOOR PLAN

E100