


Order Plans @

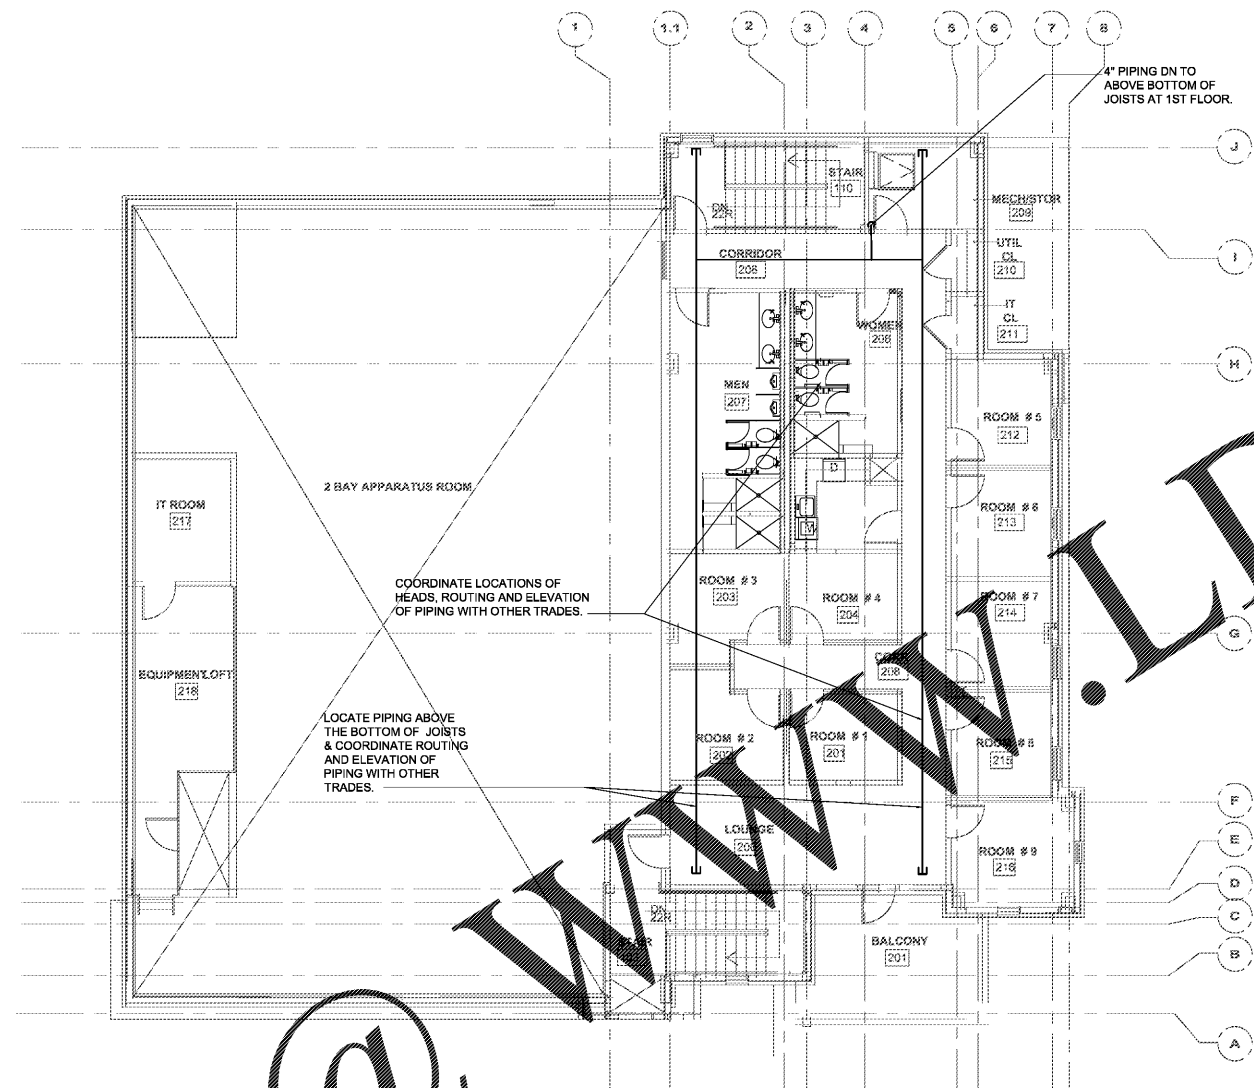

WWW.LDILine.com

NO.	DATE	DESCRIPTION

CLAYTON COUNTY
 NEW FIRE STATION #9
 4178 OLD DIXIE
 HIGHWAY
 ATLANTA, GEORGIA
 30364

CLAYTON COUNTY
 FIRE DEPARTMENT

SKING
Associates, Inc.
 ENGINEERS • PLANNERS • MANAGERS

270 Peachtree Street, N.W.
 Suite 1600
 Atlanta, GA 30303
 (M) 404.524.5800
 (F) 404.584.1799
 www.sking.com



ARCHITECTURE
 INTERIOR DESIGN
 LAND PLANNING

180 CLAREMONT AVE., STE 120
 DECATUR, GEORGIA
 TEL: 478.355.8884

WWW.BOYEARCHITECTURE.COM



 
RELEASED FOR
 CONSTRUCTION

1/8" = 1'-0"

DATE: 07/26/2018
 PROJECT NO: 2017017
 DRAWN BY: AYG
 CHECKED BY: AYG

FIRE PROTECTION -
 SECOND FLOOR PLAN

1 FIRE PROTECTION - SECOND FLOOR PLAN
 FP101 SCALE: 1/4" = 1'-0"



FP101