

NO.	DESCRIPTION	DATE


PAULDING COLLEGE & CAREER ACADEMY
 4555 DALLAS ACWORTH HWY
 DALLAS, GA 30132
 (FACILITY CODE: 710-3652)

PAULDING COUNTY SCHOOLS

REFLECTED CEILING PLAN

DATE: 08/08/2018
 PROJECT NO.: 17129

A1.1D

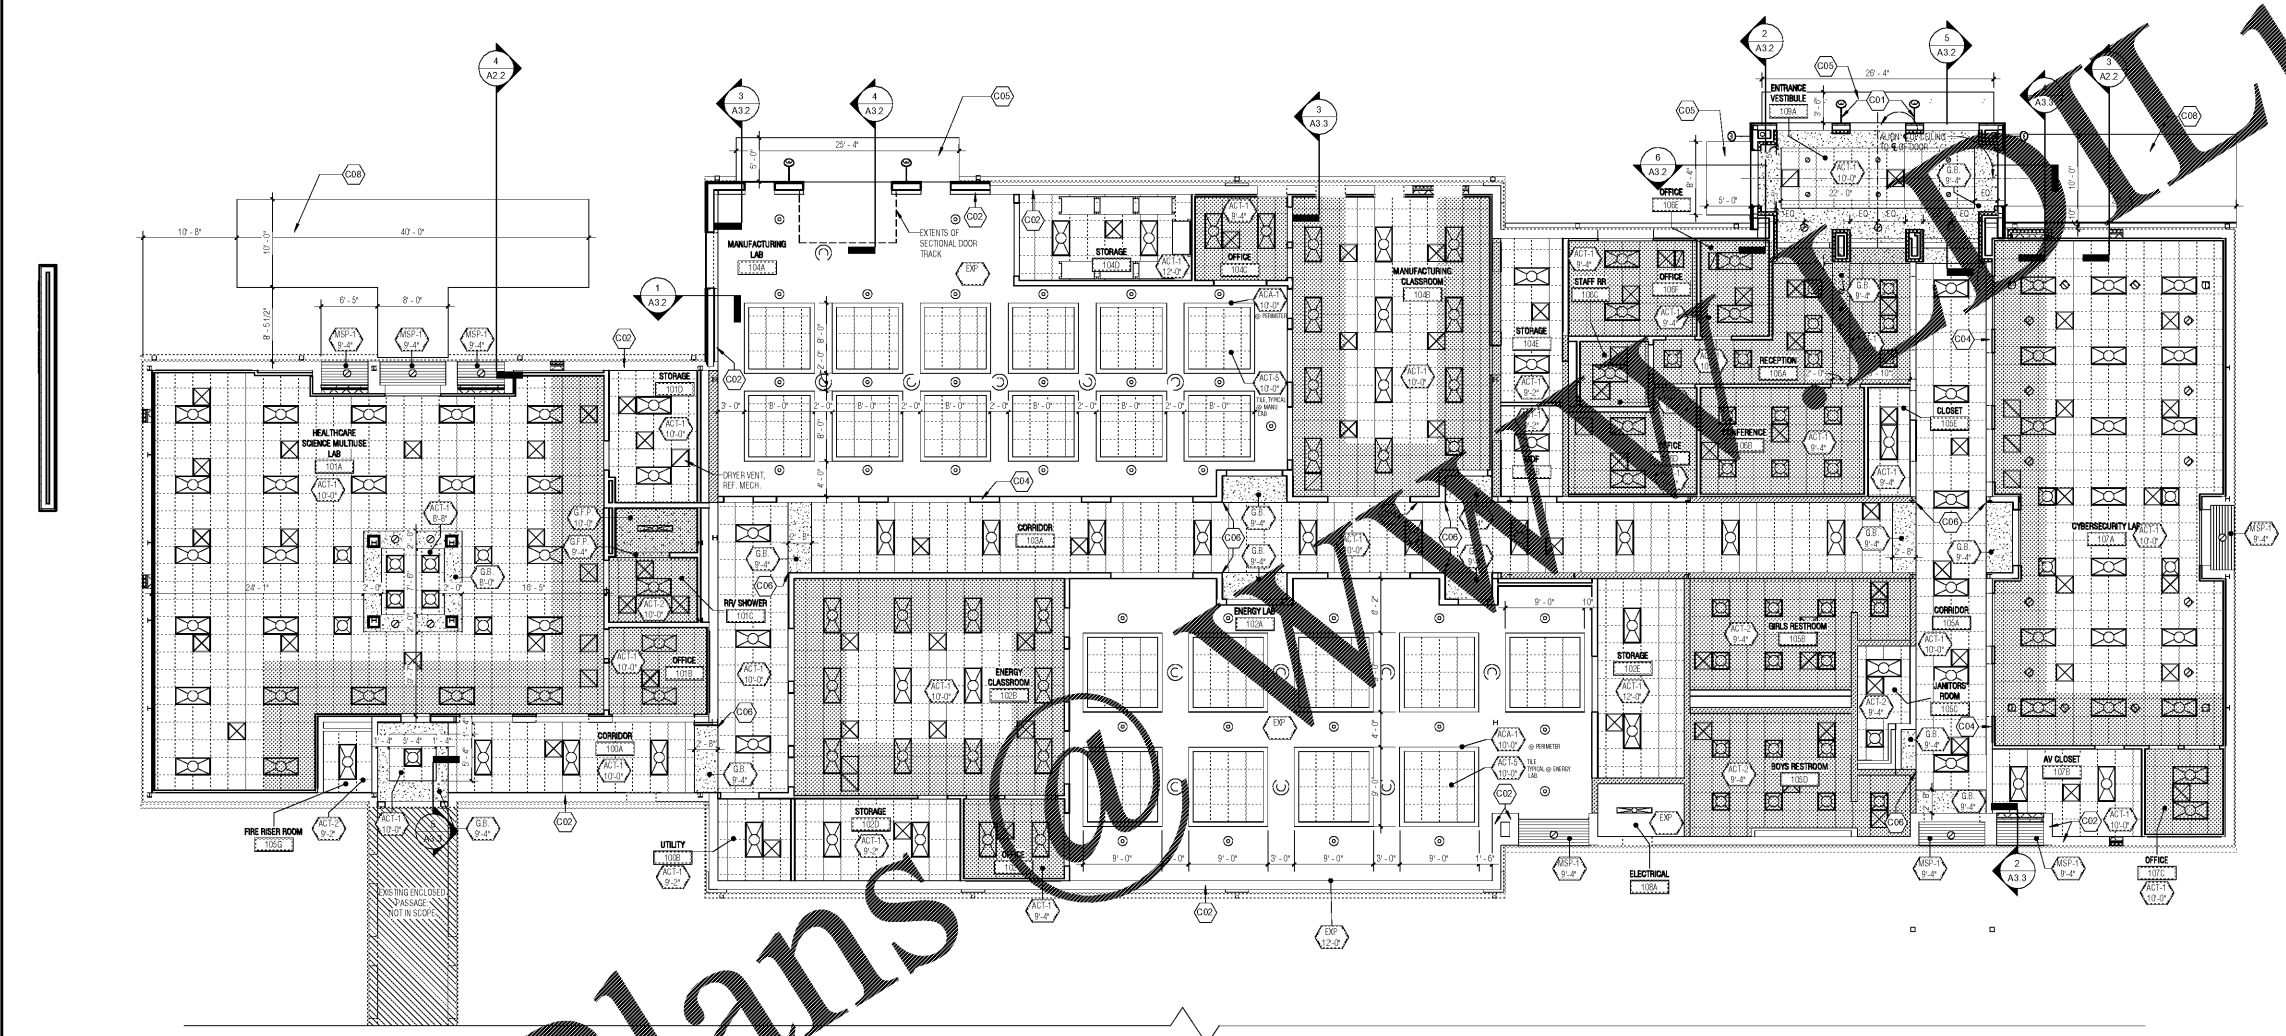

REFLECTED CEILING PLAN LEGEND

- GENERAL NOTES**
- A. ALL MECHANICAL DEVICES AND LIGHT FIXTURES SMALLER THAN 2'-0" X 2'-0" SHALL BE CENTERED IN TILE.
 - B. WHERE ACOUSTICAL CEILING TILE IS DEFINED TO BE INSTALLED, PROVIDE ACT-1 (TYPE 1), UNLESS NOTED OTHERWISE.
 - C. CENTER ALL ACT CEILING SYSTEMS IN SPACE PROVIDED, UNLESS NOTED OTHERWISE.
 - D. SUSPENDED SOFFITS SHALL BE TIED BACK TO SUPERSTRUCTURE WITH STEEL ANGLES, REF. STRUCTURAL FOR STANDARD DETAILS.
- DRAWING NOTES (C#)**
- CD1: NEW DECORATIVE LIGHT FIXTURE - REF. ELECTRICAL.
 - CD2: NEW 4'-0" x 4'-0" SQUARE 2' x 2' MTL STUDS @ 18" O.C. ABOVE EXIST. CMU TO 6" MIN. A.F.C.
 - CD3: EXTEND CORRIDOR WALLS MIN. 3/2" A.F.C. TO ALLOW 3/8" HOOK INSTALLATION. REF. ELECTRICAL.
 - CD4: PRE-FINISHED PRE-ENGINEERED ALUMINUM CANOPY ASSEMBLY SUPPORTED FROM BUILDING'S STRUCTURE.
 - CD5: ALLOY SOFFIT WITH ADJACENT WALL. PROVIDE VERTICAL CONTROL JOINT AT CORNER LOCATIONS TYP.
 - CD6: PRE-FINISHED PRE-ENGINEERED ALUMINUM CANOPY ASSEMBLY - FREESTANDING. REF. SIDEWALK PLAN.

- INTERIOR PARTITION LEGEND**
- EXISTING WALLS TO REMAIN THAT CONTINUE UP TO DECK.
 - CMU TO FINISHED CEILING, G.P. BOARD ABOVE.
- SYMBOL LEGEND**

- ROOM NAME**
- A100A - ROOM NUMBER
- CEILING MATERIAL: SEE BELOW
- INSTALL HEIGHT
- ACT-1: TYPE 1, TYPICAL
 - ACT-2: TYPE 2, SUSPENDABLE
 - ACT-3: TYPE 3, HIGH R/C
 - ACT-4: ACOUSTICAL CLOUD ASSEMBLY (PERIMETER) TO RECEIVE ACT-3
 - EXP: EXPOSED STRUCTURE
 - G.B.: GYPSUM BOARD
 - G.F.P.: ABUSE RESISTANT GYPSUM BOARD
 - MSP-1: NEW METAL SOFFIT PANEL
 - EXISTING: NOT IN SCOPE
 - NEW SOUND ATTENUATION BLANKETS - INSTALL 6" FROM FACE OF WALL, UNLESS SHOWN OTHERWISE
 - HARD CEILING
- 2x4 RECESSED LIGHT FIXTURE
 - 2x2 RECESSED LIGHT FIXTURE
 - 1x4 LIGHT FIXTURE
 - PENDANT LIGHT FIXTURE
 - RECESSED CAN
 - RGRW LIGHT FIXTURE
 - SUPPLY (ACT)
 - RETURN/EXHAUST
 - SUPPLY
 - DRAWING NOTE REFERENCE - REFER TO DRAWING NOTES ABOVE
- SM
A101 WALL SECTION

1 REFLECTED CEILING PLAN
 SCALE: 1/8" = 1'-0"