

RECEIVED  
 APR 05 2013  
 MISSOURI STATE DEPT. OF REVENUE  
 SPRINGFIELD, MO

**ECP LABELING**  
 LABEL EACH ECP PER O'REILLY TERMINOLOGY WITH EXACTLY THE SAME UNIQUE IDENTIFYING "CODE" AS SHOWN ON THE "HVAC PLAN" ON SHEET M1 (FOR EXAMPLE: RTU-1, RTU-2, ETC. OR FURN-1, FURN-2, ETC.).



**CRAIG A. SCHNEIDER, AIA**  
 ARCHITECT

417.862.0558  
 417.862.2285  
 architect@craftystandard.com






PROJECT:  
**NEW O'REILLY AUTO PARTS STORE**  
**HWY 67**  
**PRICEVILLE, AL**

**O'Reilly AUTO PARTS**  
 CORPORATE OFFICES  
 233 SOUTH PATTERSON  
 SPRINGFIELD, MISSOURI 65802  
 (417) 862-2874 TELEPHONE

COMM # 4160  
 DATE: 4-6-18  
 REVISION  
 DATE:

VS2 of 3

DRAWN BY: CEV

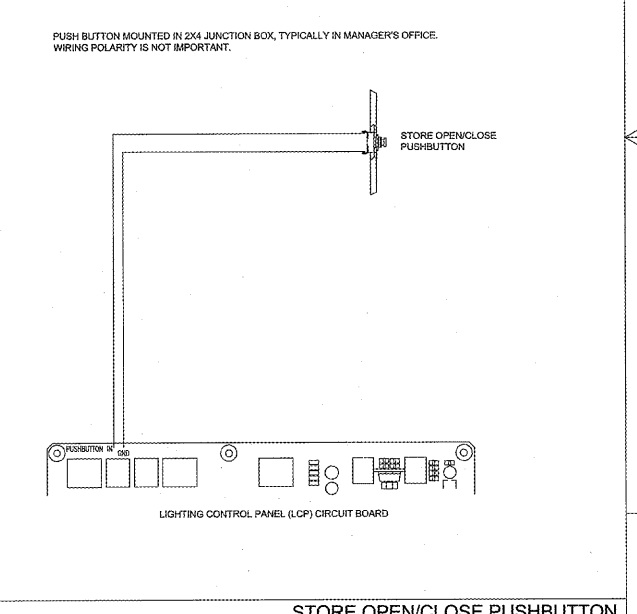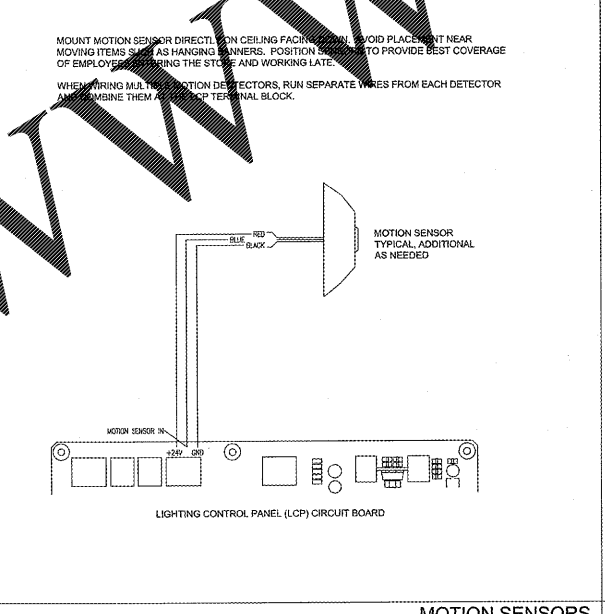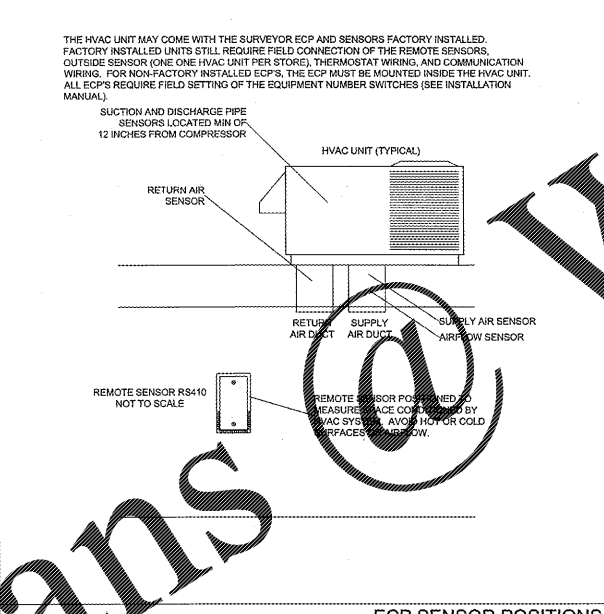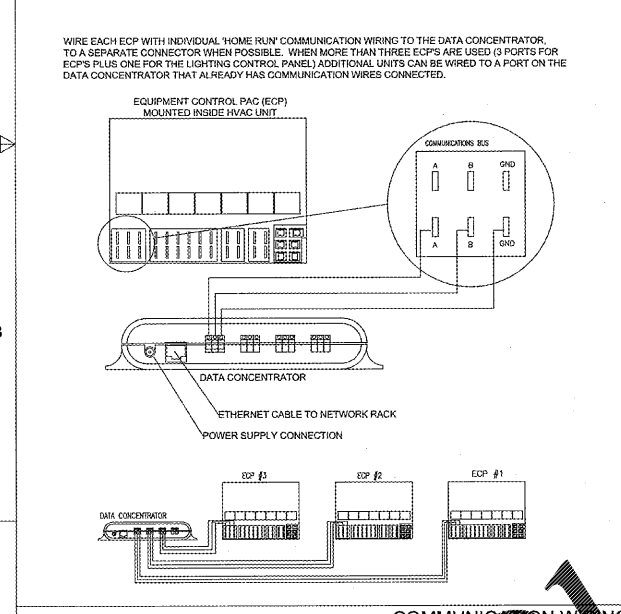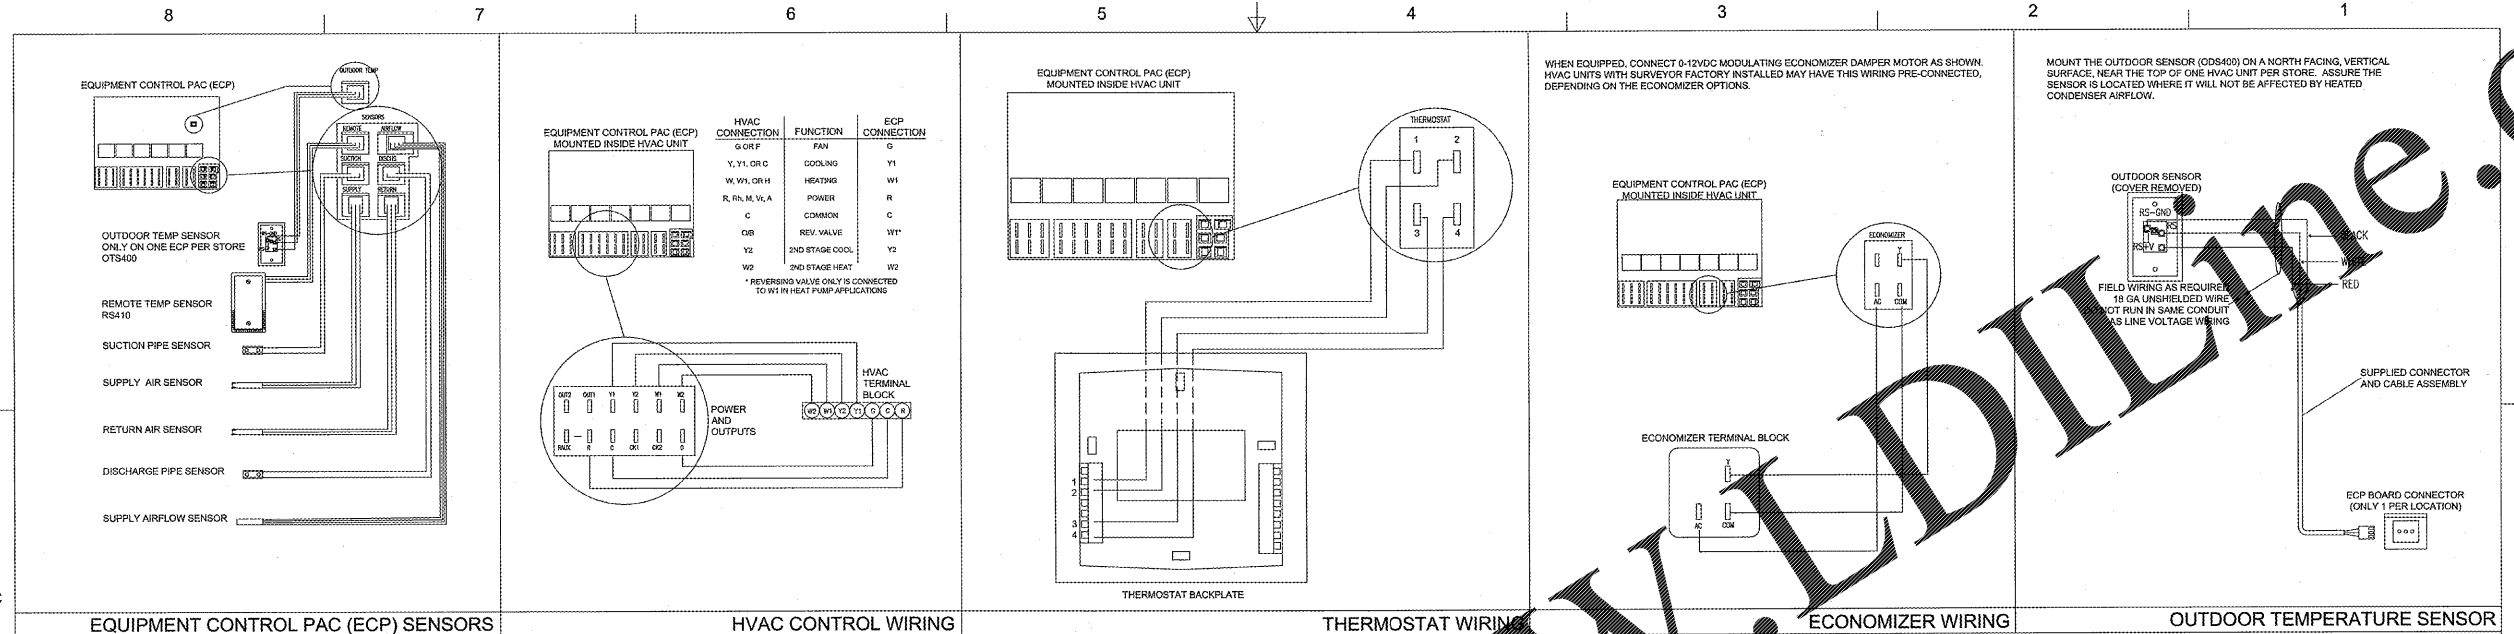

**GENERAL NOTES:**

- DRAWING FOR GENERAL INFORMATION ONLY.
- LOCAL BUILDING CODES AND BUILDING PLANS, AND STORE TAKE PRECEDENCE OVER THIS DOCUMENT.
- REFER TO THE SURVEYOR MANUAL, AND INSTALLATION INSTRUCTIONS FOR EACH COMPONENT FOR ADDITIONAL CRITICAL INFORMATION.
- SOME HVAC UNITS ARE AVAILABLE WITH THE SURVEYOR ECP AND SENSORS PRE-INSTALLED. THE REMOTE SENSOR AND ONE OUTSIDE SENSOR PER STORE WILL NEED TO BE CONNECTED IN THE FIELD TO THE ECP.
- ALL ECP'S REQUIRE SETTING OF THE EQUIPMENT NUMBER DIP SWITCHES, AND HEAT PUMP JUMPERS AS APPROPRIATE. REFER TO THE EQUIPMENT CONTROL PAC INSTALLATION INSTRUCTIONS FOR FURTHER INFORMATION.
- ALL WIRING IS 18 GA UNSHIELDED, OR TWISTED PAIR.

- WIRING MAY BE RUN IN CONDUIT OR WIRE TIED IN BUNDLES.
- DO NOT RUN COMMUNICATION AND SENSOR WIRES IN THE SAME CONDUIT OR BUNDLE WITH CONTROL AND LINE VOLTAGE WIRES.
- CAUTION! INSTALLATION REQUIRES REMOVAL OF SAFETY COVERS AND EXPOSE THE INSTALLER TO ELECTRICAL HAZARDS. USE OF A LICENSED ELECTRICIAN IS REQUIRED. FOLLOW ALL APPROPRIATE SAFETY PRECAUTIONS. ADDITIONAL SAFETY INFORMATION IS IN THE SURVEYOR INSTALLATION MANUALS.

|              |   |           |          |                               |         |
|--------------|---|-----------|----------|-------------------------------|---------|
| VENSTAR INC. |   | SURVEYOR  |          | O'REILLY INSTALLATION DETAILS |         |
| C            | REMOVED MOTION DETECTOR NOTE IN DETAIL MOTION SENSORS         | JH        | 01-24-18 | SIZE                          | DATE    |
| B            | REMOVED THE WORD "NOT IN NOTE IN "OUTER OUTDOOR TEMP. SENSOR" | JH        | 12-28-17 | D                             | 9-13-13 |
| A            | ADDED ECP LABELING  | JH        | 10-8-17  | SCALE                         | NONE    |
| DRAWN        |   | C. GODWIN |          | SHEET 1 OF 1                  |         |

