
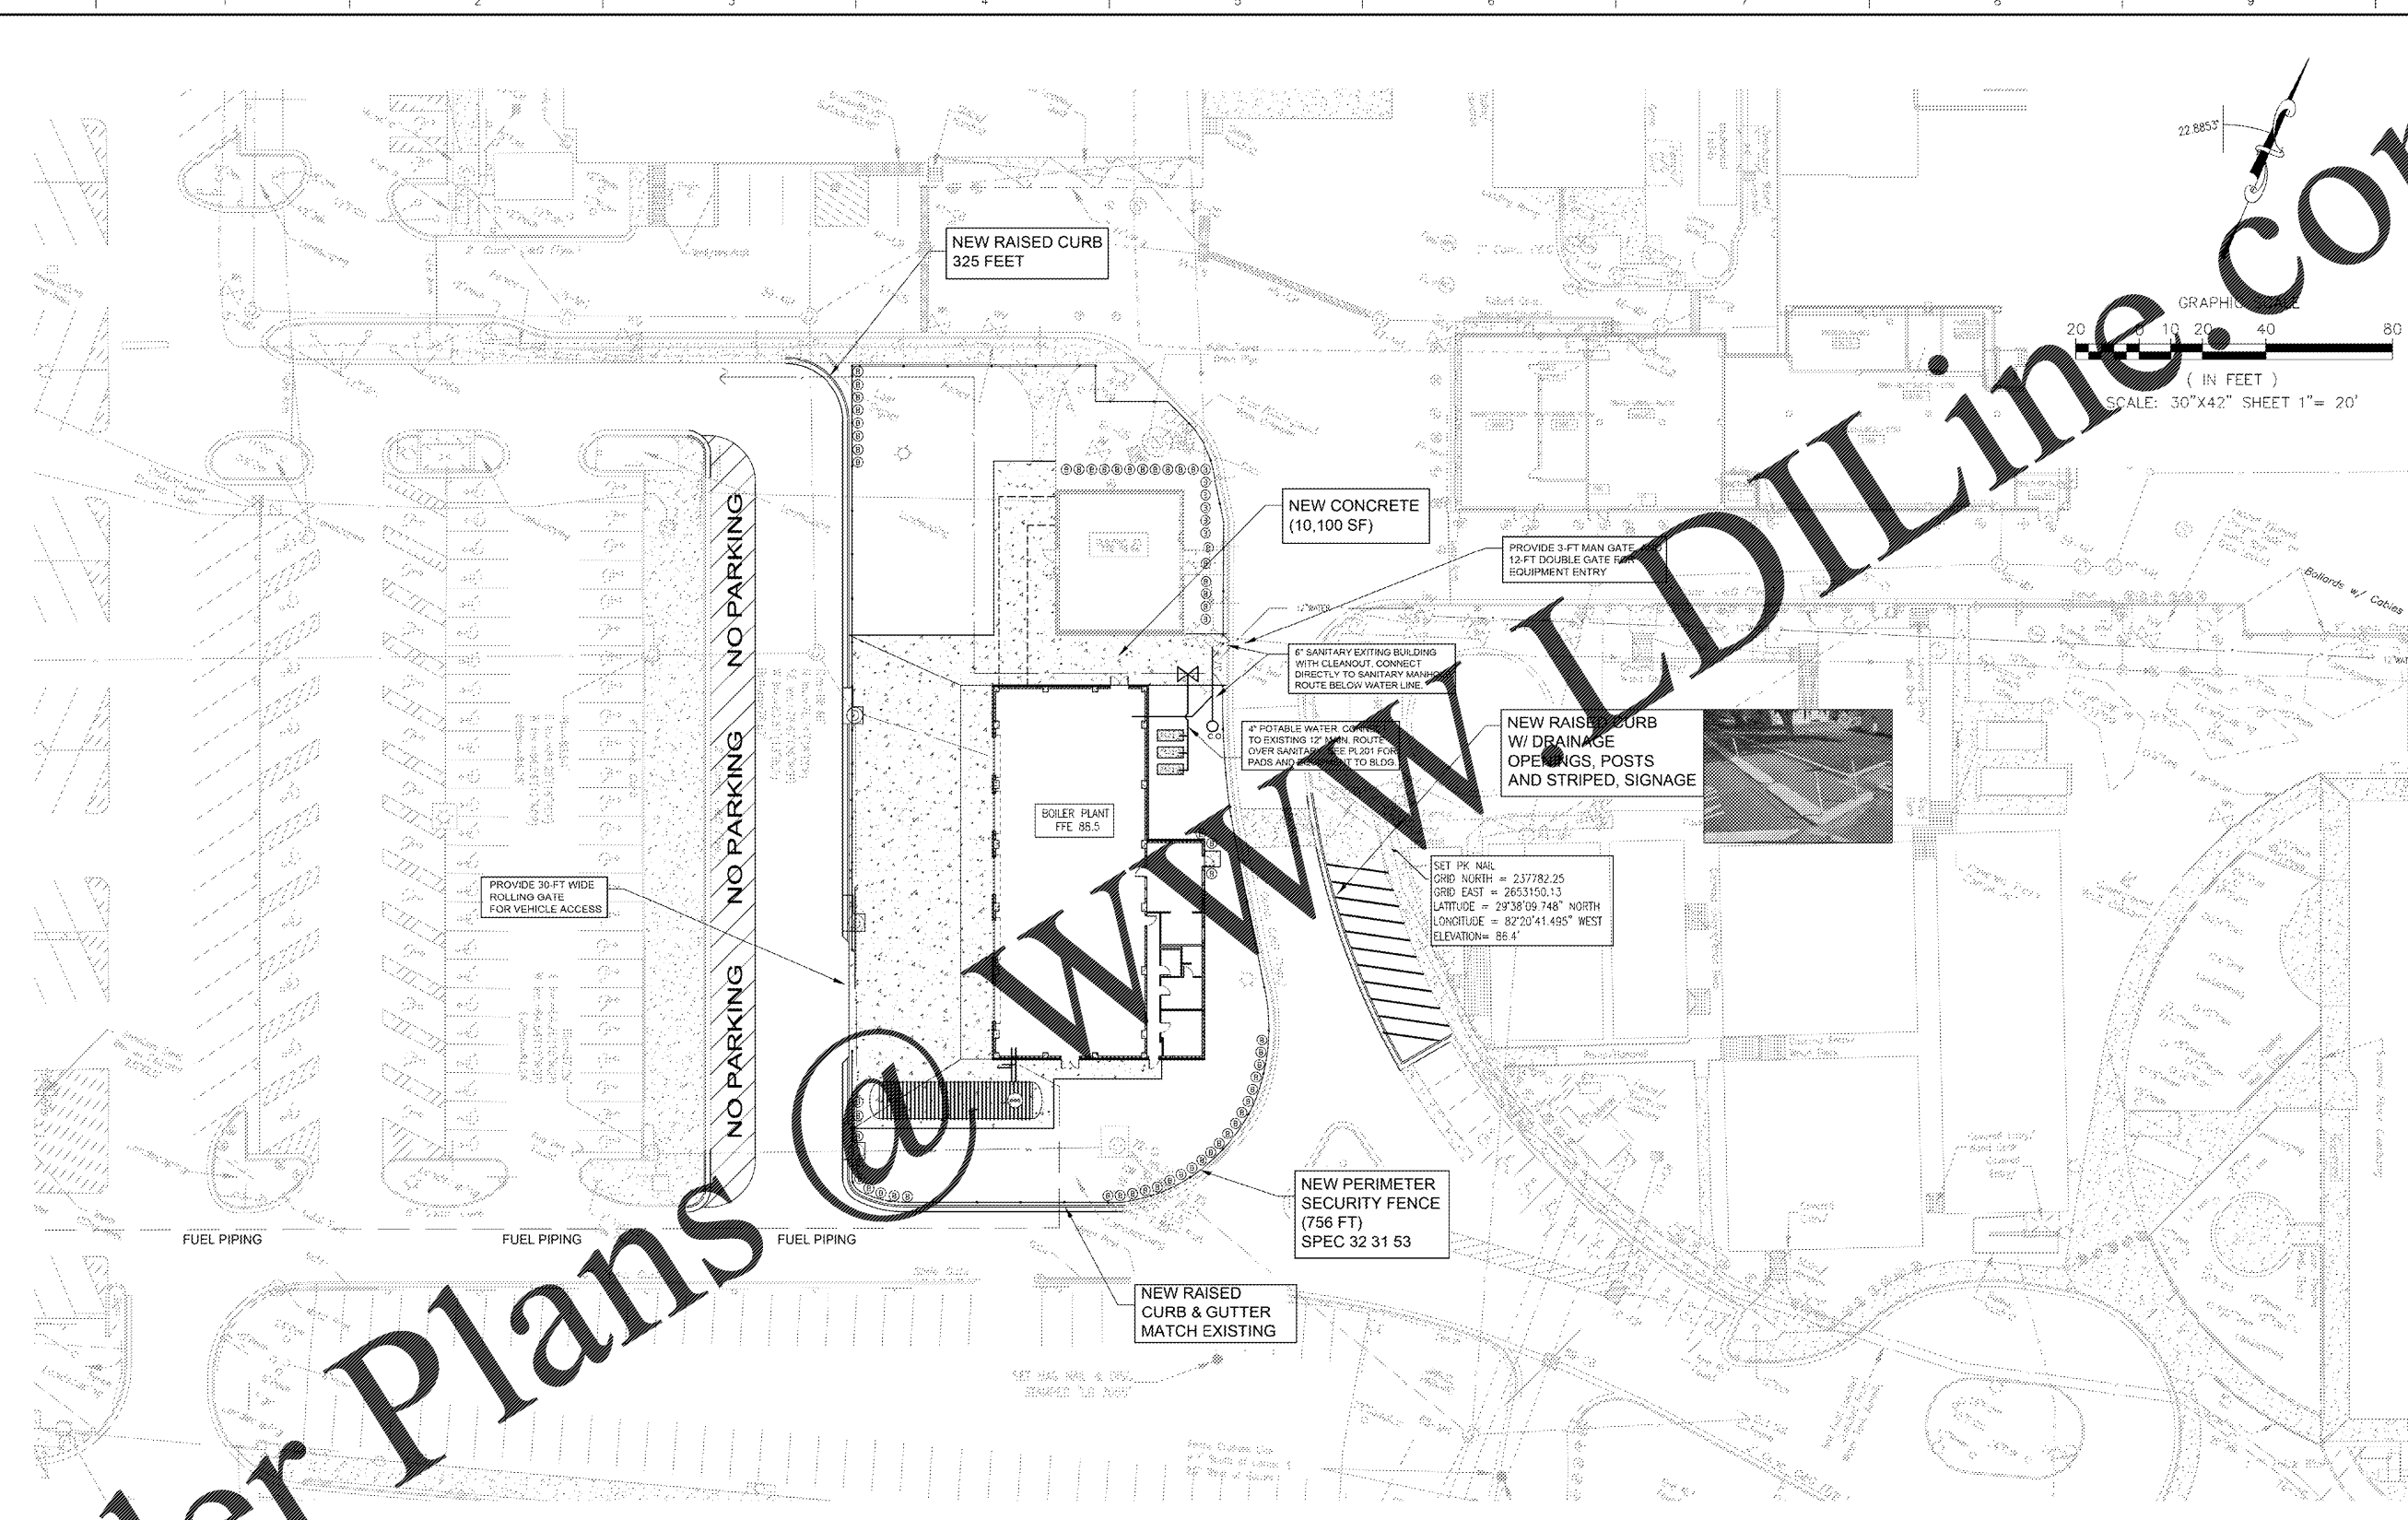


36C209180271

one eighth inch = one foot
 one quarter inch = one foot
 one half inch = one foot
 three eighths inch = one foot
 one inch = one foot
 one and one half inches = one foot
 three inches = one foot

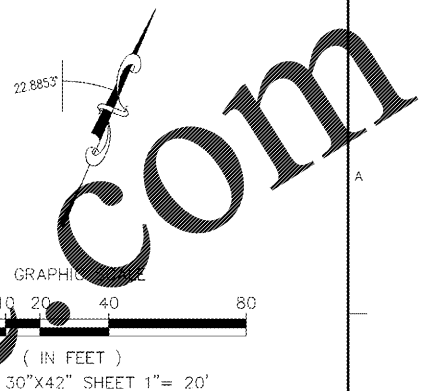

Order Plans

FINAL DESIGN
 APPROVED FOR CONSTRUCTION

Revisions: _____ Date: _____	CONSULTANTS: 	ENGINEER-OF-RECORD MICHAEL D. TADOTI No. 67618 STATE OF FLORIDA PROFESSIONAL ENGINEER FL PE 67618	ARCHITECT/ENGINEERS: AKEA INC. 3803 NW 98th Street, Suite B Gainesville, FL 32606 Phone: (352) 474-6124 Fax: (352) 553-4437 ODA: FL #26693 AKEA Project No. 083-14	Drawing Title: SITE PLAN Approved: Project Director	Project Title: REPLACE BOILERS - FCA D. ENERGY AT THE MALCOM RANDALL VAMC Location: GAINESVILLE, FLORIDA Date: MARCH 9, 2016 Checked: MDT Drawn: JG	Project Number: 573-14-600 Building Number: Drawing Number: C300 10 OF 127	Office of Construction and Facilities Management Department of Veterans Affairs
	VA FORM 08-6231						