



Revisions:

| | |
|---|--|
| 1 | |
| 2 | |
| 3 | |
| 4 | |
| 5 | |

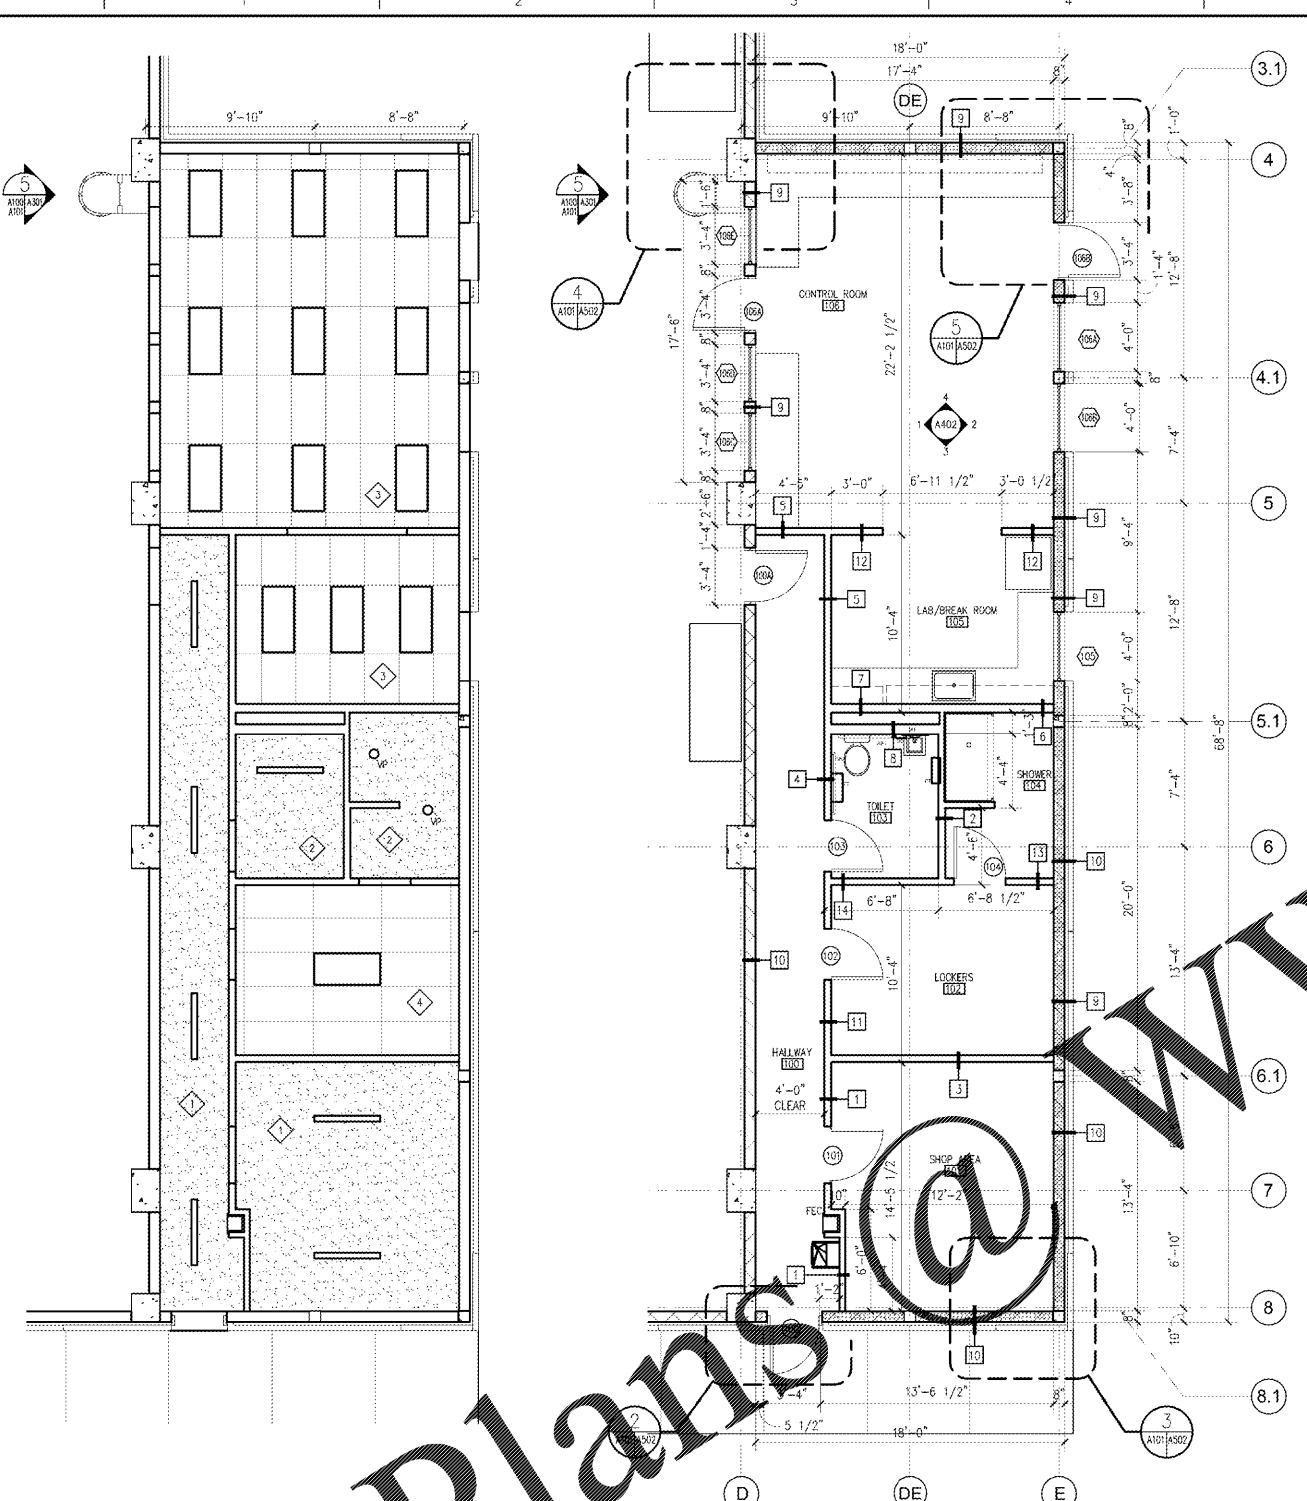


2 ENLARGED REFLECTED CEILING PLAN
SCALE: 1/4"=1'-0"

1 ENLARGED FLOOR PLAN
SCALE: 1/4"=1'-0"

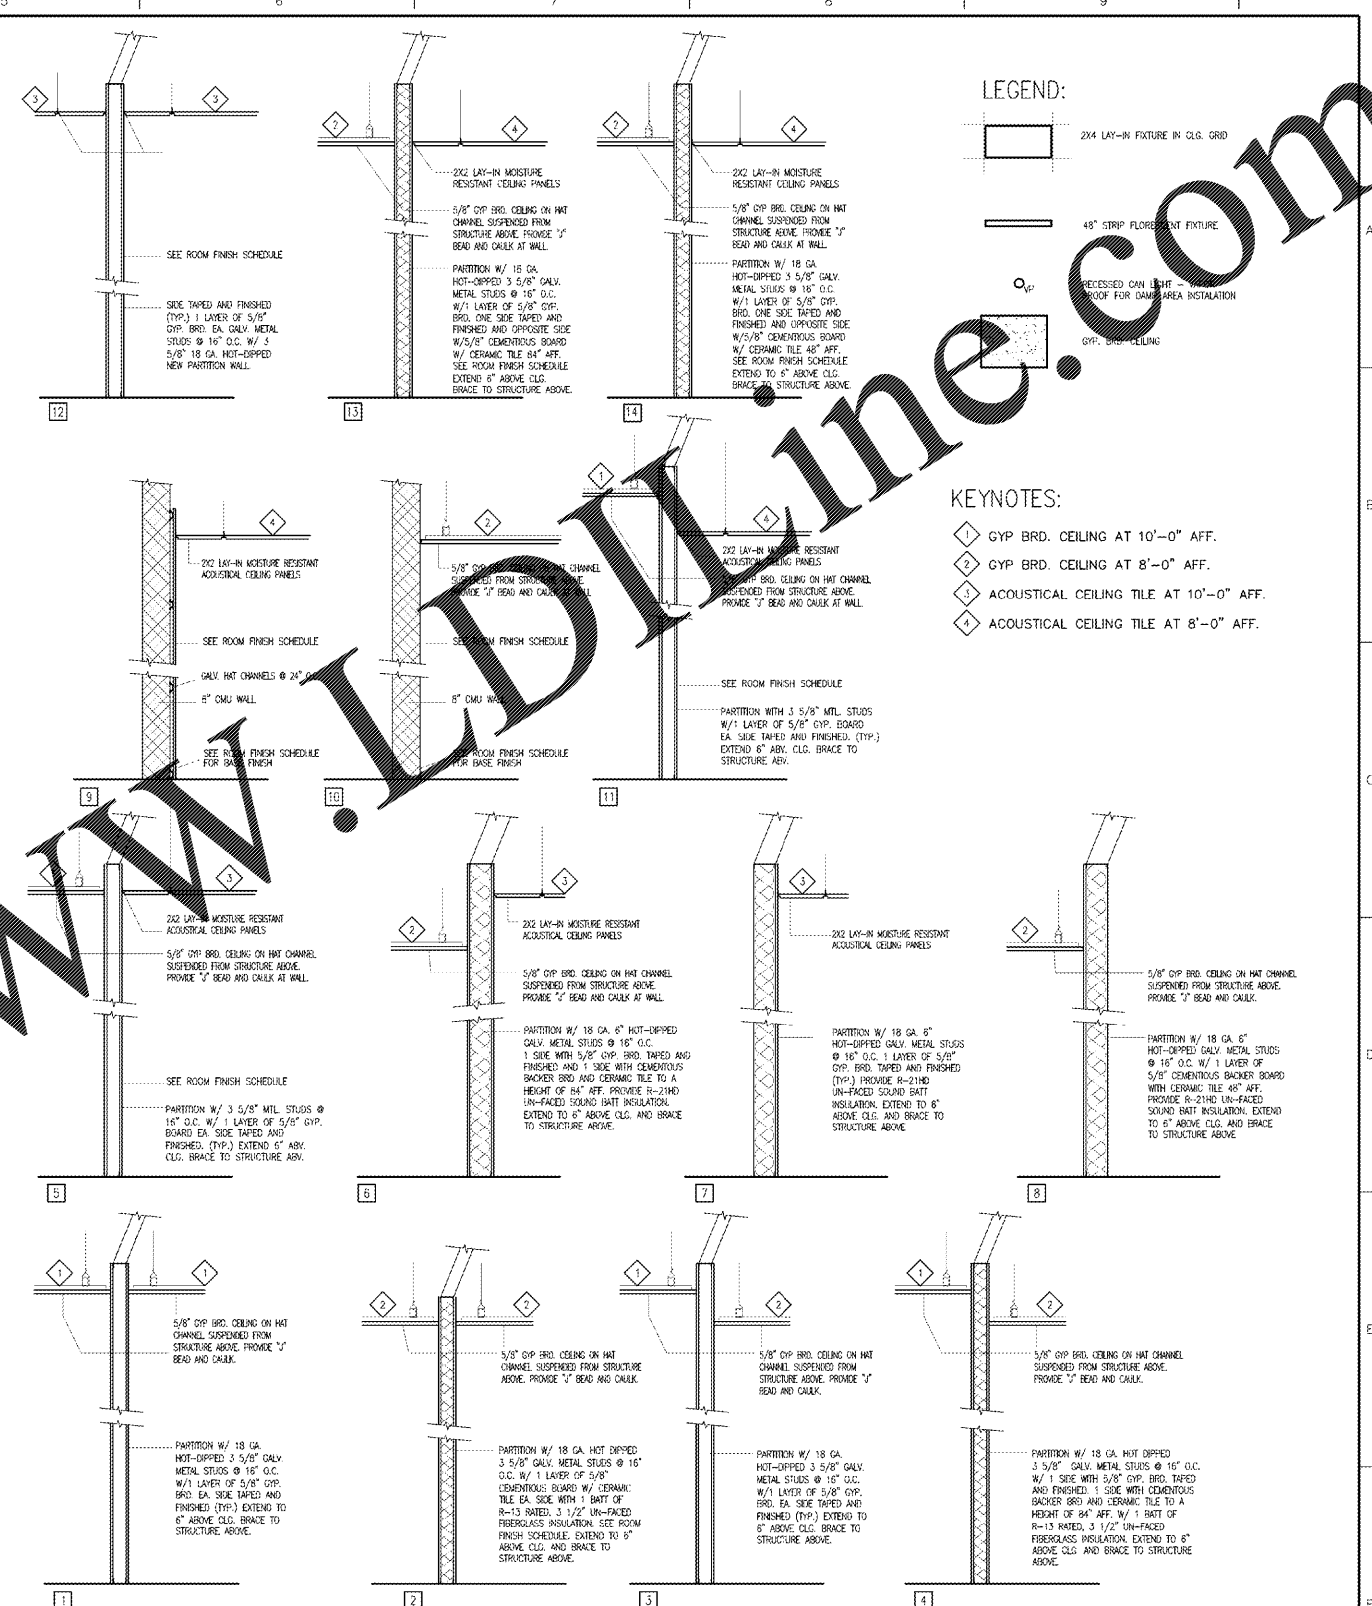

PARTITION TYPES
SCALE: 1/2"=1'-0"

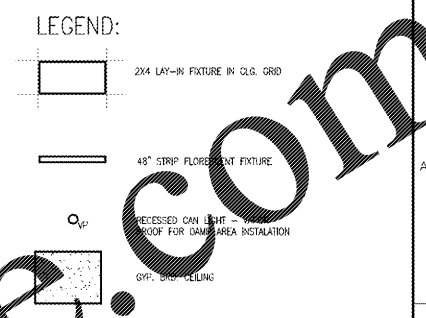

- KEYNOTES:
- 1 GYP BRD. CEILING AT 10'-0" AFF.
 - 2 GYP BRD. CEILING AT 8'-0" AFF.
 - 3 ACOUSTICAL CEILING TILE AT 10'-0" AFF.
 - 4 ACOUSTICAL CEILING TILE AT 8'-0" AFF.

FINAL DESIGN
APPROVED FOR CONSTRUCTION

| | | | | | | | | |
|------------------------------|--|--|--|--|--|-------------------------------------|--|--|
| CONSULTANTS: | ARCHITECT/ENGINEERS: AKEA INC. 3803 NW 95th Street, Suite B Gainesville, FL 32606 Phone: (352) 474-6124 Fax: (352) 553-4437 QJA: FL #26693 AKEA Project No. 083-14 | Drawing Title ENLARGED PLAN - REFLECTED CEILING PLAN - AND PARTITION TYPES | | Project Title REPLACE BOILERS - FCA D. ENERGY AT THE MALCOM RANDALL VAMC | | Project Number 573-14-600 | | Office of Construction and Facilities Management Department of Veterans Affairs |
| | | Approved: Project Director | | Location GAINESVILLE, FLORIDA | | Building Number | | |
| Date MARCH 9, 2018 | | Checked THG | | Drawn JG | | Drawing Number A101 | | 28 OF 127 |

Order Plans @ www.wdwonline.com