



POLE BASE AND FIXTURE RE-MOUNTING DETAIL
SCALE: N.T.S.

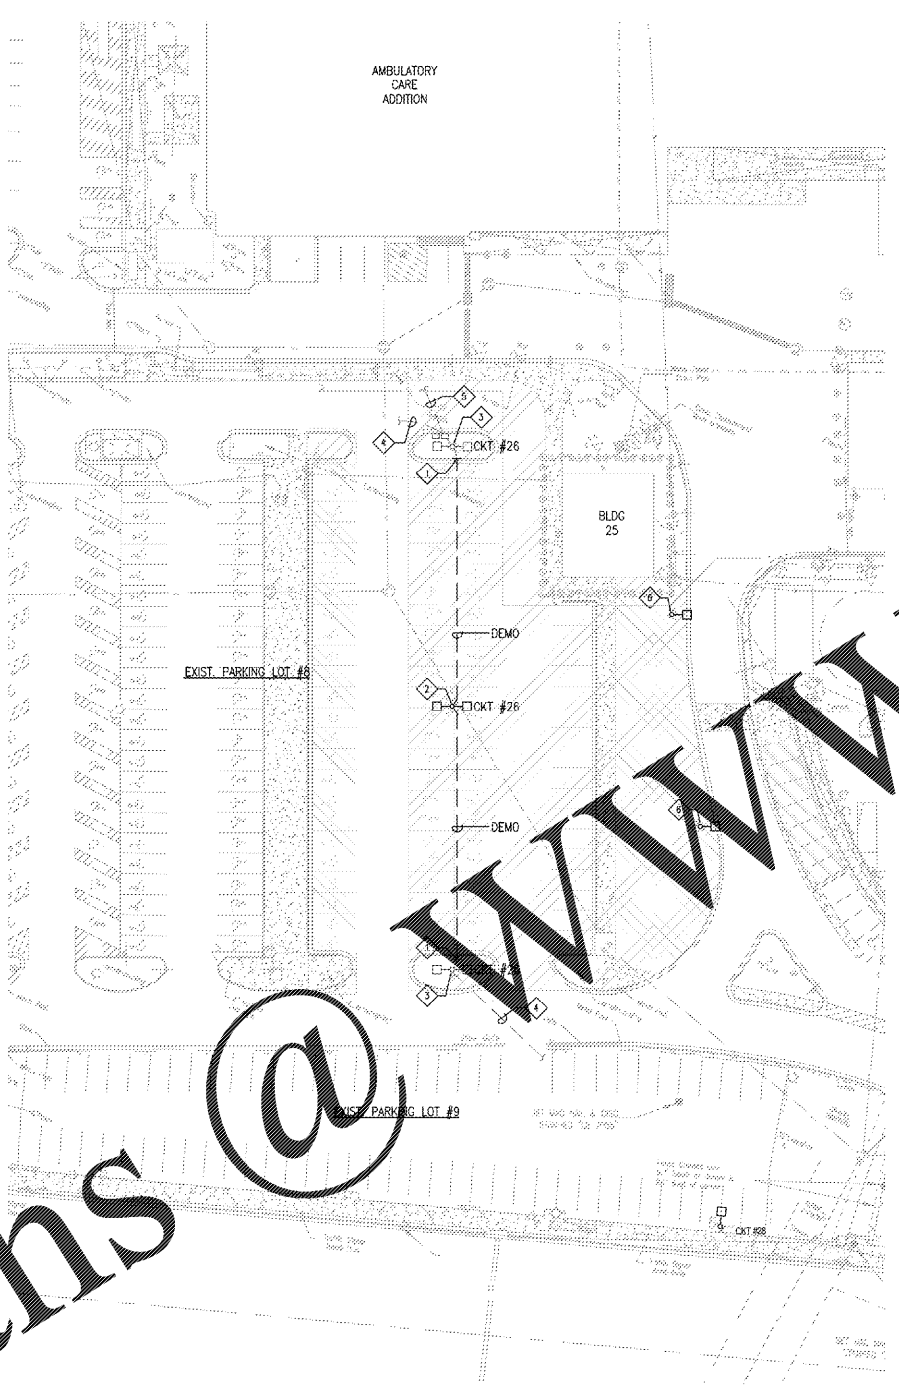

SITE PLAN - LIGHTING DEMO
SCALE: 1" = 30'

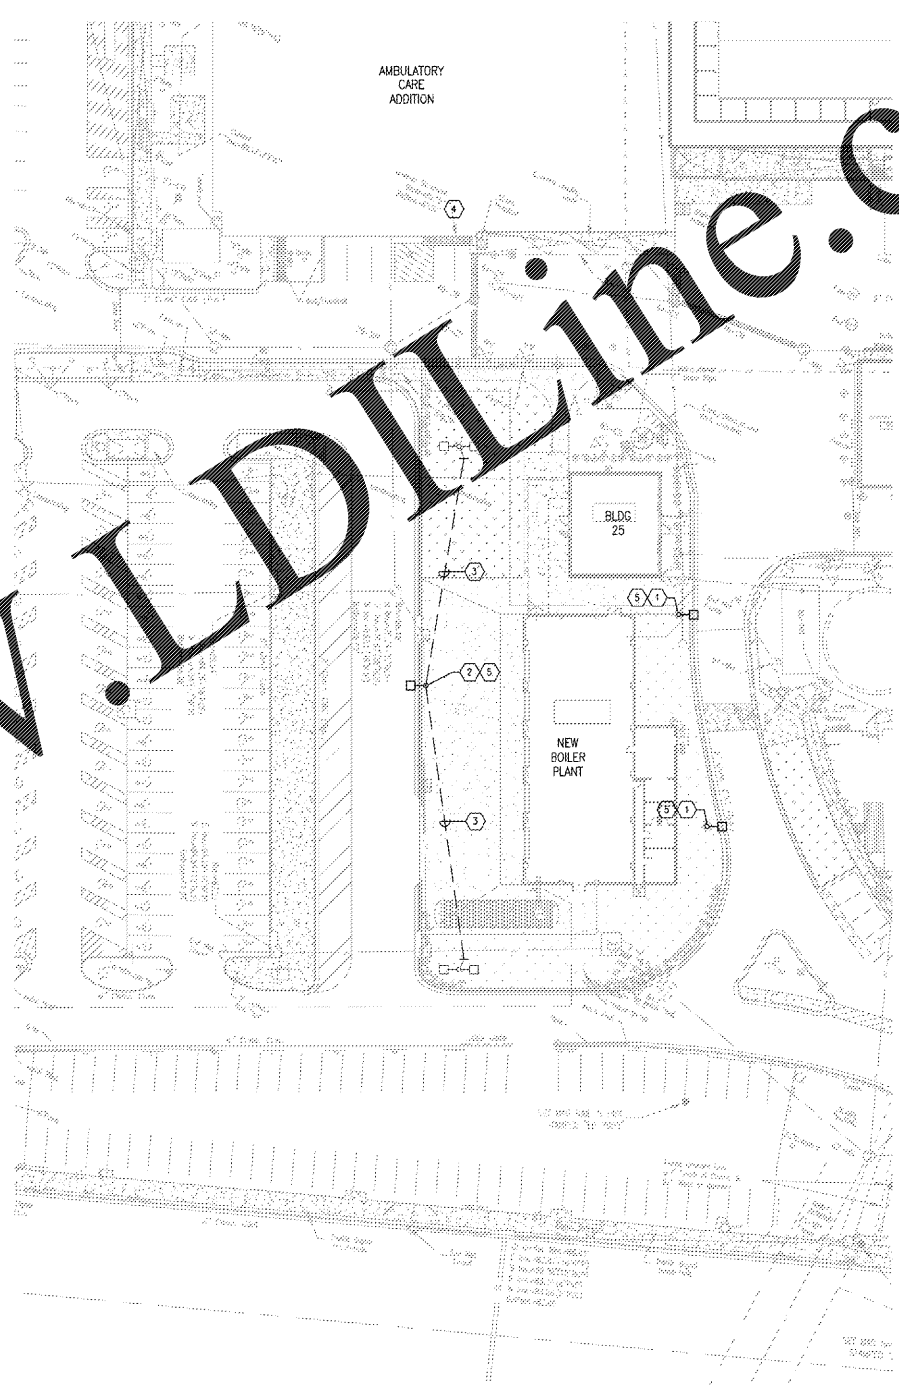

SITE PLAN - LIGHTING NEW
SCALE: 1" = 30'

◇ DEMO KEYNOTES

1. INTERCEPT EXISTING CONDUITS 5' FROM EXISTING POLE BASE.
2. REMOVE AND STORE POLE, HAND HOLE AND FIXTURE. DEMOLISH POLE BASE, CONDUITS, INTERCEPT POINTS.
3. EXIST. TO REMAIN FIXTURE.
4. EXISTING CONDUITS TO DOWNSTREAM FIXTURES TO REMAIN.
5. EXISTING CONDUITS TO BUILDING TO REMAIN.
6. REMOVE AND STORE POLE, HAND HOLE AND FIXTURE. PROVIDE TEMPORARY PROTECTION FOR CONDUITS.

○ NEW KEYNOTES

1. RE-INSTALL POLE, BOX, AND FIXTURE ON EXISTING BASE. REPLACE DAMAGED CONDUITS AS REQUIRED.
2. PROVIDE NEW CONCRETE BASE TO MATCH EXISTING. RE-INSTALL POLE, HAND HOLE, AND (1) FIXTURE (SEE DETAIL) IN NEW LOCATION. DELIVER SECOND FIXTURE HEAD TO VA. COORDINATE PLACEMENT OF FIXTURE BASE TO ACCOMMODATE FENCE AND SLIDING GATE. CENTER POLE BASE ALONG SPACE BETWEEN ROLLUP DOORS. REFER TO CIVIL AND APPROVED FENCE/GATE SHOP DRAWINGS.
3. PROVIDE NEW CONDUIT AND CONDUITS AS FOLLOWS:
1" C. W/ 2#8, 2#8N, #8G
1" C. SPARE
3/4" C. SPARE
4. APPROXIMATE LOCATION FOR EXISTING LIGHTING PANEL ALG IN ELECTRICAL CLOSET F828J-1.
5. PROVIDE NEW LAMP IN EXISTING FIXTURE TO MATCH EXISTING TYPE/WATTAGE.

Order Plans

@

WWW.LDILine.com

FINAL DESIGN
APPROVED FOR CONSTRUCTION

CONSULTANTS: 		ENGINEER-OF-RECORD CHAD J. FRUECK FL P.E. NO. 73817 		ARCHITECT/ENGINEERS: AKEA INC. 3803 NW 98th Street, Suite B Gainesville, FL 32606 Phone: (352) 474-6124 Fax: (352) 553-4437 OIA: FL #26693 AKEA Project No. 083-14		Drawing Title SITE LIGHTING - MODIFICATIONS Approved: Project Director		Project Title REPLACE BOILERS - FCA D, ENERGY AT THE MALCOM RANDALL VAMC Location GAINESVILLE, FLORIDA Date MARCH 9, 2016 Checked CUF Drawn KLL		Project Number 573-14-600 Building Number Drawing Number EL111 104 OF 127		Office of Construction and Facilities Management 	
------------------	--	---	--	--	--	--	--	--	--	---	--	---	--